


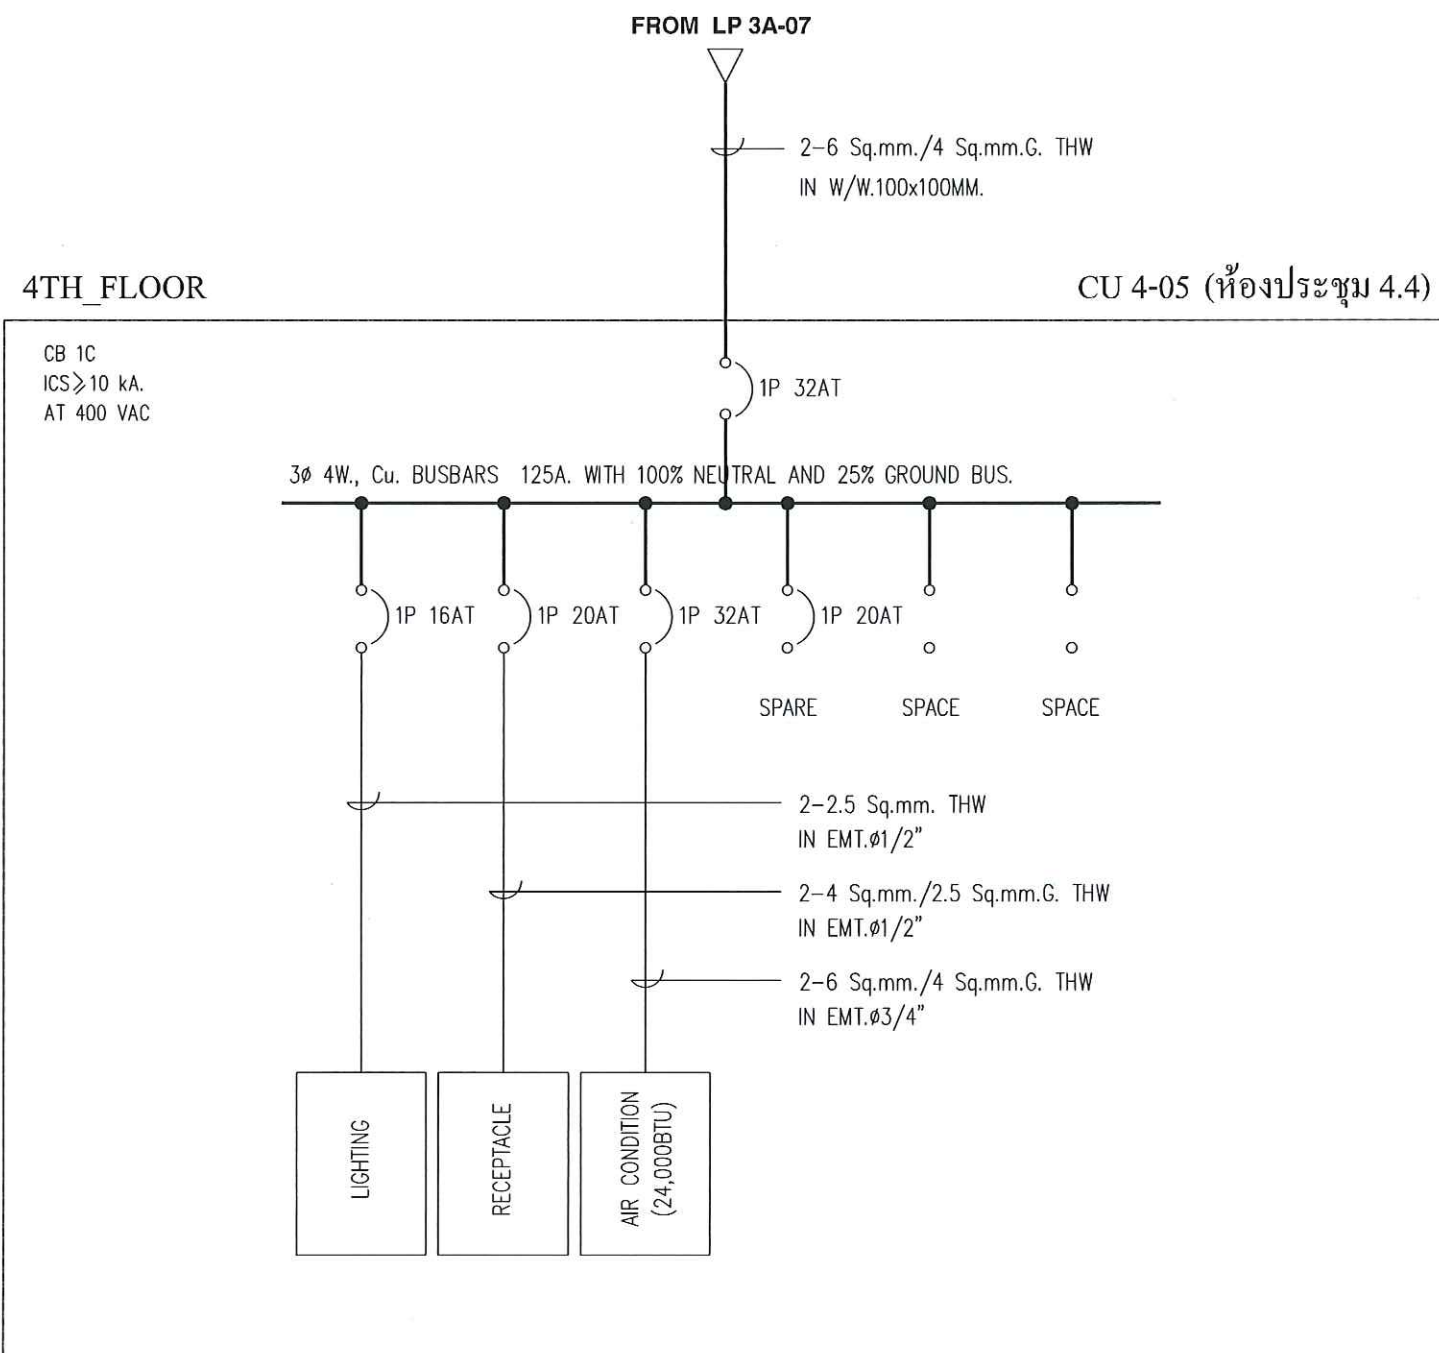

OWNER :

CONSULTANT :



King Mongkut's Institute  
of Technology Ladkrabang  
Chalongkrung Road, Ladkrabang, Bangkok 10520  
TEL. ( +66 ) 2-329-8000 , FAX. ( +66 ) 2-329-8204

CONTRACTOR :

PRELIMINARY

KEY PLAN

ENGINEER CERTIFICATION

|              |                       |
|--------------|-----------------------|
| SIGNATURE    |                       |
| NAME         | SONGKRIT TRERATPICHAN |
| REGISTER No. | วพท. 957              |

| REVISION |          |    |             |
|----------|----------|----|-------------|
| No.      | DATE     | BY | DESCRIPTION |
|          |          |    |             |
|          |          |    |             |
|          |          |    |             |
|          |          |    |             |
| 1        | 07/20/18 | -  | PRELIMINARY |

REVISION OF DRAWING : 0

PROJECT NAME :

Excise Department


DRAWING TITLE :

CU 4-05\_SINGLE LINE DIAGRAM

DRAWING No. :

EXD-20180720

|               |         |           |
|---------------|---------|-----------|
| SHEET : 5     | OF : 13 | SIZE : A3 |
| DATE :        | SCALE : | NTS       |
| DRAW BY :     |         |           |
| CHECKED BY :  |         |           |
| APPROVED BY : |         |           |

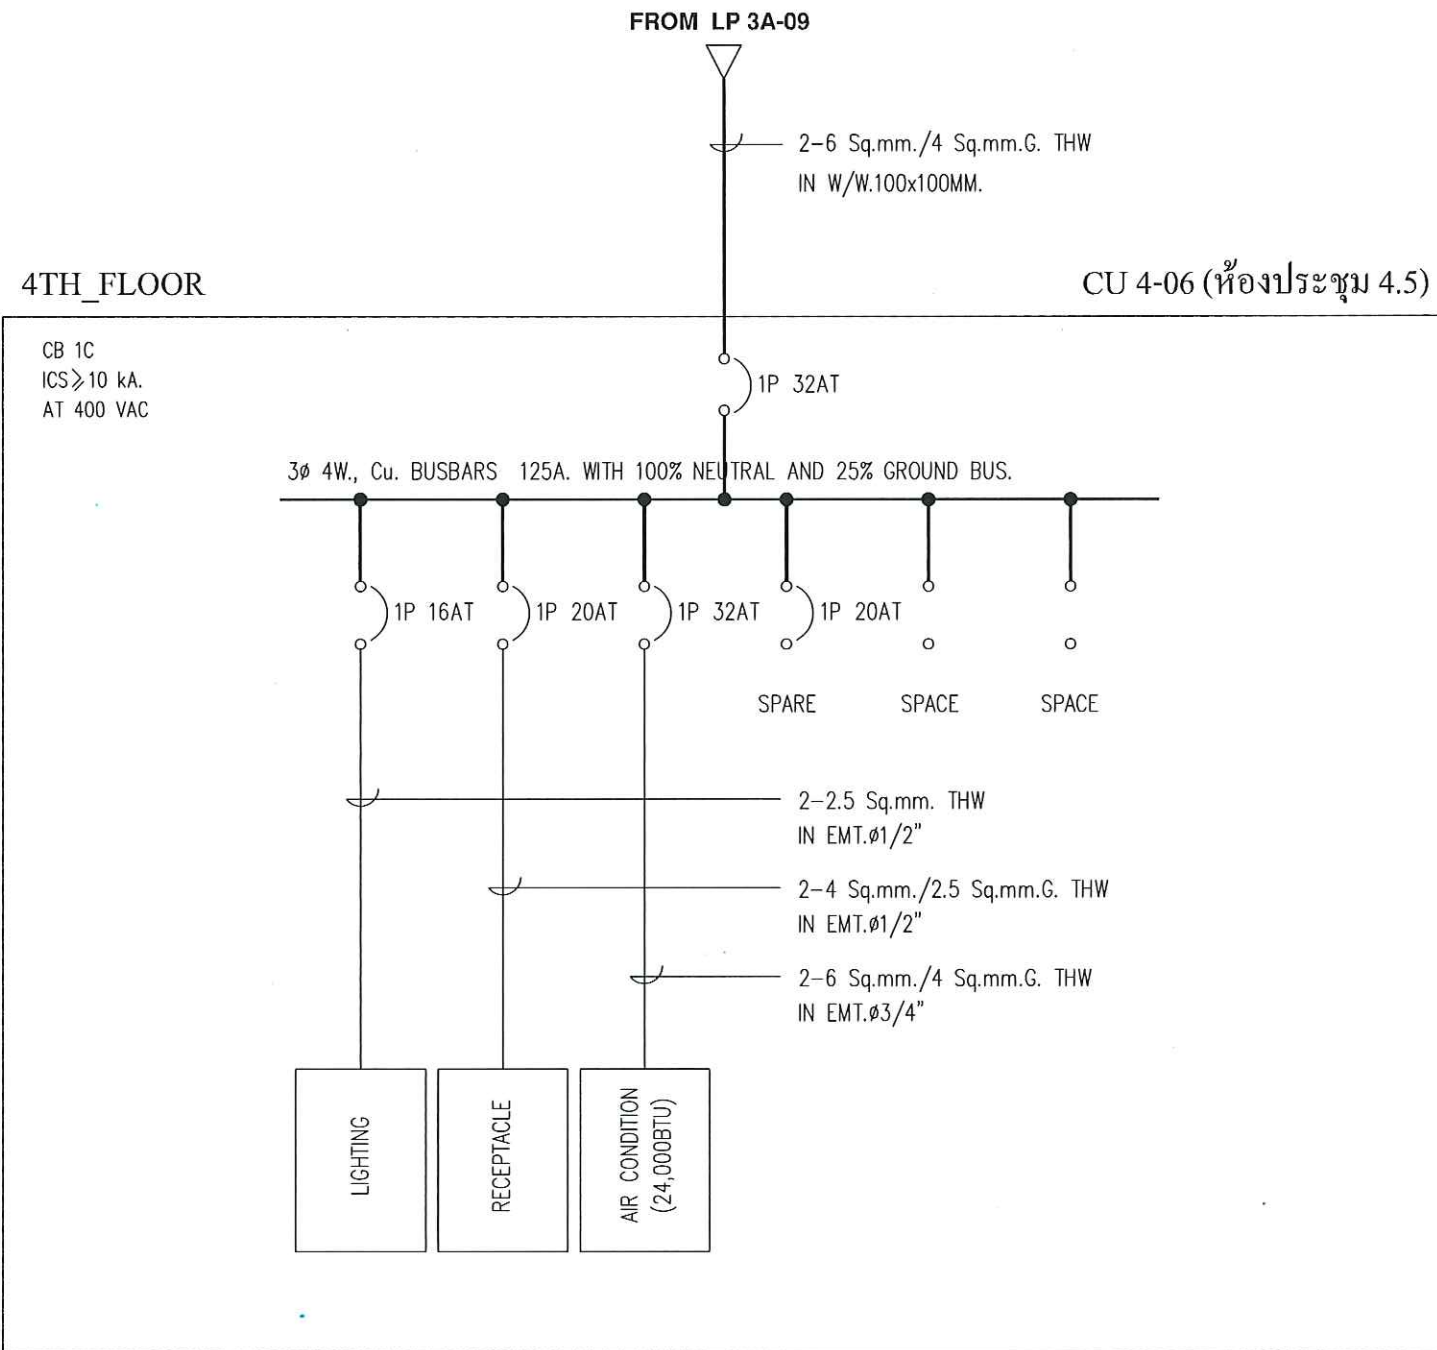

OWNER :

CONSULTANT :



King Mongkut's Institute  
of Technology Ladkrabang  
Chalongkrung Road, Ladkrabang, Bangkok 10520  
TEL ( +66 ) 2-329-8000 , FAX ( +66 ) 2-329-8204

CONTRACTOR :

PRELIMINARY

KEY PLAN

ENGINEER CERTIFICATION

|              |                       |
|--------------|-----------------------|
| SIGNATURE    |                       |
| NAME         | SONGKRIT TRERATPICHAN |
| REGISTER No. | วพค 957               |

REVISION

| No. | DATE     | BY | DESCRIPTION |
|-----|----------|----|-------------|
|     |          |    |             |
|     |          |    |             |
|     |          |    |             |
|     |          |    |             |
| 1   | 07/20/18 | -  | PRELIMINARY |

REVISION OF DRAWING : 0

PROJECT NAME :

Excise Department

DRAWING TITLE :

CU 4-06\_SINGLE LINE DIAGRAM

DRAWING No. :

EXD-20180720


SHEET : 6 OF : 13 SIZE : A3

DATE : SCALE :  
NTS

DRAW BY :

CHECKED BY :

APPROVED BY :

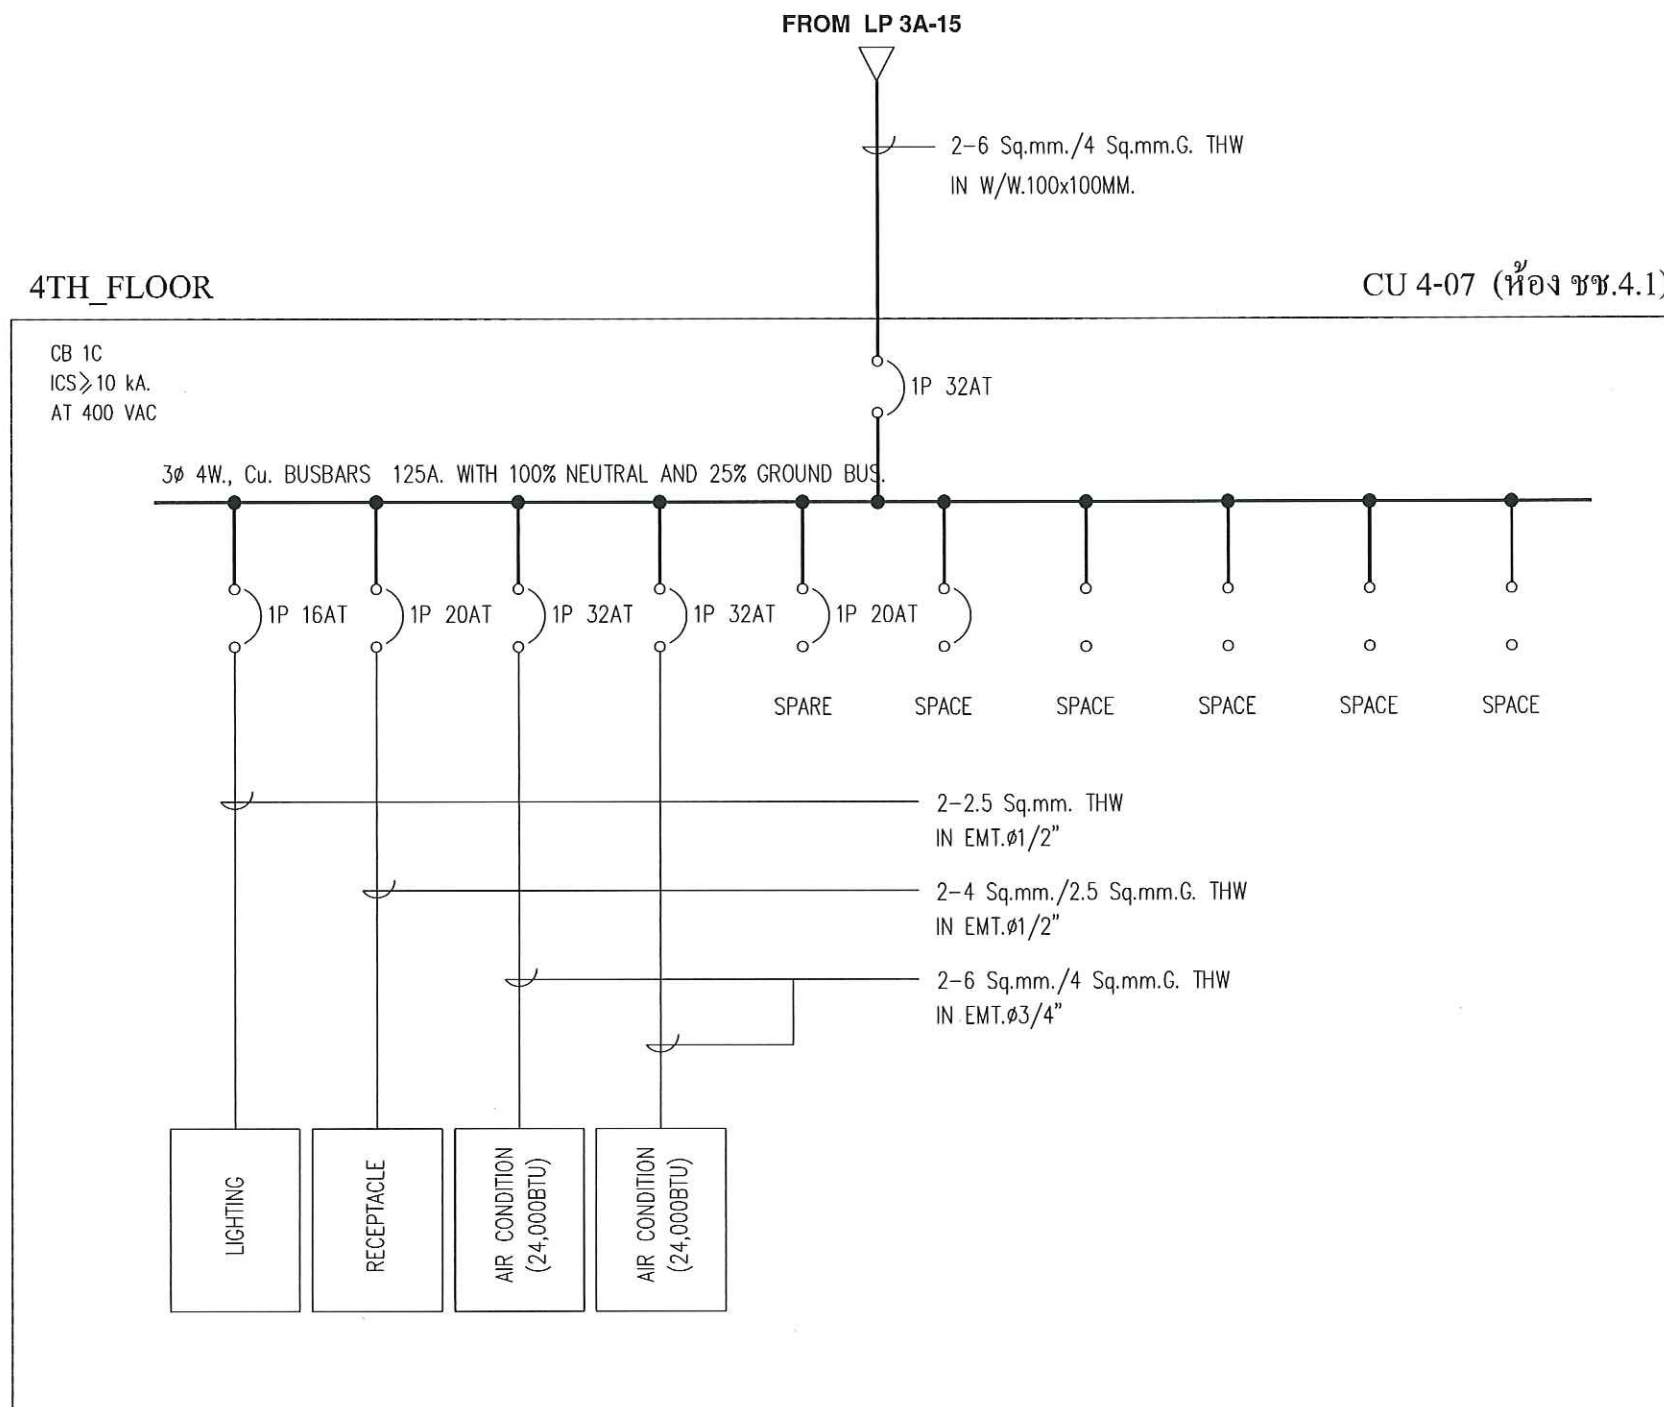

OWNER :

CONSULTANT :



King Mongkut's Institute  
of Technology Ladkrabong  
Chalongkrung Road, Ladkrabong, Bangkok 10520  
TEL. ( +66 ) 2-329-8000 , FAX. ( +66 ) 2-329-8204

CONTRACTOR :

PRELIMINARY

KEY PLAN

ENGINEER CERTIFICATION

|              |                       |
|--------------|-----------------------|
| SIGNATURE    |                       |
| NAME         | SONGKRIT TRERATPICHAN |
| REGISTER No. | วทป 957               |

| REVISION |          |    |             |
|----------|----------|----|-------------|
| No.      | DATE     | BY | DESCRIPTION |
|          |          |    |             |
|          |          |    |             |
|          |          |    |             |
|          |          |    |             |
|          |          |    |             |
| 1        | 07/20/18 | -  | PRELIMINARY |

REVISION OF DRAWING : 0

PROJECT NAME :

Excise Department


DRAWING TITLE :

CU 4-07\_SINGLE LINE DIAGRAM

DRAWING No. :

EXD-20180720

|               |         |           |
|---------------|---------|-----------|
| SHEET : 7     | OF : 13 | SIZE : A3 |
| DATE :        | SCALE : | NTS       |
| DRAW BY :     |         |           |
| CHECKED BY :  |         |           |
| APPROVED BY : |         |           |

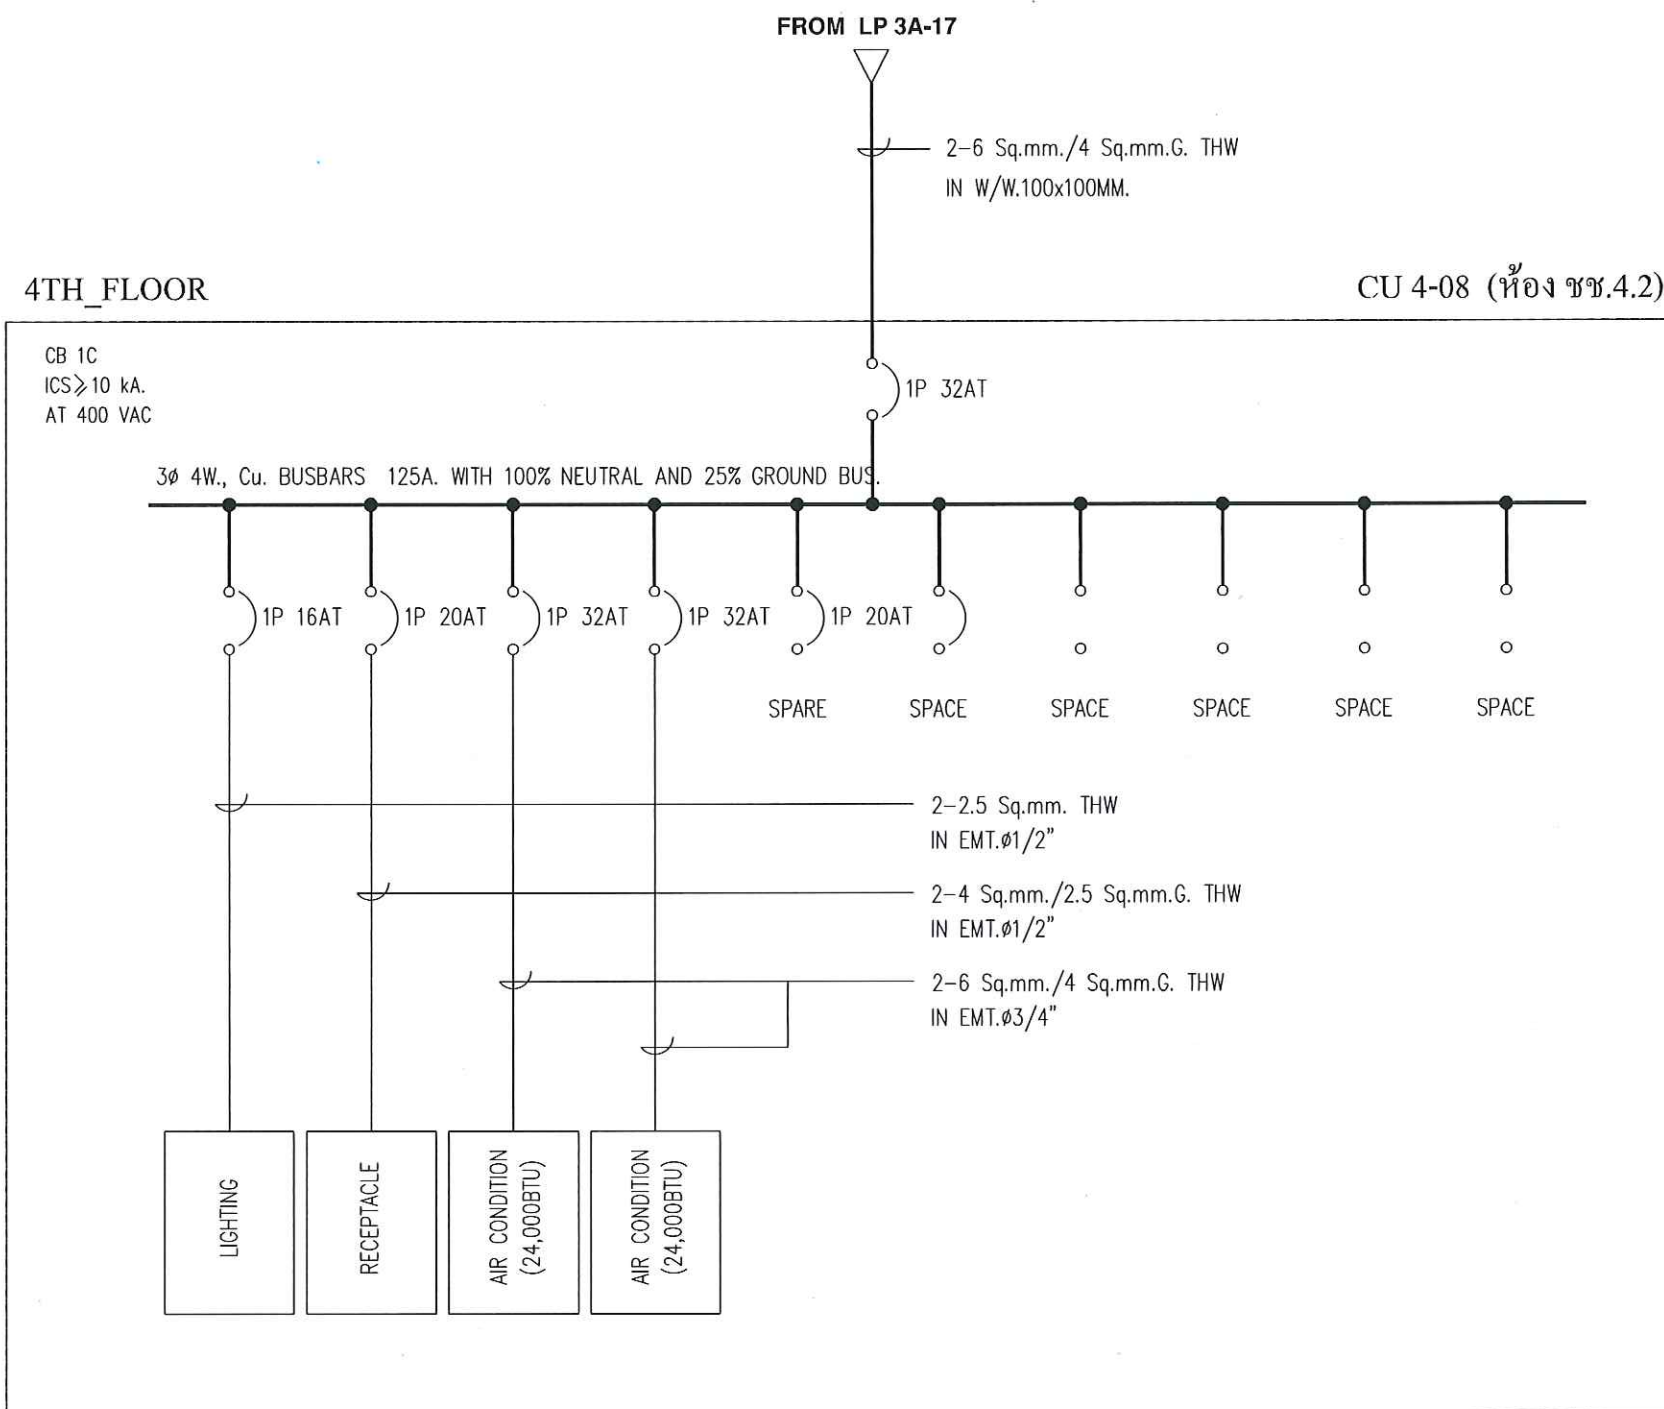

OWNER :

CONSULTANT :



King Mongkut's Institute  
of Technology Ladkrabang  
Chalongkrung Road, Ladkrabang, Bangkok 10520  
TEL ( +66 ) 2-329-8000 , FAX ( +66 ) 2-329-8204

CONTRACTOR :

PRELIMINARY

KEY PLAN

ENGINEER CERTIFICATION

|              |                       |
|--------------|-----------------------|
| SIGNATURE    |                       |
| NAME         | SONGKRIT TRERATPICHAN |
| REGISTER No. | วทป 957               |

| REVISION |          |    |             |
|----------|----------|----|-------------|
| No.      | DATE     | BY | DESCRIPTION |
| 1        | 07/20/18 | -  | PRELIMINARY |

REVISION OF DRAWING : 0

PROJECT NAME :

Excise Department

DRAWING TITLE :


CU 4-08\_SINGLE LINE DIAGRAM

DRAWING No. :

EXD-20180720

|               |         |           |
|---------------|---------|-----------|
| SHEET : 8     | OF : 13 | SIZE : A3 |
| DATE :        | SCALE : | NTS       |
| DRAW BY :     |         |           |
| CHECKED BY :  |         |           |
| APPROVED BY : |         |           |



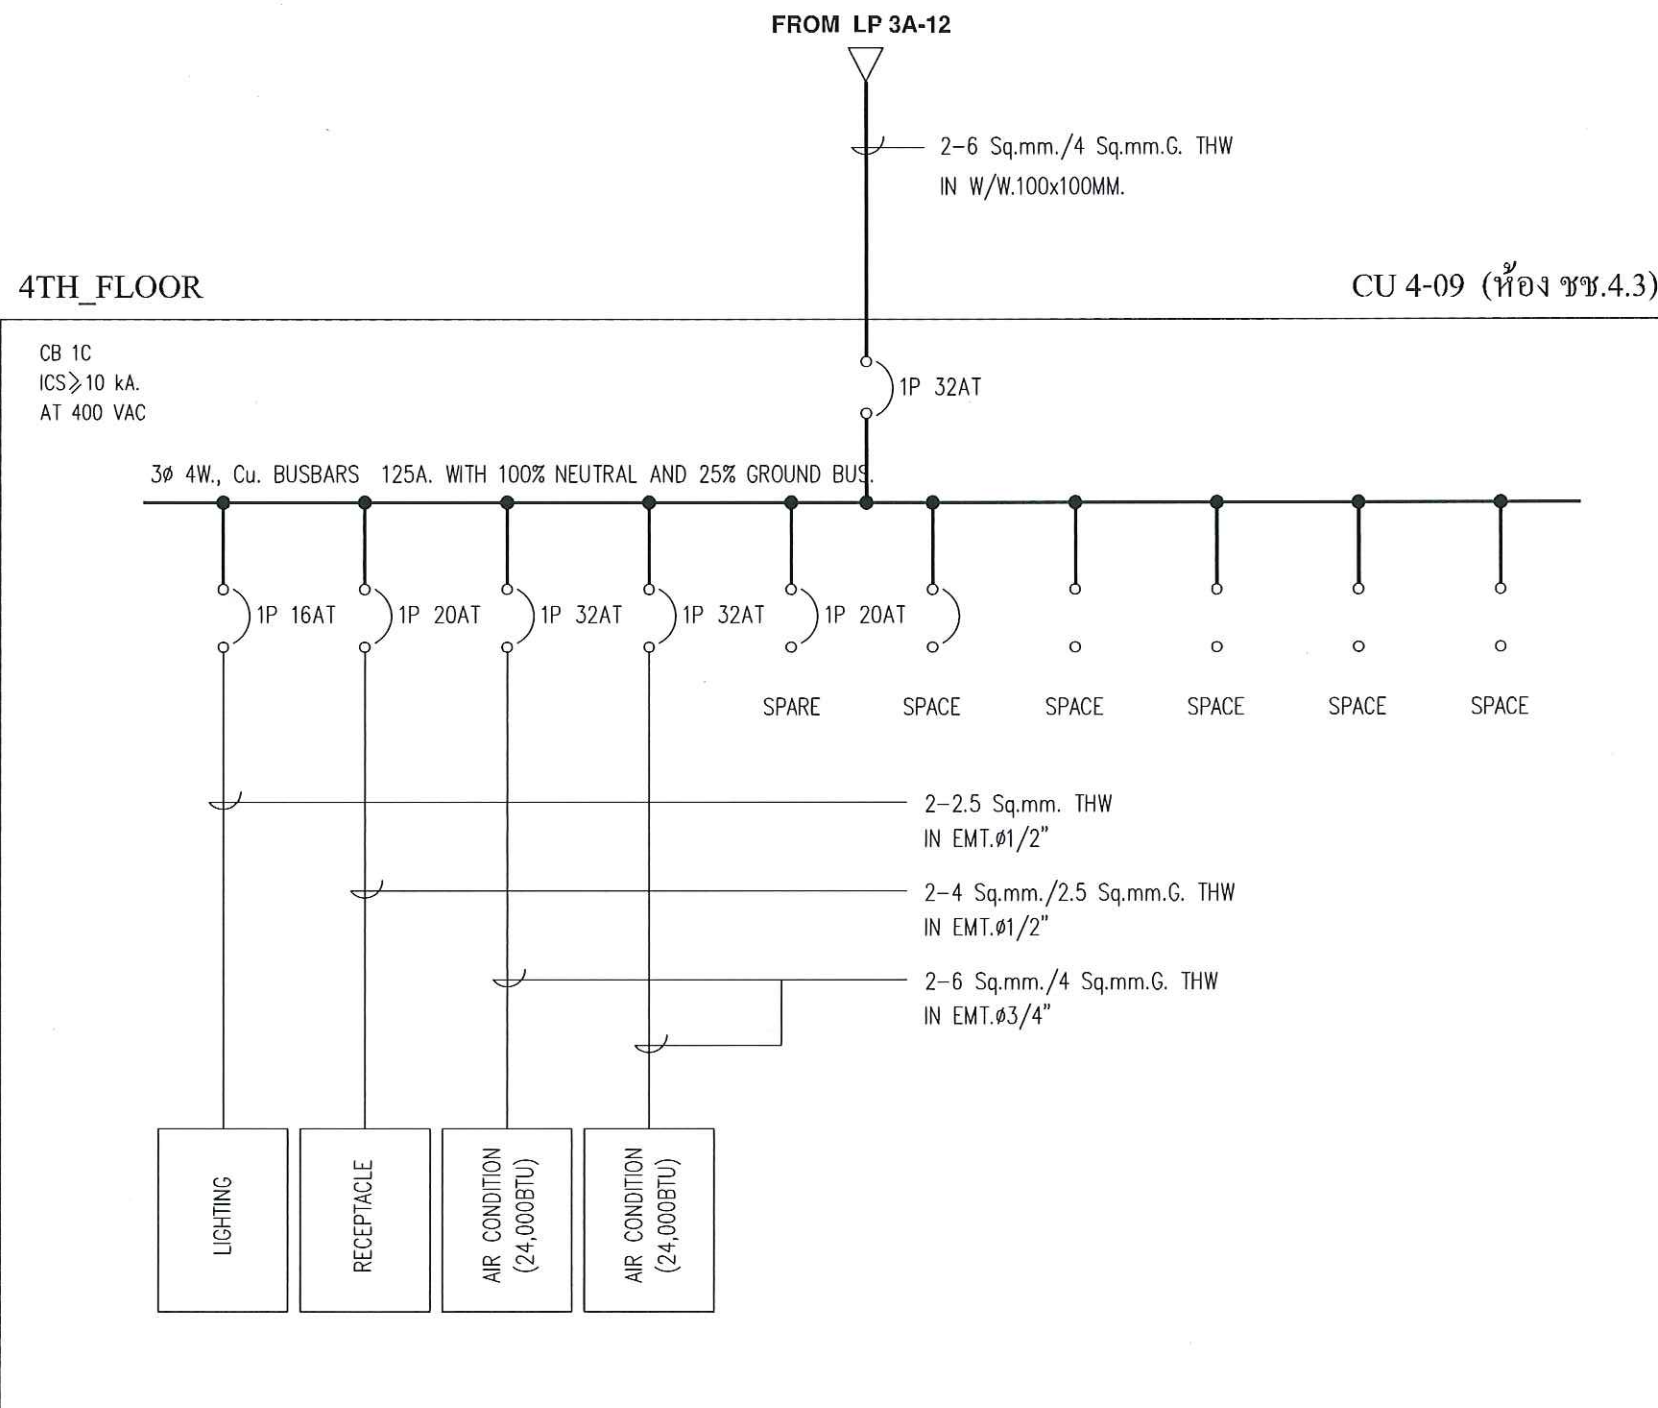

OWNER :

CONSULTANT :



King Mongkut's Institute  
of Technology Ladkrabang  
Chalongkrung Road, Ladkrabang, Bangkok 10520  
TEL. ( +66 ) 2-329-8000 , FAX. ( +66 ) 2-329-8204

CONTRACTOR :

PRELIMINARY

KEY PLAN

ENGINEER CERTIFICATION

|              |                       |
|--------------|-----------------------|
| SIGNATURE    |                       |
| NAME         | SONGKRIT TRERATPICHAN |
| REGISTER No. | วทศ 957               |

| REVISION |          |    |             |
|----------|----------|----|-------------|
| No.      | DATE     | BY | DESCRIPTION |
|          |          |    |             |
|          |          |    |             |
|          |          |    |             |
|          |          |    |             |
|          |          |    |             |
| 1        | 07/20/18 | -  | PRELIMINARY |

REVISION OF DRAWING : 0

PROJECT NAME :

Excise Department


DRAWING TITLE :

CU 4-09\_SINGLE LINE DIAGRAM

DRAWING No. :

EXD-20180720

|               |         |           |
|---------------|---------|-----------|
| SHEET : 9     | OF : 13 | SIZE : A3 |
| DATE :        | SCALE : | NTS       |
| DRAW BY :     |         |           |
| CHECKED BY :  |         |           |
| APPROVED BY : |         |           |

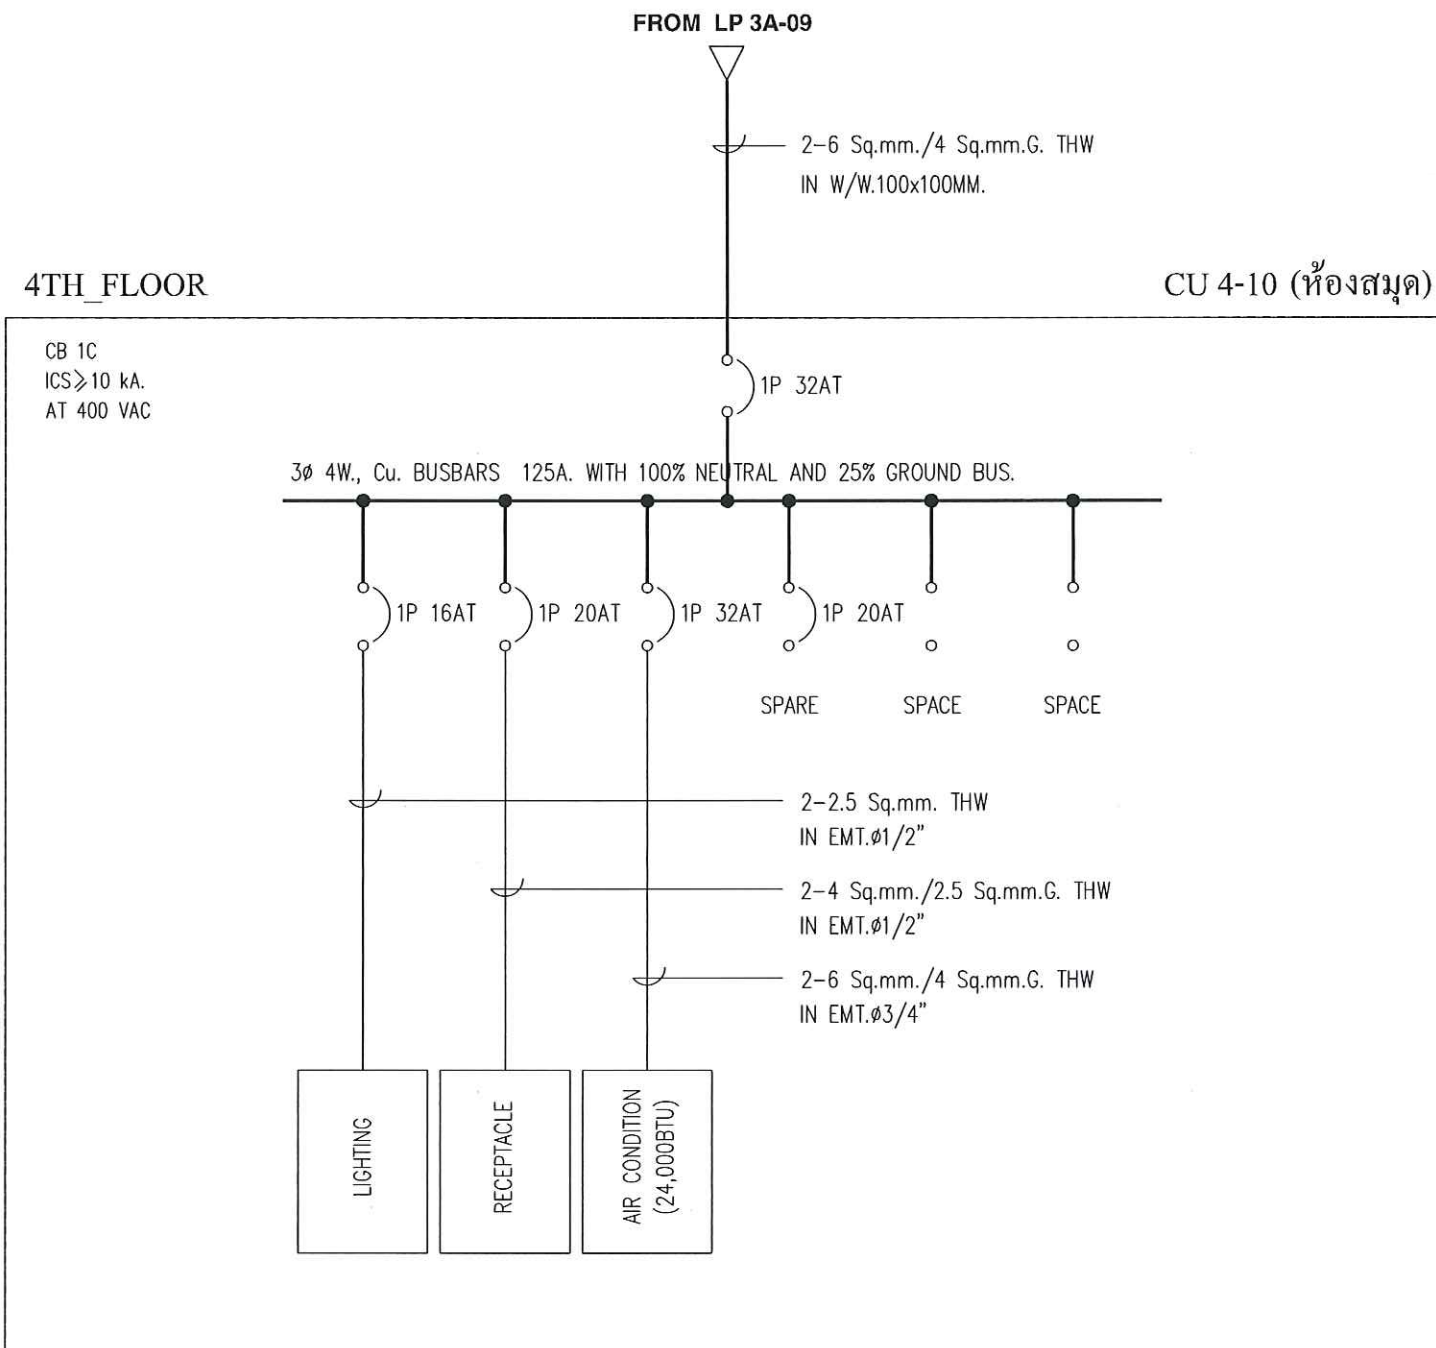

OWNER :

CONSULTANT :



King Mongkut's Institute  
of Technology Ladkrabang  
Chalongkrung Road, Ladkrabang, Bangkok 10520  
TEL ( +66 ) 2-329-8000 , FAX ( +66 ) 2-329-8204

CONTRACTOR :

PRELIMINARY

KEY PLAN

ENGINEER CERTIFICATION

SIGNATURE

NAME SONGKRIT TERATPICHAN

REGISTER No. ๖๗๙ ๙๕๗

| REVISION |          |    |             |
|----------|----------|----|-------------|
| No.      | DATE     | BY | DESCRIPTION |
|          |          |    |             |
|          |          |    |             |
|          |          |    |             |
|          |          |    |             |
|          |          |    |             |
| 1        | 07/20/18 | -  | PRELIMINARY |

REVISION OF DRAWING : 0

PROJECT NAME :

Excise Department

DRAWING TITLE :

CU 4-10\_SINGLE LINE DIAGRAM

DRAWING No. :

EXD-20180720


SHEET : 10 OF : 13 SIZE : A3

DATE : SCALE : NTS

DRAW BY :

CHECKED BY :

APPROVED BY :

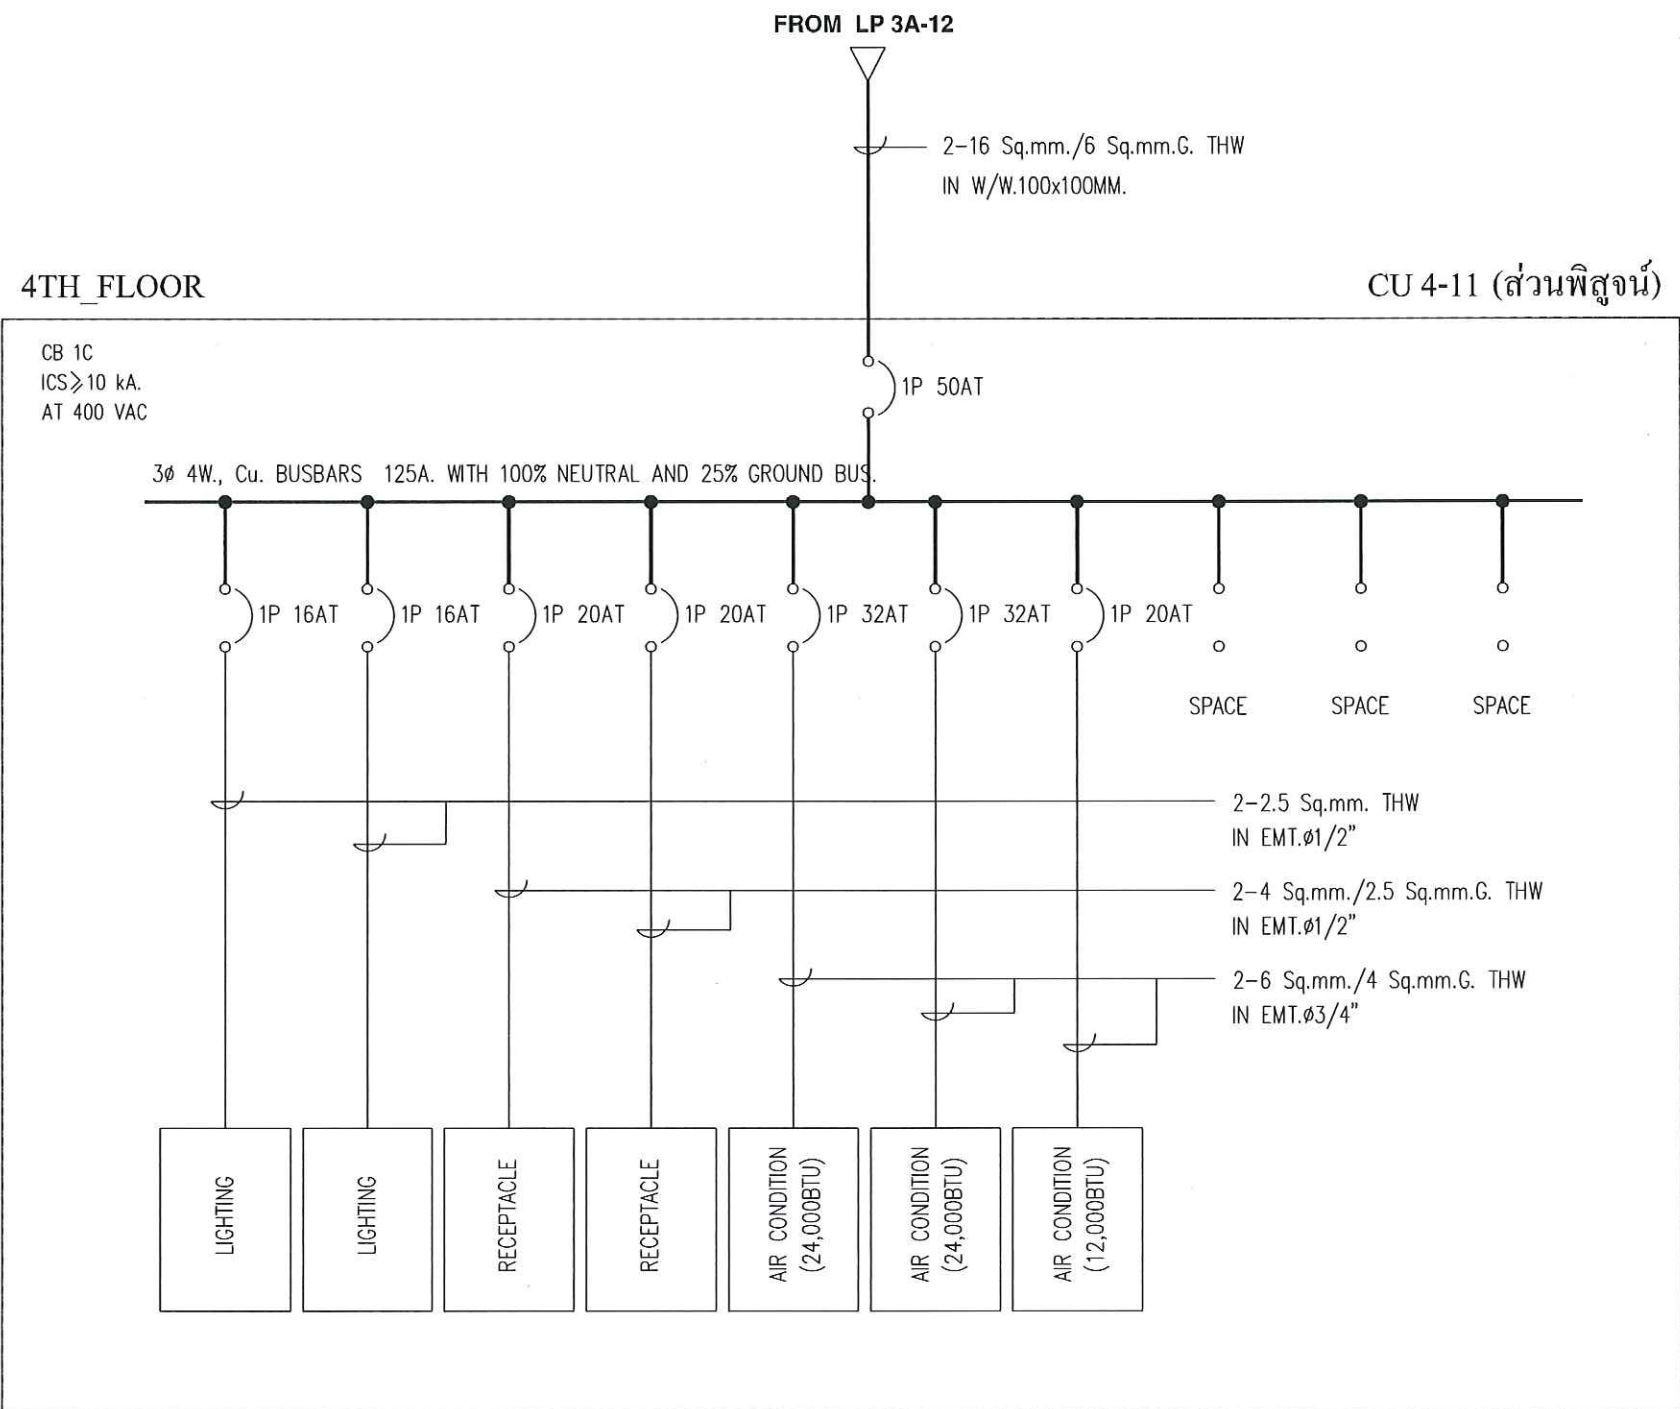

OWNER :

CONSULTANT :



King Mongkut's Institute  
of Technology Ladkrabang  
Chalongkrung Road, Ladkrabang, Bangkok 10520  
TEL. ( +66 ) 2-329-8000 , FAX. ( +66 ) 2-329-8204

CONTRACTOR :

PRELIMINARY

KEY PLAN

ENGINEER CERTIFICATION

|              |                       |
|--------------|-----------------------|
| SIGNATURE    |                       |
| NAME         | SONGKRIT TRERATPICHAN |
| REGISTER No. | วพท 957               |

REVISION

| No. | DATE     | BY | DESCRIPTION |
|-----|----------|----|-------------|
| 1   | 07/20/18 | -  | PRELIMINARY |

REVISION OF DRAWING : 0

PROJECT NAME :

Excise Department


DRAWING TITLE :

CU 4-11\_SINGLE LINE DIAGRAM

DRAWING No. :

EXD-20180720

|               |         |           |
|---------------|---------|-----------|
| SHEET : 11    | OF : 13 | SIZE : A3 |
| DATE :        | SCALE : | NTS       |
| DRAW BY :     |         |           |
| CHECKED BY :  |         |           |
| APPROVED BY : |         |           |

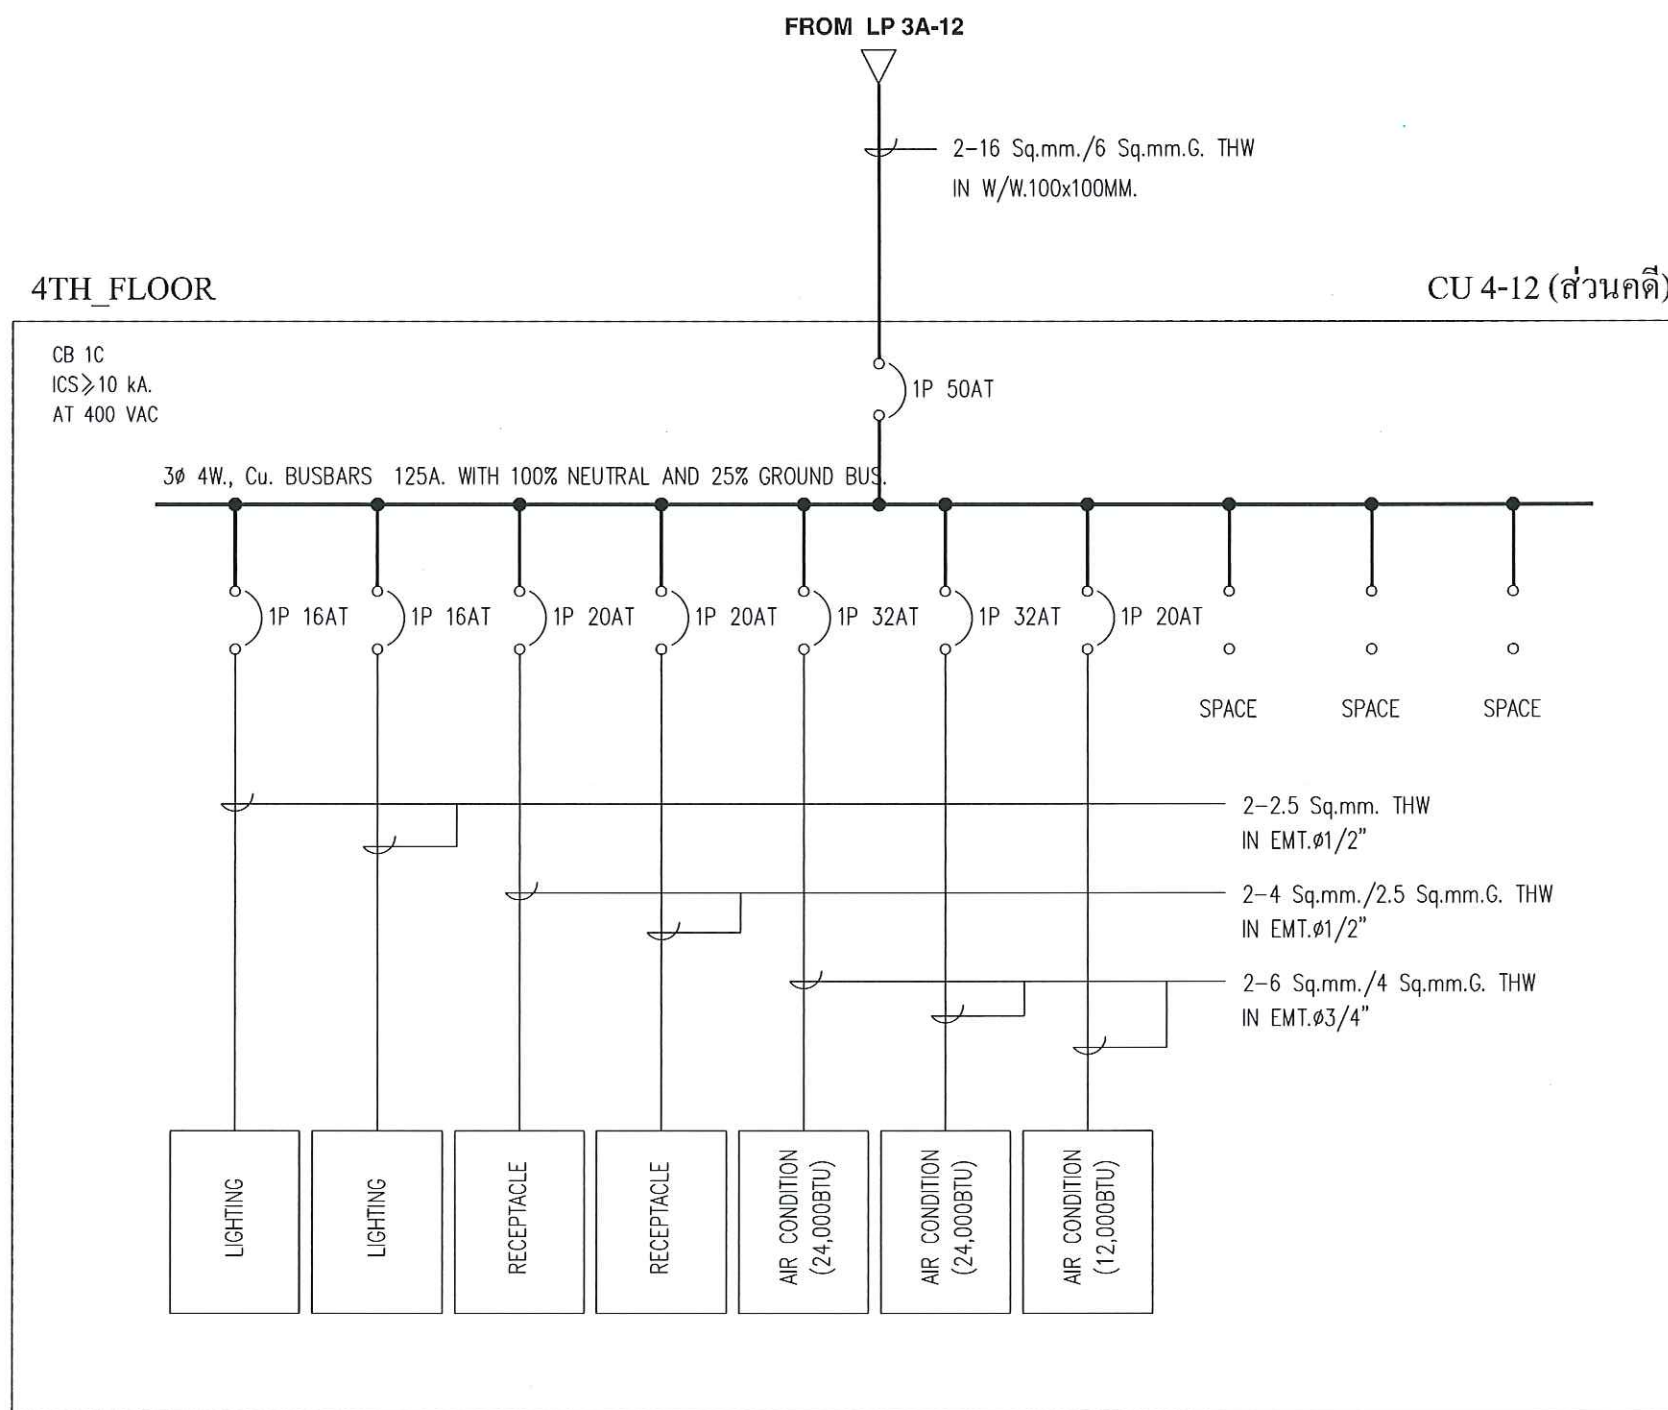

OWNER :

CONSULTANT :



King Mongkut's Institute  
of Technology Ladkrabang  
Chalongkrung Road, Ladkrabang, Bangkok 10520  
TEL ( +66 ) 2-329-8000 , FAX ( +66 ) 2-329-8204

CONTRACTOR :

PRELIMINARY

KEY PLAN

ENGINEER CERTIFICATION

|              |                       |
|--------------|-----------------------|
| SIGNATURE    |                       |
| NAME         | SONGKRIT TRERATPICHAN |
| REGISTER No. | วทล 957               |

| REVISION |          |    |             |
|----------|----------|----|-------------|
| No.      | DATE     | BY | DESCRIPTION |
|          |          |    |             |
|          |          |    |             |
|          |          |    |             |
|          |          |    |             |
|          |          |    |             |
| 1        | 07/20/18 | -  | PRELIMINARY |

REVISION OF DRAWING : 0

PROJECT NAME :

Excise Department

DRAWING TITLE :


CU 4-12\_SINGLE LINE DIAGRAM

DRAWING No. :

EXD-20180720

|               |         |           |
|---------------|---------|-----------|
| SHEET : 12    | OF : 13 | SIZE : A3 |
| DATE :        | SCALE : | NTS       |
| DRAW BY :     |         |           |
| CHECKED BY :  |         |           |
| APPROVED BY : |         |           |



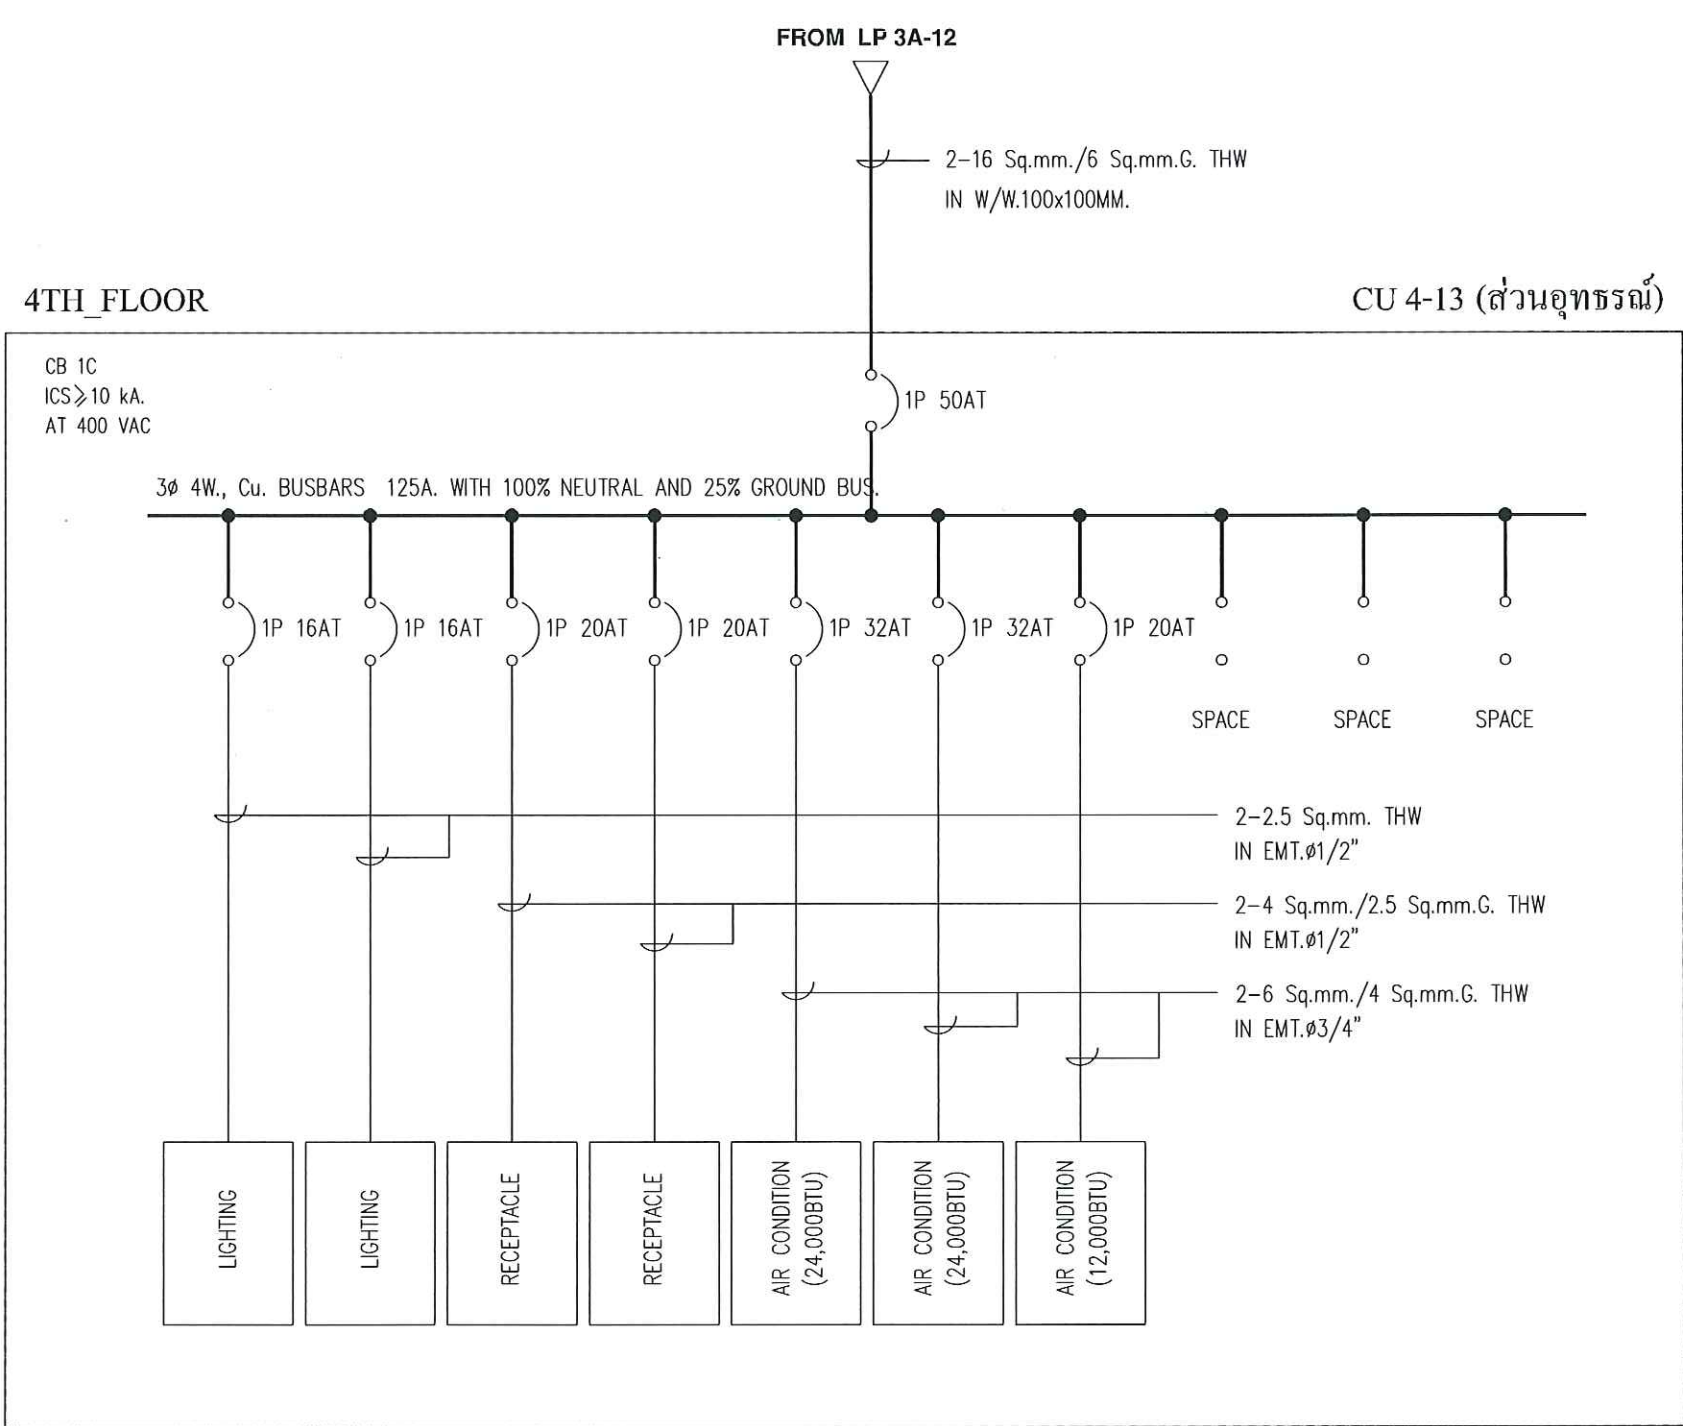

OWNER :

CONSULTANT :

 
King Mongkut's Institute of Technology Ladkrabang  
Chalongkrung Road, Ladkrabang, Bangkok 10520  
TEL. ( +66 ) 2-329-8000 , FAX. ( +66 ) 2-329-8204

CONTRACTOR :

PRELIMINARY

KEY PLAN

ENGINEER CERTIFICATION

|              |                                                                                       |
|--------------|---------------------------------------------------------------------------------------|
| SIGNATURE    |  |
| NAME         | SONGKRIT TRERATPICHAN                                                                 |
| REGISTER No. | วพค 957                                                                               |

REVISION

| No. | DATE     | BY | DESCRIPTION |
|-----|----------|----|-------------|
| 1   | 07/20/18 | -  | PRELIMINARY |


REVISION OF DRAWING : 0

PROJECT NAME :  
Excise Department


DRAWING TITLE :  
CU 4-12\_SINGLE LINE DIAGRAM

DRAWING No. :  
EXD-20180720

|               |         |           |
|---------------|---------|-----------|
| SHEET : 12    | OF : 13 | SIZE : A3 |
| DATE :        | SCALE : | NTS       |
| DRAW BY :     |         |           |
| CHECKED BY :  |         |           |
| APPROVED BY : |         |           |

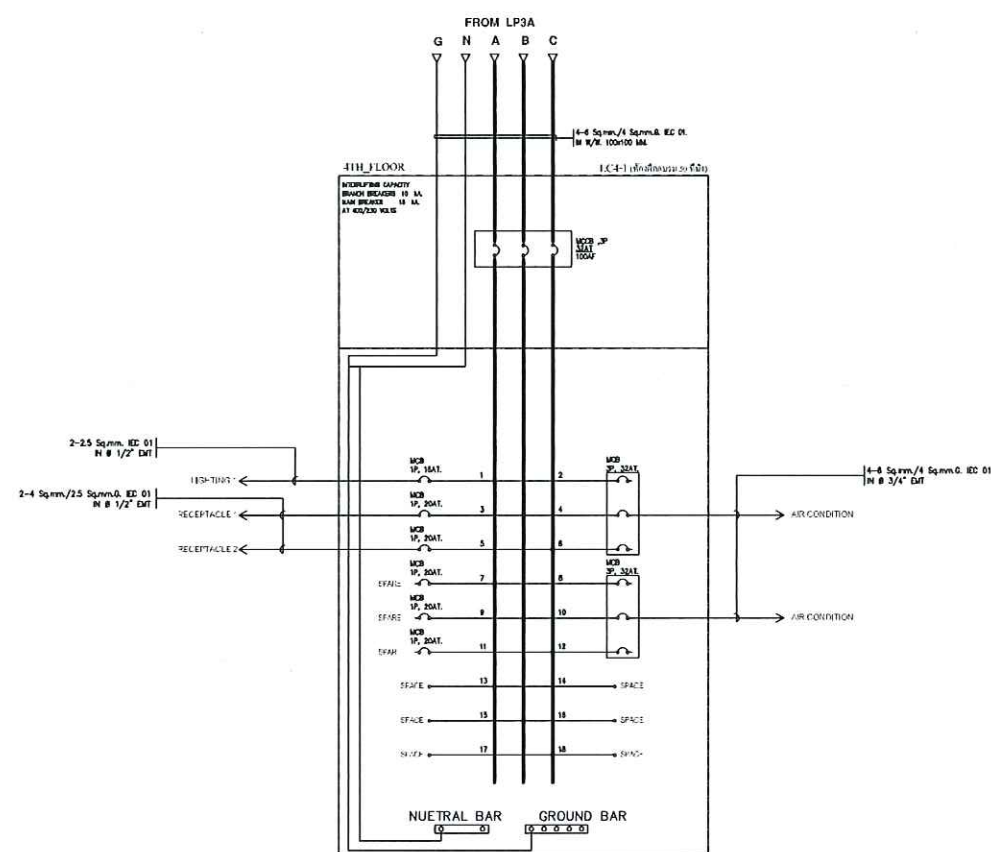

SINGLE LINE DIAGRAM PANEL LC 4-1

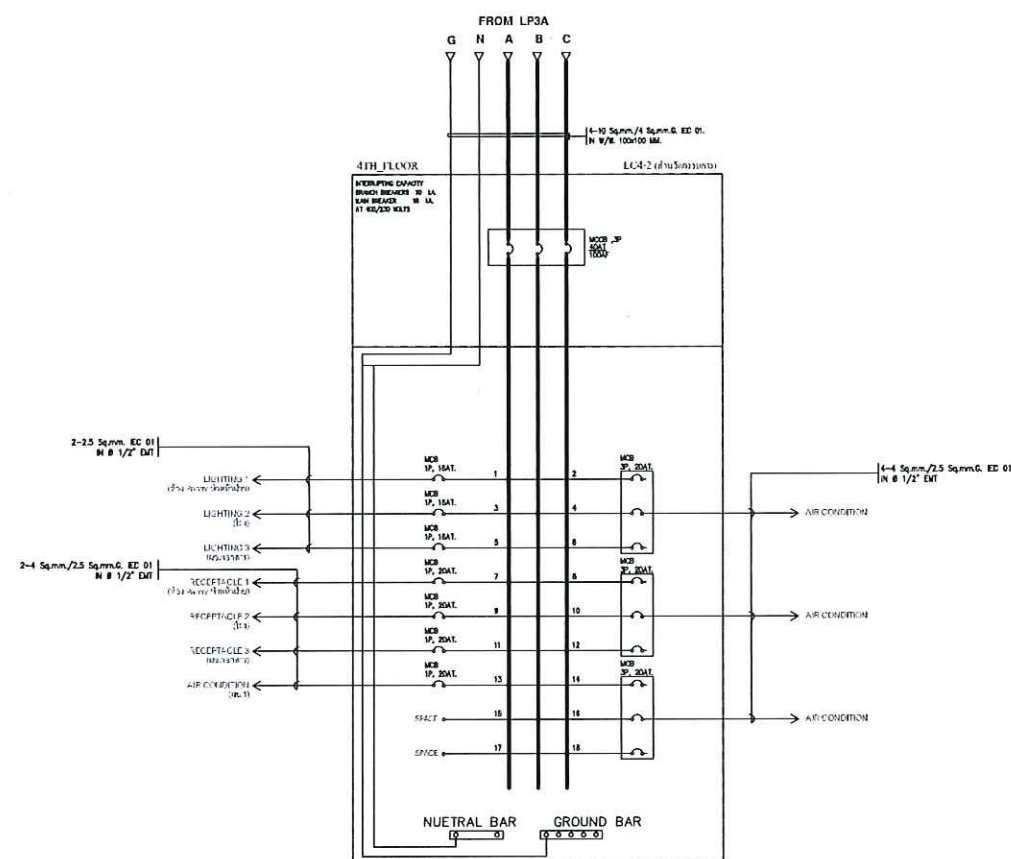

SINGLE LINE DIAGRAM PANEL LC 4-2

OWNER :

CONSULTANT :



King Mongkut's Institute  
of Technology Ladkrabang  
Chalongkrung Road, Ladkrabang, Bangkok 10520  
TEL ( +66 ) 2-329-8000 , FAX ( +66 ) 2-329-8204

CONTRACTOR :

PRELIMINARY

KEY PLAN

ENGINEER CERTIFICATION

SIGNATURE

NAME

SONGKRIT THIRATPICHAN

REGISTER No.

จก 957

REVISION

| No. | DATE     | BY | DESCRIPTION |
|-----|----------|----|-------------|
| 1   | 07/20/18 | -  | PRELIMINARY |

REVISION OF DRAWING : 0

PROJECT NAME :

Excise Department

DRAWING TITLE :

DIAGRAM LC 4-1 &amp; LC 4-2

DRAWING No. :

EXD-20180720

SHEET : 1 OF : 6 SIZE : A3

DATE :


SCALE :

NTS


DRAW BY :

CHECKED BY :

APPROVED BY :

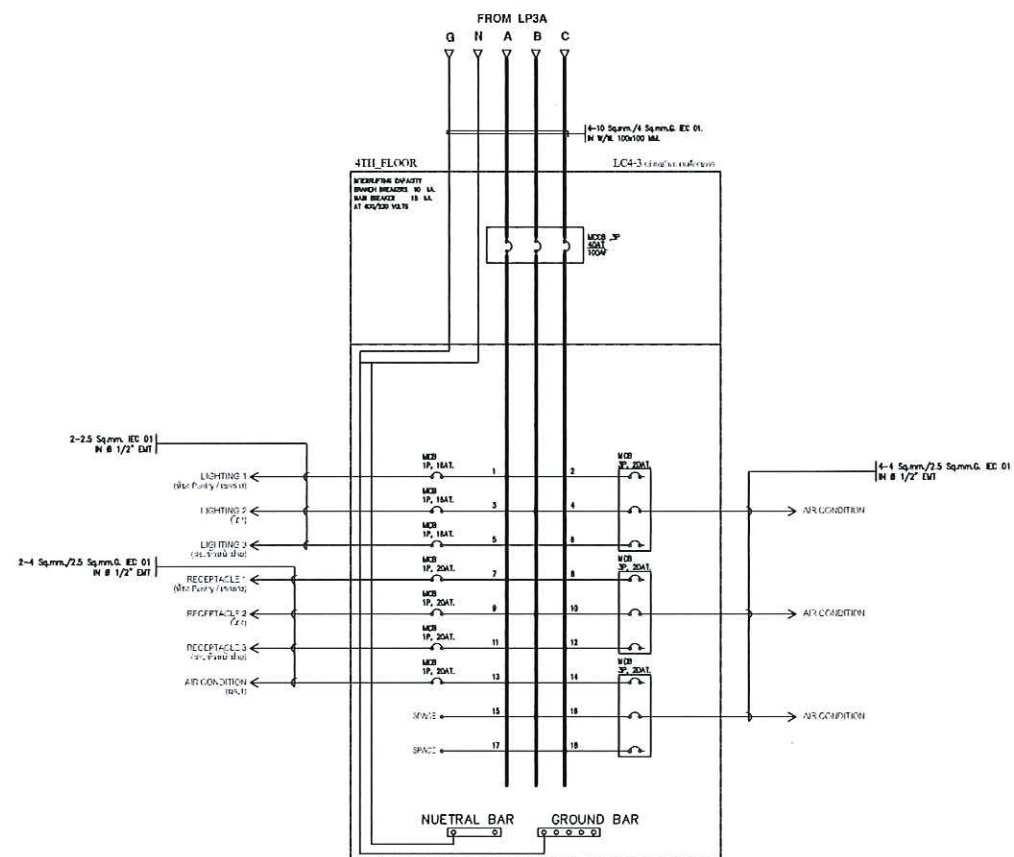

SINGLE LINE DIAGRAM PANEL LC 4-3

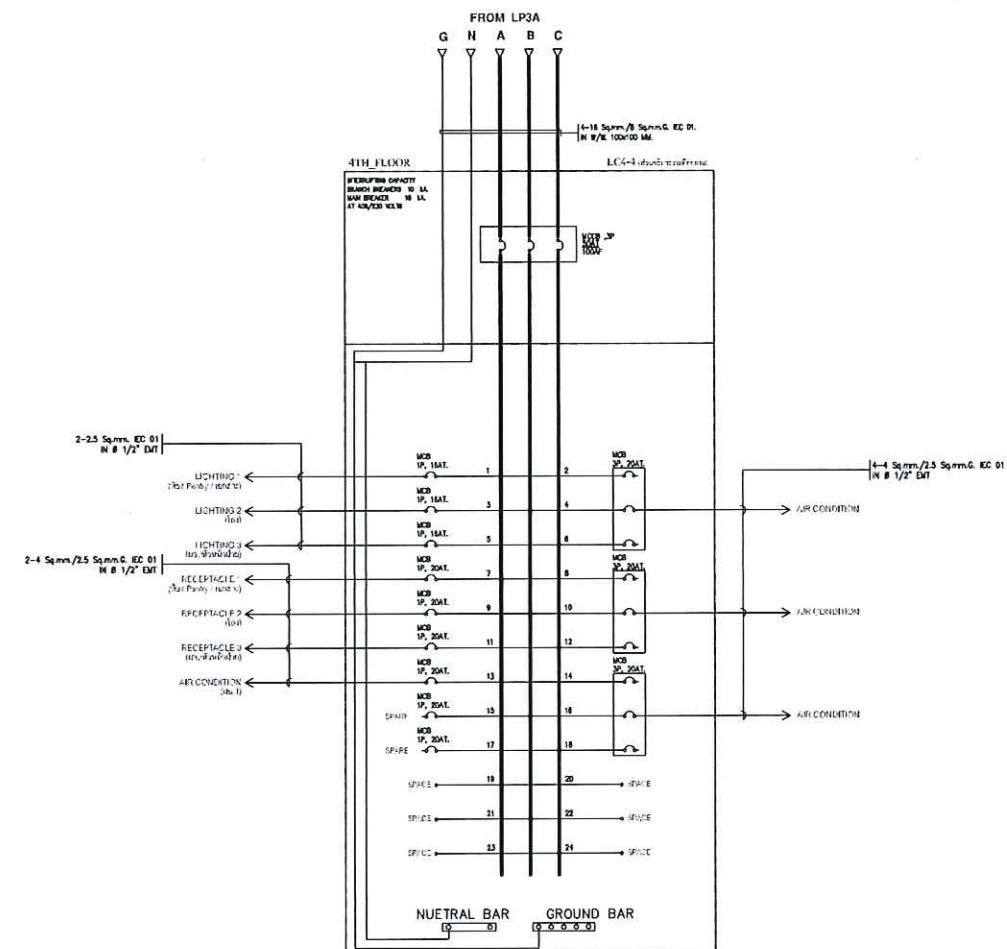

SINGLE LINE DIAGRAM PANEL LC 4-4

OWNER :

CONSULTANT :



King Mongkut's Institute  
of Technology Ladkrabang  
Chalongkrung Road, Ladkrabang, Bangkok 10520  
TEL. ( +66 ) 2-329-8000 , FAX ( +66 ) 2-329-8204

CONTRACTOR :

PRELIMINARY

KEY PLAN

ENGINEER CERTIFICATION

SIGNATURE   
NAME SONGKRIT TRERATPICHAN  
REGISTER No. ๓๗๙ ๙๕๗

REVISION

| No. | DATE     | BY | DESCRIPTION |
|-----|----------|----|-------------|
| 1   | 07/20/18 | -  | PRELIMINARY |

REVISION OF DRAWING : 0

PROJECT NAME :

Excise Department

DRAWING TITLE :

DIAGRAM LC 4-3 & LC 4-4

DRAWING No. :

EXD-20180720

SHEET : 2 OF : 6 SIZE : A3


DATE : SCALE : NTS

DRAW BY :


CHECKED BY :

APPROVED BY :



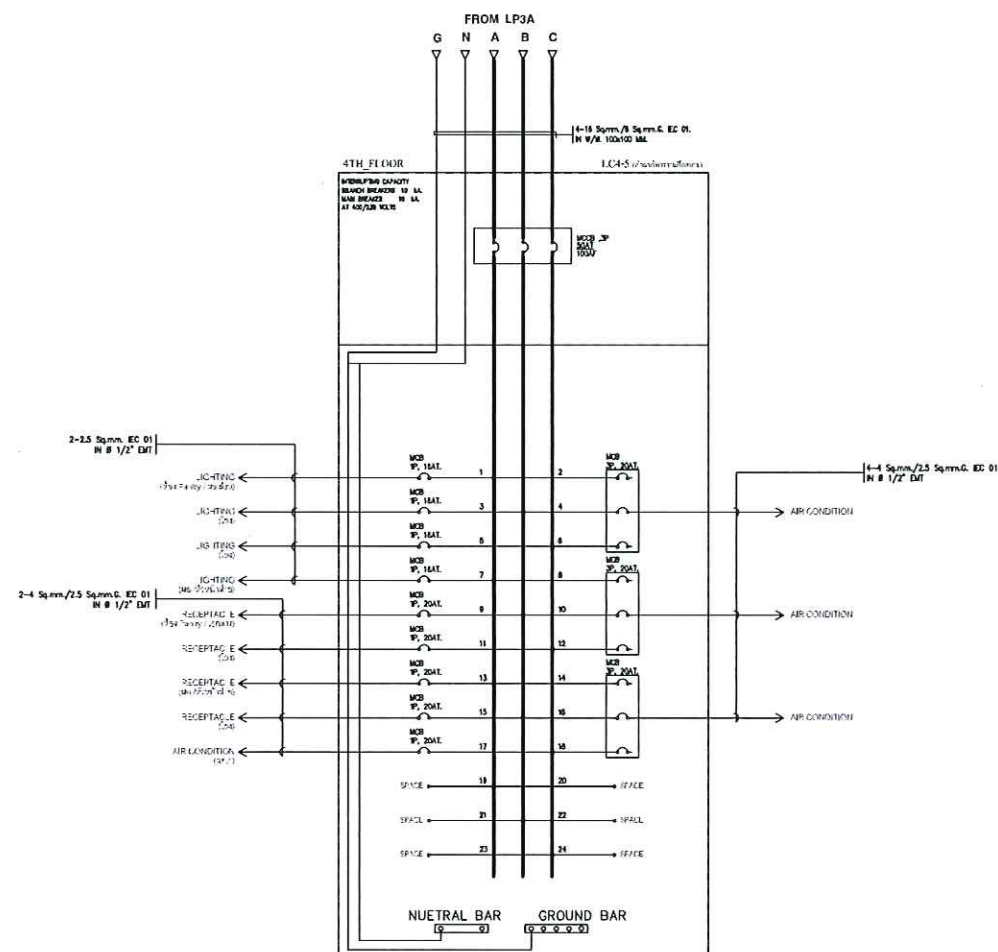

SINGLE LINE DIAGRAM PANEL LC 4-5

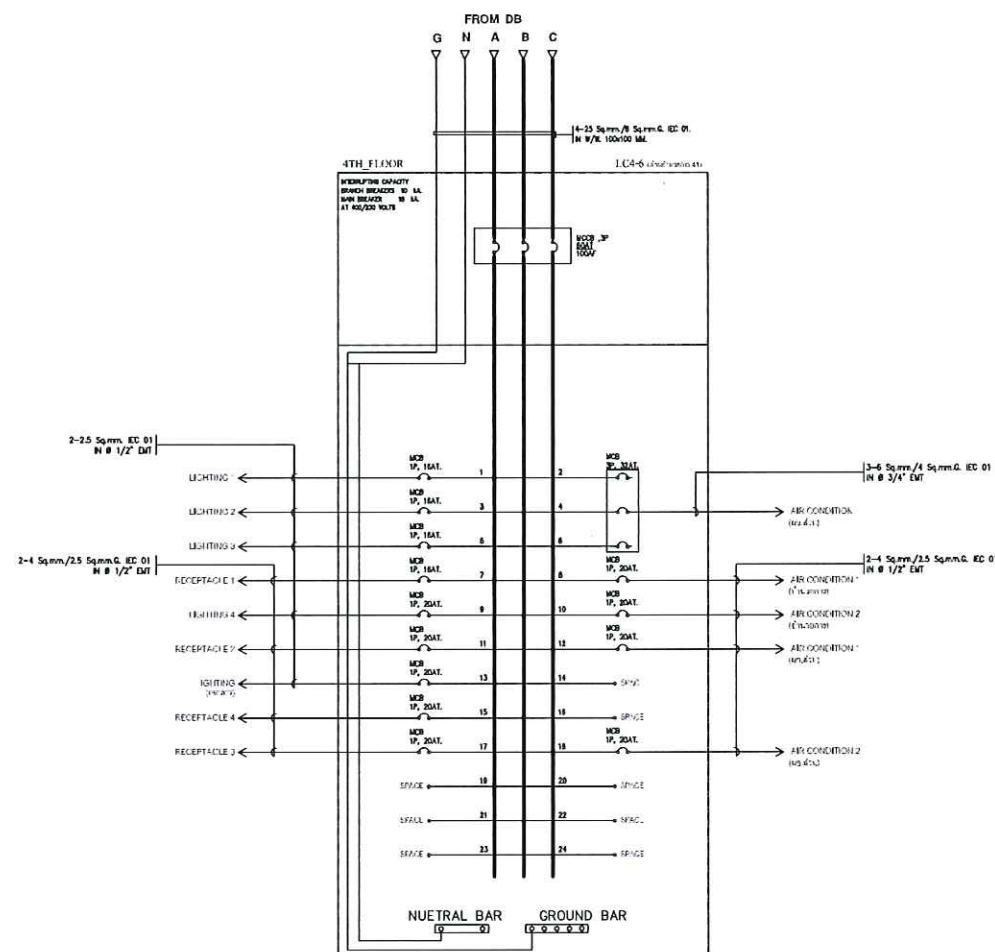

SINGLE LINE DIAGRAM PANEL LC 4-6

OWNER :

CONSULTANT :



King Mongkut's Institute  
of Technology Ladkrabang  
Chalongkrung Road, Ladkrabang, Bangkok 10520  
TEL. ( +68 ) 2-329-8000 , FAX. ( +68 ) 2-329-8204

CONTRACTOR :

PRELIMINARY

KEY PLAN

ENGINEER CERTIFICATION

SIGNATURE   
NAME SONGKRIT TRERATPICHAN  
REGISTER No. ๖๗ ๙๕๗

| REVISION |          |    |             |
|----------|----------|----|-------------|
| No.      | DATE     | BY | DESCRIPTION |
| 1        | 07/20/18 | -  | PRELIMINARY |

REVISION OF DRAWING : 0

PROJECT NAME :

Excise Department

DRAWING TITLE :

DIAGRAM LC 4-5 & LC 4-6


DRAWING No. :

EXD-20180720


|           |              |               |
|-----------|--------------|---------------|
| SHEET : 3 | OF : 6       | SIZE : A3     |
| DATE :    | SCALE :      | NTS           |
| DRAW BY : | CHECKED BY : | APPROVED BY : |





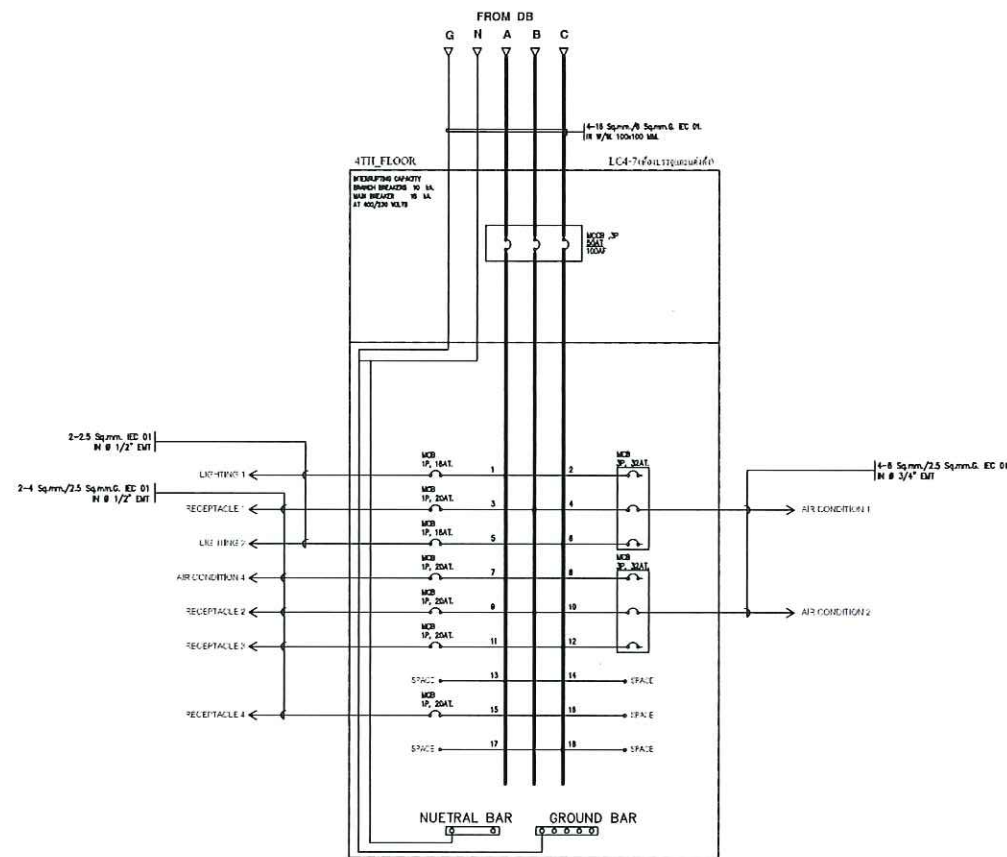

**SINGLE LINE DIAGRAM PANEL LC 4-7**

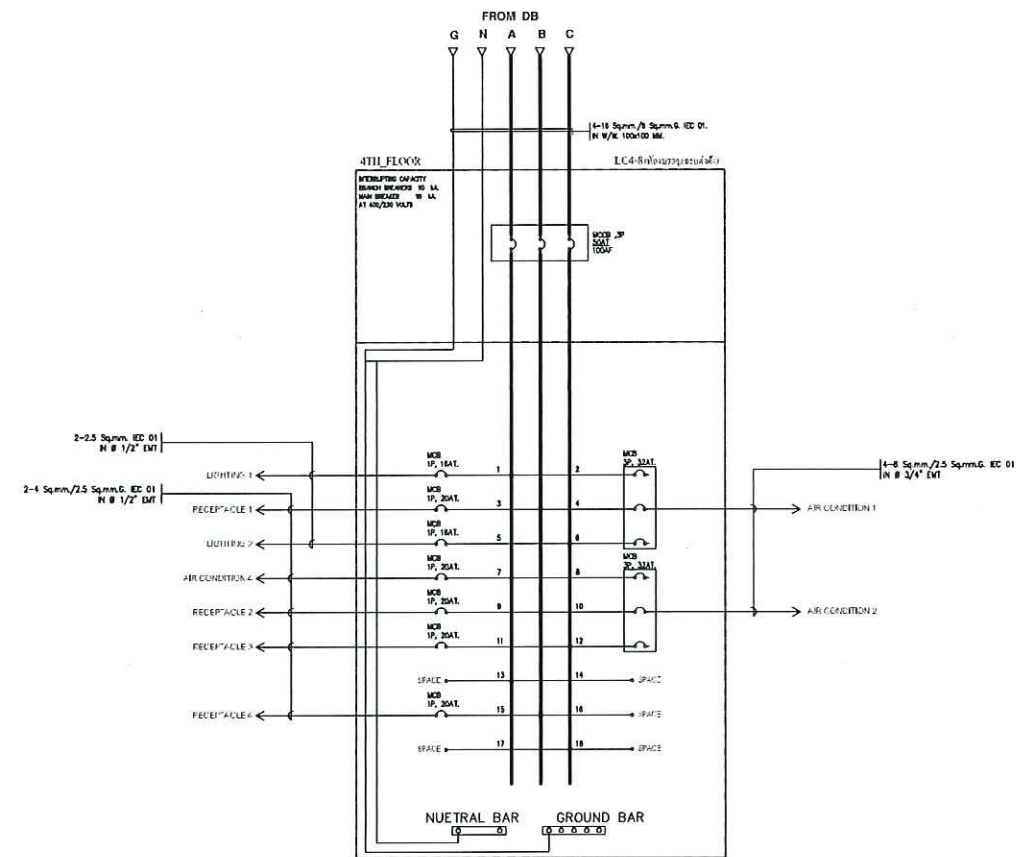

**SINGLE LINE DIAGRAM PANEL LC 4-8**

OWNER :

CONSULTANT :



King Mongkut's Institute  
of Technology Ladkrabang  
Chalongkrung Road, Ladkrabang, Bangkok 10520  
TEL. ( +68 ) 2-329-8000 , FAX. ( +68 ) 2-329-8204

CONTRACTOR :

**PRELIMINARY**

KEY PLAN

ENGINEER CERTIFICATION

|              |                       |
|--------------|-----------------------|
| SIGNATURE    |                       |
| NAME         | SONGKRIT TRERATPICHAN |
| REGISTER No. | ๓๗๙ ๙๕๗               |

REVISION

| No. | DATE     | BY | DESCRIPTION |
|-----|----------|----|-------------|
| 1   | 07/20/18 | -  | PRELIMINARY |

REVISION OF DRAWING : 0

PROJECT NAME :

Excise Department

DRAWING TITLE :

DIAGRAM LC 4-7 & LC 4-8

DRAWING No. :

EXD-20180720

SHEET : 4 OF : 6 SIZE : A3


DATE : SCALE :  
NTS

DRAW BY :

CHECKED BY :

APPROVED BY :

APPROVED BY :

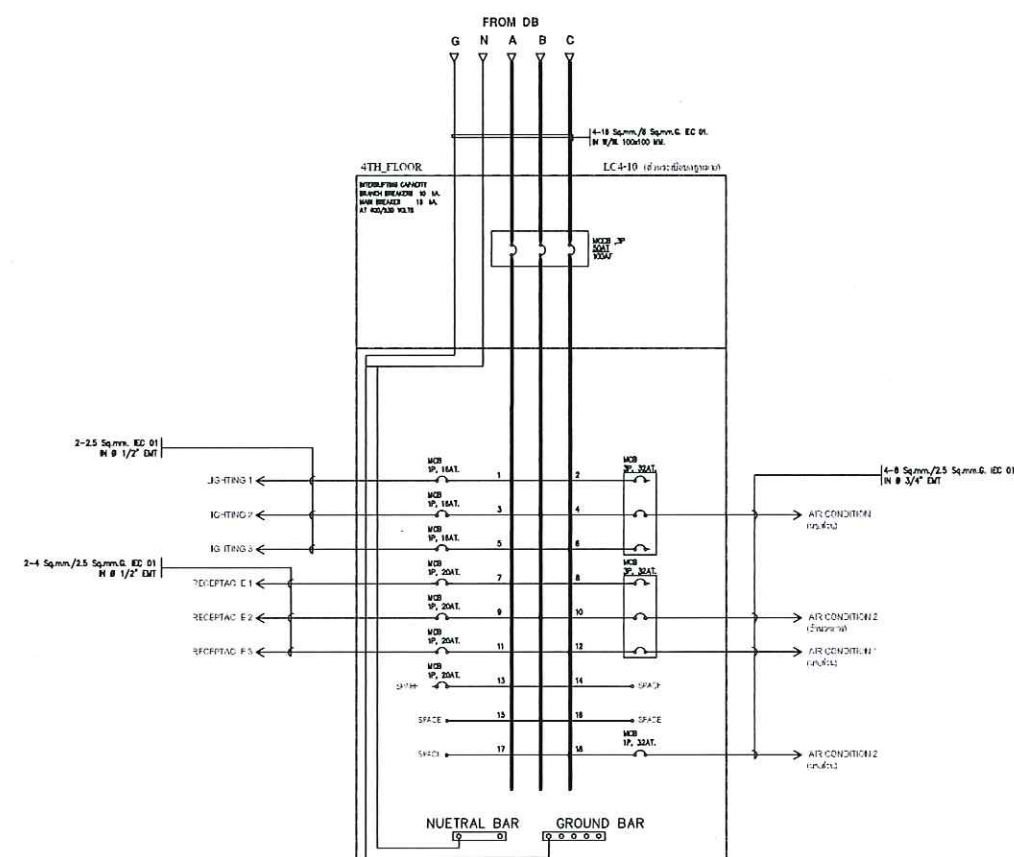

**SINGLE LINE DIAGRAM PANEL LC 4-10**

PAPER SIZE : A3(297x420mm.)

Handwritten signatures and marks.

OWNER :

|              |  |
|--------------|--|
| CONSULTANT : |  |
|--------------|--|



King Mongkut's Institute  
of Technology Ladkrabang  
Chalongkrung Road, Ladkrabang, Bangkok 10520  
TEL. (+68) 2-329-8000, FAX. (+68) 2-329-8204

CONTRACTOR :

PRELIMINARY

## KEY PLAN

## ENGINEER CERTIFICATION

SIGNATURE \_\_\_\_\_

|      |
|------|
| NAME |
|------|

REGISTER No.

957 חלוצי

REVISION

| No. | DATE     | BY | DESCRIPTION |
|-----|----------|----|-------------|
|     |          |    |             |
|     |          |    |             |
|     |          |    |             |
|     |          |    |             |
|     |          |    |             |
| 1   | 07/20/18 | —  | PRELIMINARY |

REVISION OF DRAWING : 0

|                |
|----------------|
| PROJECT NAME : |
|----------------|

Excise Department

DRAWING TITLE :

DIAGRAM LC 4-11 & LC 4-12

DRAWING No. :

EXD-20180720


|           |        |           |
|-----------|--------|-----------|
| SHEET : 6 | OF : 6 | SIZE : A3 |
|-----------|--------|-----------|

|        |         |
|--------|---------|
| DATE : | SCALE : |
|--------|---------|


DRAW BY :

CHECKED BY :

APPROVED BY :

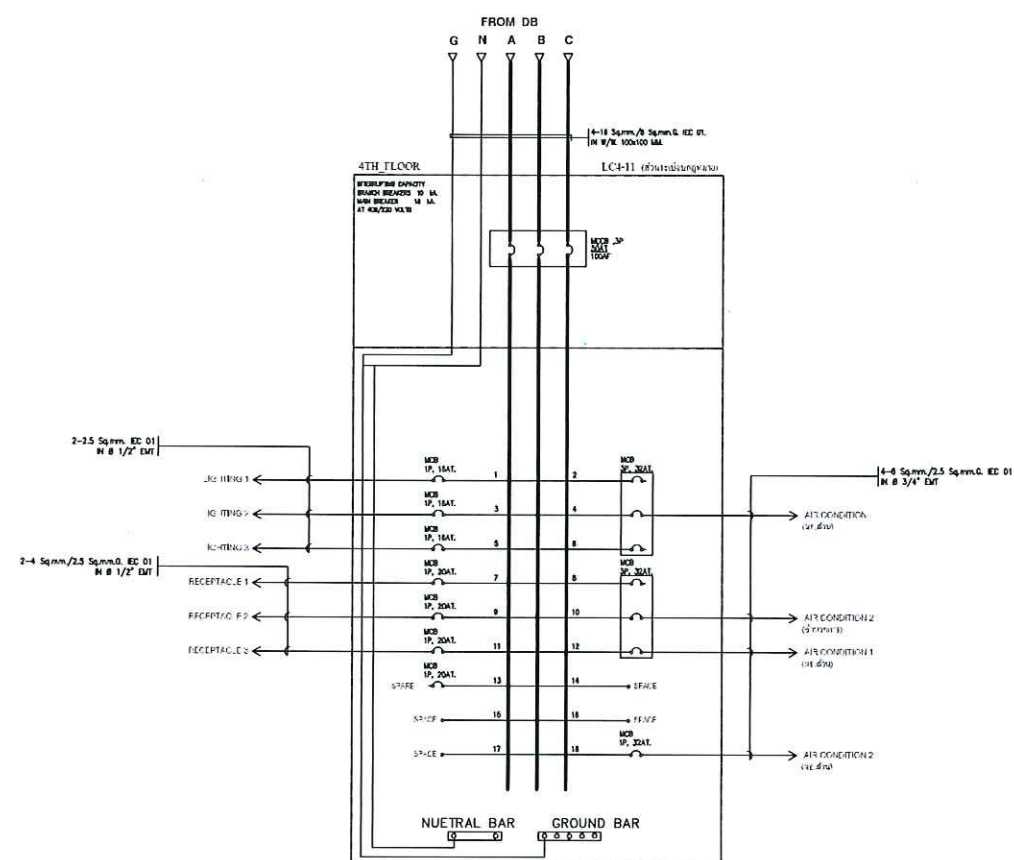

**SINGLE LINE DIAGRAM PANEL LC 4-11**

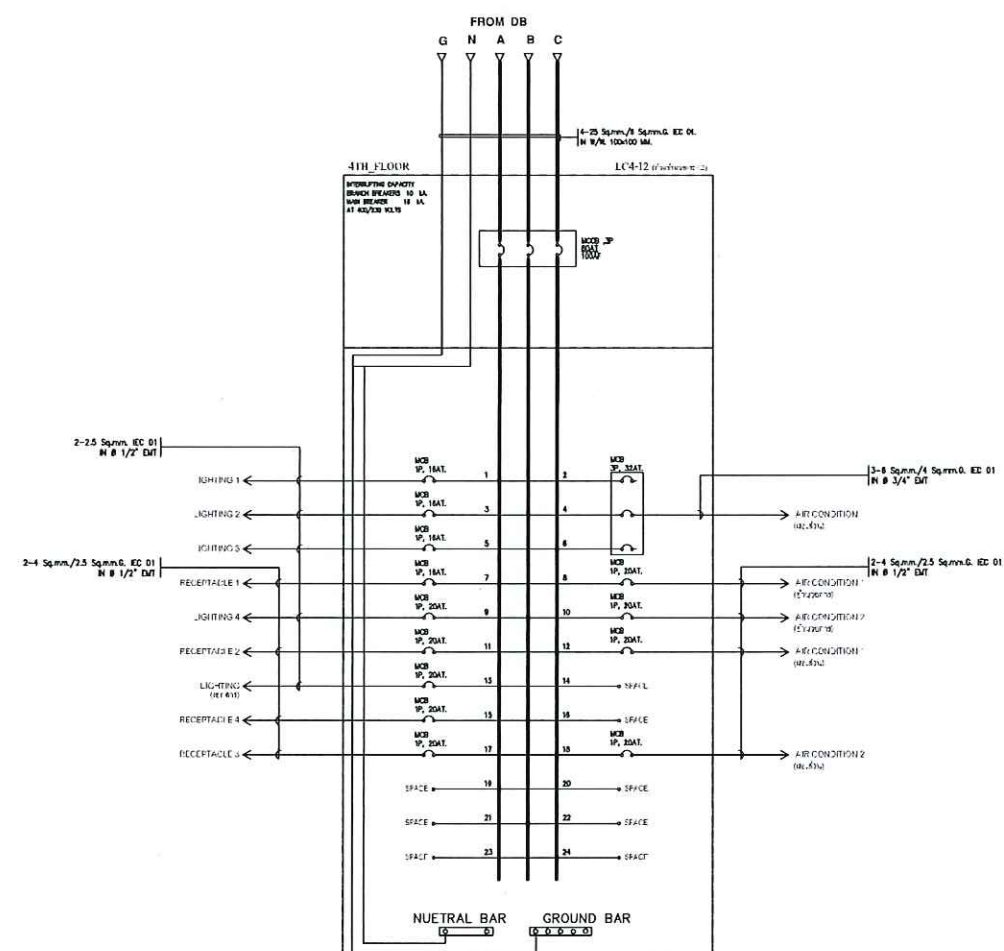

**SINGLE LINE DIAGRAM PANEL LC 4-12**