


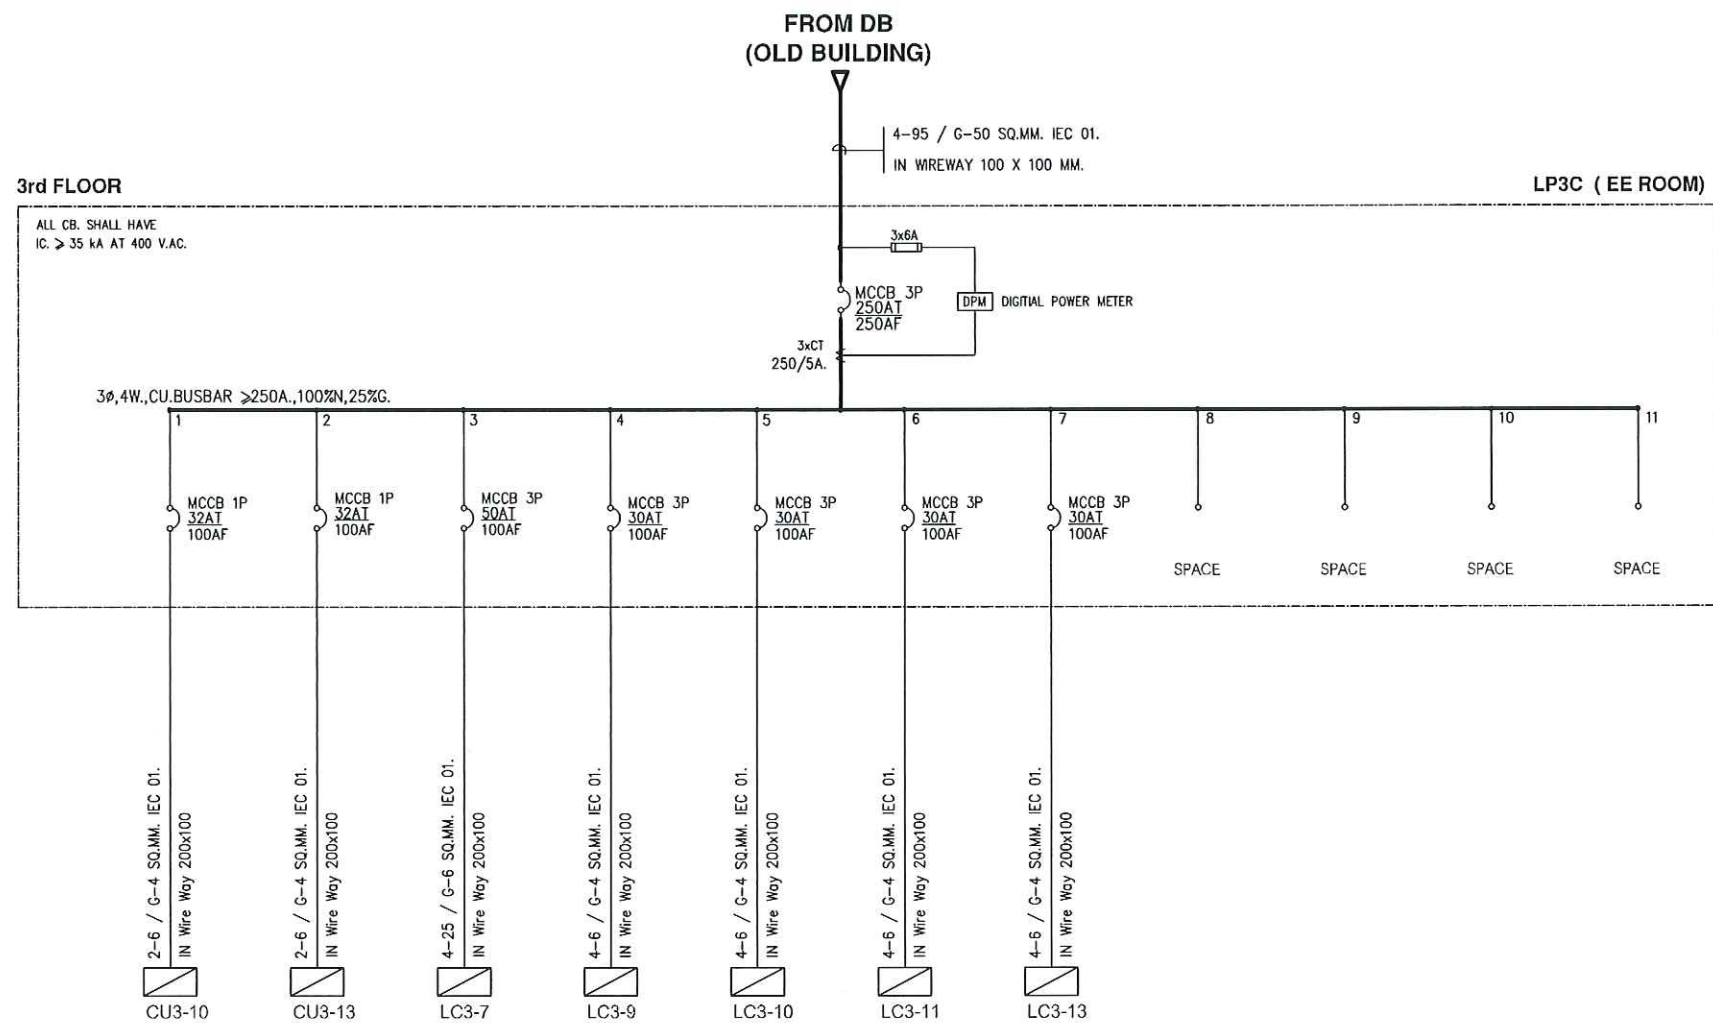

SINGLE LINE DIAGRAM LP3C

OWNER :

CONSULTANT :



King Mongkut's Institute
of Technology Ladkrabang
Chalongkrung Road, Ladkrabang, Bangkok 10520
TEL. (+66) 2-329-8000 , FAX (+66) 2-329-8204

CONTRACTOR :

PRELIMINARY

KEY PLAN

ENGINEER CERTIFICATION

SIGNATURE

NAME

SONGKRIT TRERATPICHAN

REGISTER No.

๖๗๙ ๙๕๗

REVISION

No.	DATE	BY	DESCRIPTION
1	07/20/18	-	PRELIMINARY

REVISION OF DRAWING : 0

PROJECT NAME :

Excise Department

DRAWING TITLE :

LP3 SINGLE LINE DIAGRAM

DRAWING No. :

EXD-20180720

SHEET : 3

OF : 3

SIZE : A3

DATE :


SCALE :

NTS

DRAW BY :

CHECKED BY :

APPROVED BY :

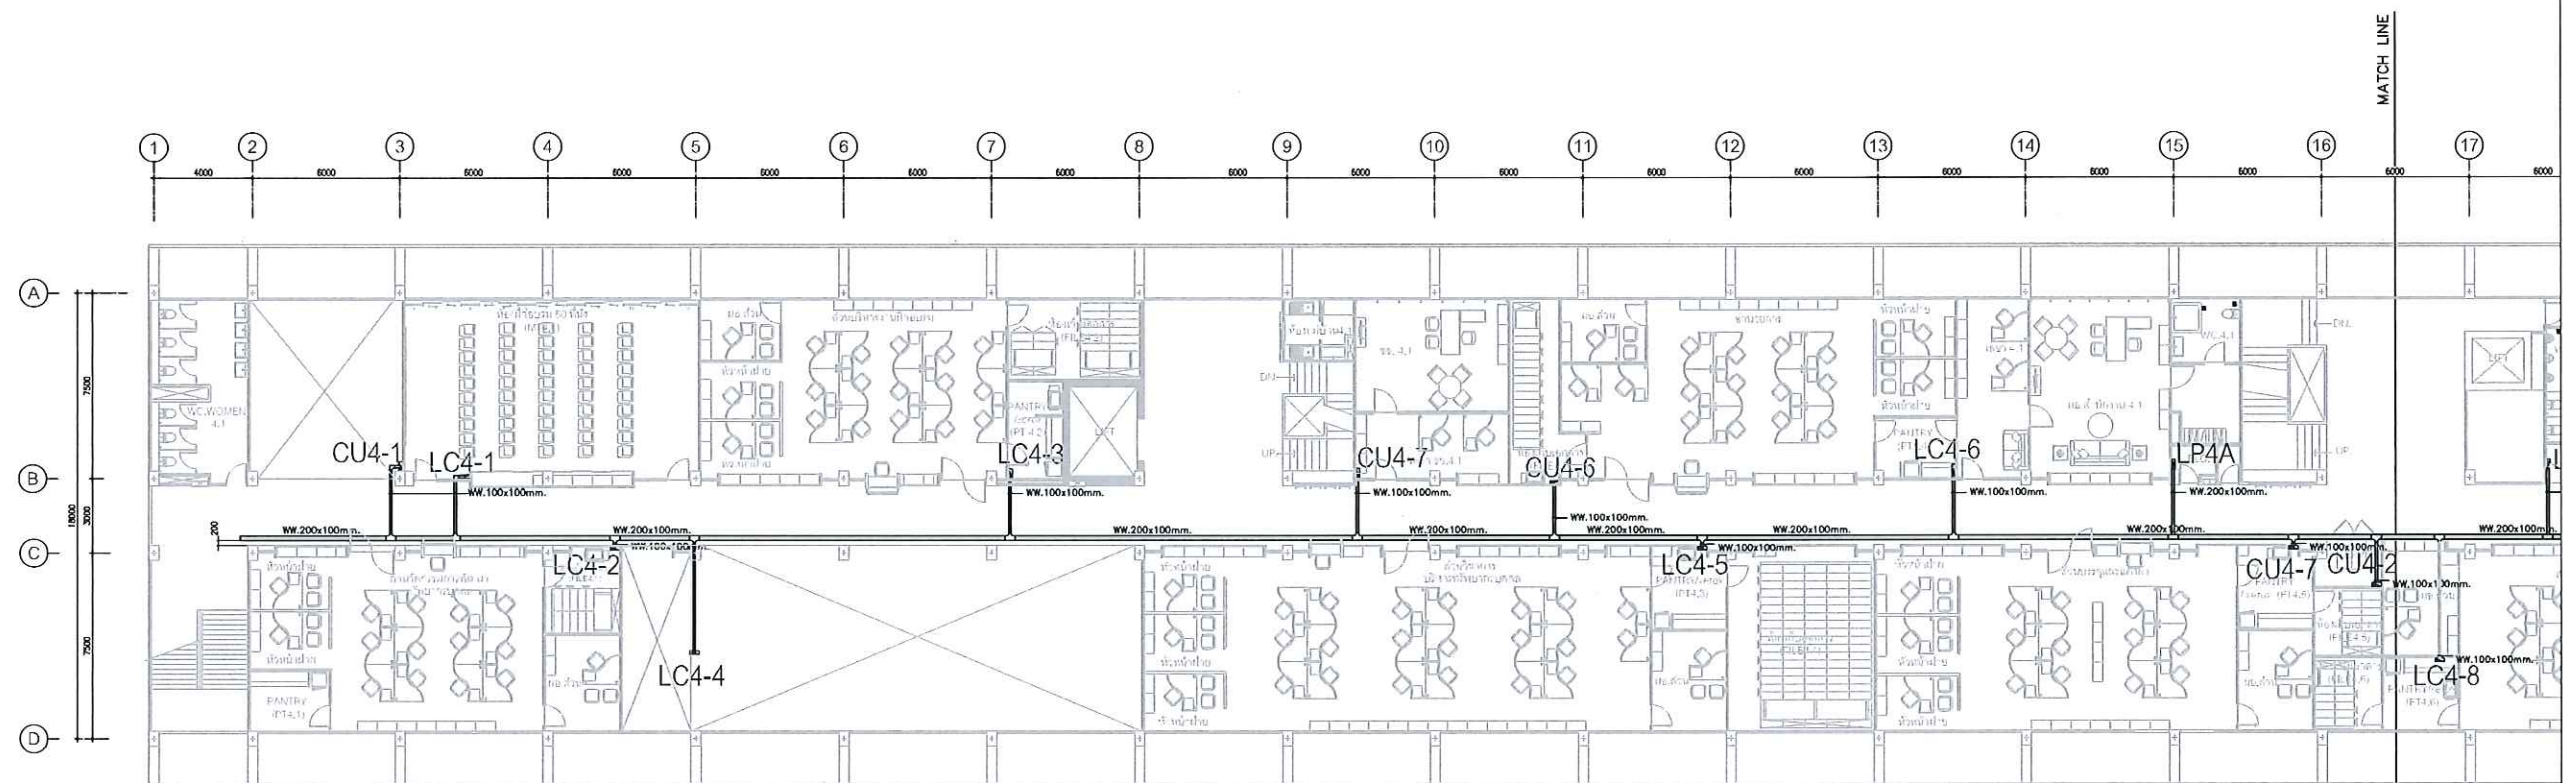

ผังรวมระบบไฟฟ้า ชั้น 4 ส่วนที่ 1

OWNER :

CONSULTANT :



King Mongkut's Institute
of Technology Ladkrabang
Chalongkrung Road, Ladkrabang, Bangkok 10520
TEL. (+66) 2-329-8000 , FAX. (+66) 2-329-8204

CONTRACTOR :

PRELIMINARY

KEY PLAN

ENGINEER CERTIFICATION

SIGNATURE 
NAME SONGKRIT TRERATPICHAN
REGISTER No. ๖๗๙ ๙๕๗

REVISION

No.	DATE	BY	DESCRIPTION
1	07/20/18	-	PRELIMINARY

REVISION OF DRAWING : 0

PROJECT NAME :

Excise Department

DRAWING TITLE :

4th FLOOR PLAN

DRAWING No. :

EXD-20180720

SHEET : 1 OF : 2 SIZE : A3


DATE : SCALE :
1:300

DRAW BY :

CHECKED BY :

APPROVED BY :



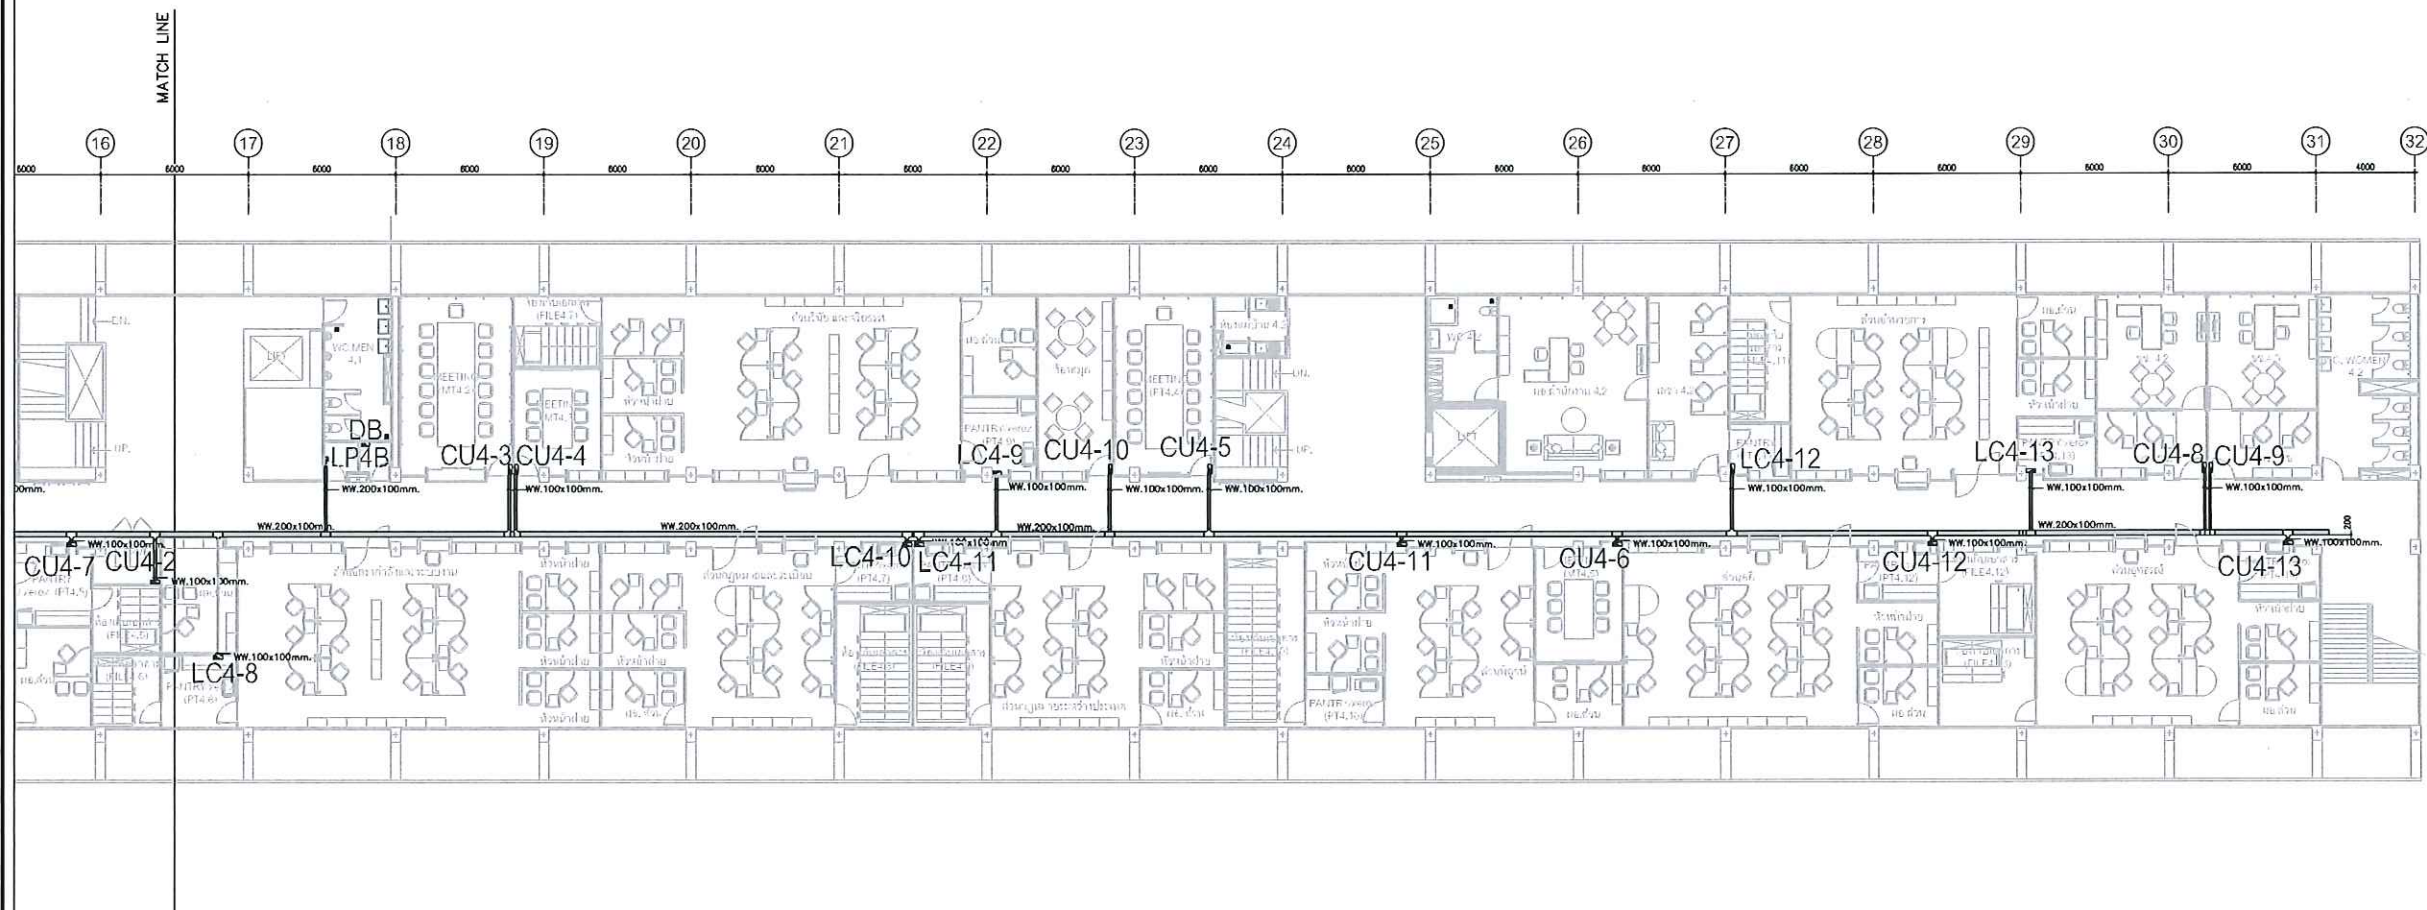

ผังรวมระบบไฟฟ้า ชั้น 4 ส่วนที่ 2

OWNER :

CONSULTANT :



King Mongkut's Institute
of Technology Ladkrabang
Chalongkrung Road, Ladkrabang, Bangkok 10520
TEL (+66) 2-329-8000 , FAX (+66) 2-329-8204

CONTRACTOR :

PRELIMINARY

KEY PLAN

ENGINEER CERTIFICATION

SIGNATURE 
NAME SONGKRIT TRERATPICHAN
REGISTER No. ๖๗๙ ๙๕๗

REVISION

No.	DATE	BY	DESCRIPTION
1	07/20/18	-	PRELIMINARY

REVISION OF DRAWING : 0

PROJECT NAME :

Excise Department

DRAWING TITLE :

4th FLOOR PLAN

DRAWING No. :

EXD-20180720

SHEET : 2 OF : 2 SIZE : A3


DATE : SCALE : 1:300

DRAW BY :

CHECKED BY :

APPROVED BY :

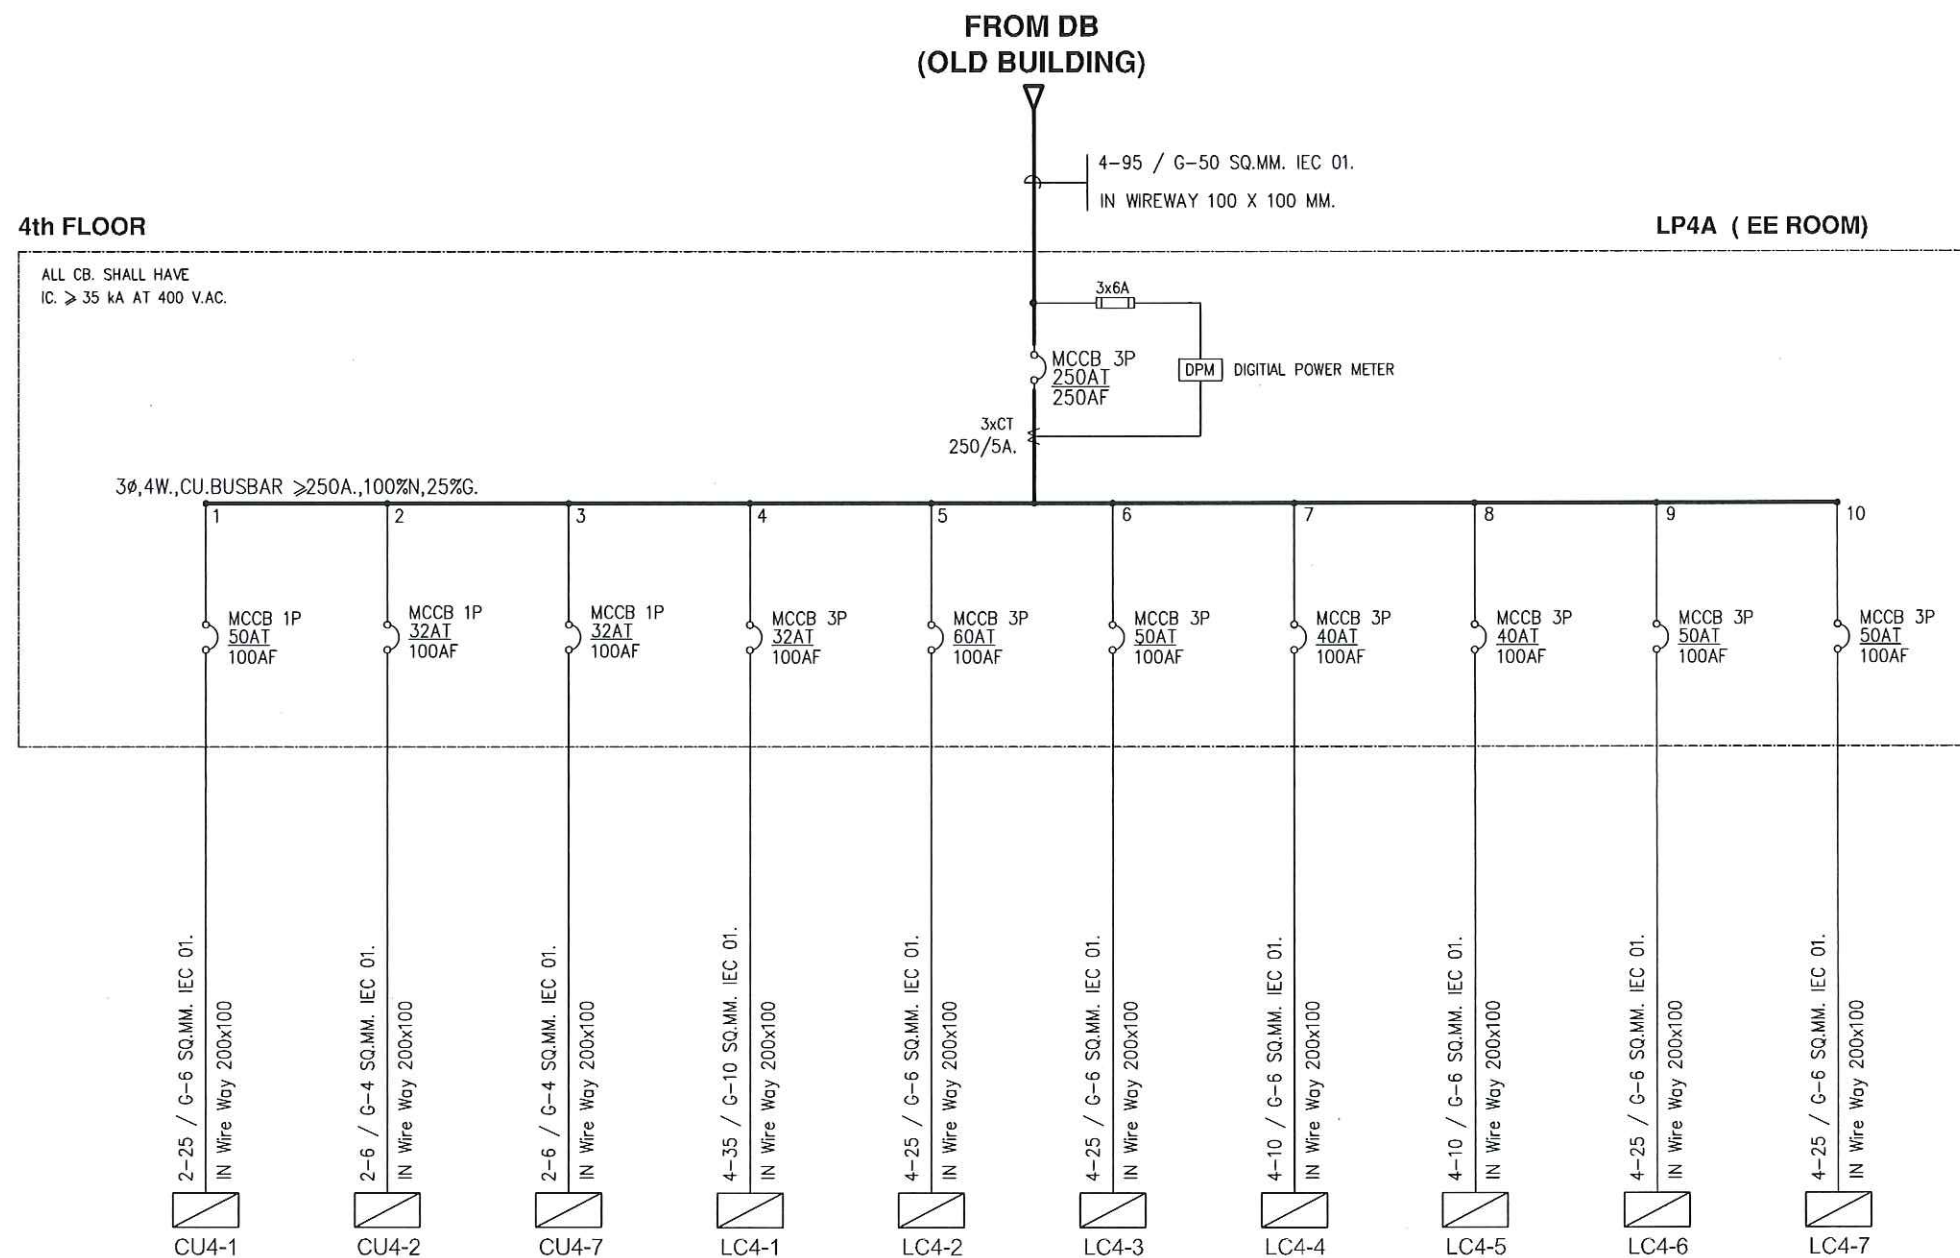

SINGLE LINE DIAGRAM LP4A

OWNER :

CONSULTANT :



King Mongkut's Institute
of Technology Ladkrabang
Chalongkrung Road, Ladkrabang, Bangkok 10520
TEL. (+66) 2-328-8000 , FAX. (+66) 2-328-8204

CONTRACTOR :

PRELIMINARY

KEY PLAN

ENGINEER CERTIFICATION

SIGNATURE

NAME SONGKRIT TRERATPICHAN

REGISTER No. ๖๗๙ 957

REVISION

No.	DATE	BY	DESCRIPTION
1	07/20/18	-	PRELIMINARY

REVISION OF DRAWING : 0

PROJECT NAME :

Excise Department

DRAWING TITLE :

LP4_SINGLE LINE DIAGRAM

DRAWING No. :

EXD-20180720

SHEET : 1 OF : 1 SIZE : A3


DATE : SCALE :

NTS

DRAW BY :

CHECKED BY :

APPROVED BY :

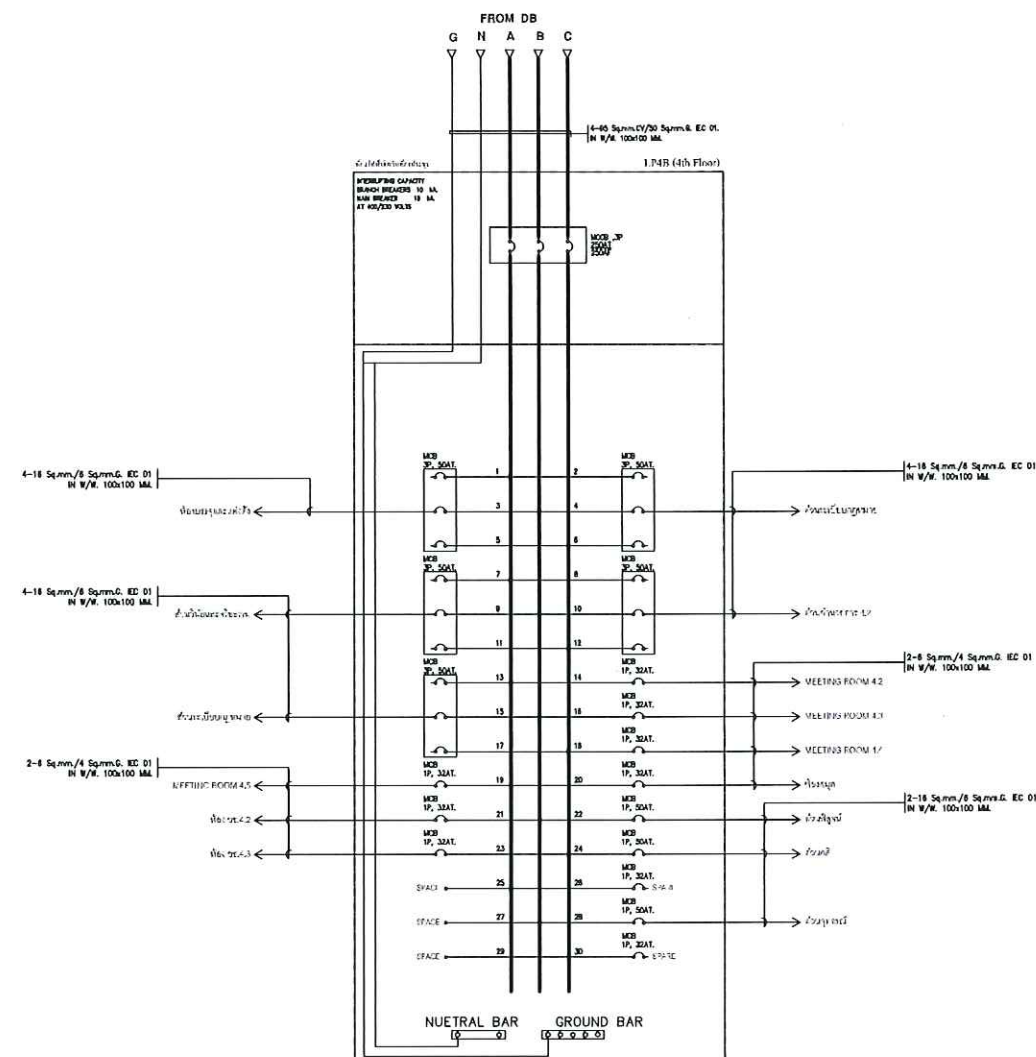

SINGLE LINE DIAGRAM PANEL LP4B

OWNER :

CONSULTANT :



King Mongkut's Institute
of Technology Ladkrabang
Chalongkrung Road, Ladkrabang, Bangkok 10520
TEL. (+66) 2-329-8000 , FAX. (+66) 2-329-8204

CONTRACTOR :

PRELIMINARY

KEY PLAN

ENGINEER CERTIFICATION

SIGNATURE
NAME SONGKRIT TRERATPICHAN
REGISTER No. ๖๗๙ ๙๕๗

REVISION

No.	DATE	BY	DESCRIPTION
1	07/20/18	-	PRELIMINARY

REVISION OF DRAWING : 0

PROJECT NAME :

Excise Department


DRAWING TITLE :

DIAGRAM_LP4B

DRAWING No. :

EXD-20180720

SHEET : 2 OF : 2 SIZE : A3
DATE : SCALE : NTS
DRAW BY :
CHECKED BY :
APPROVED BY :

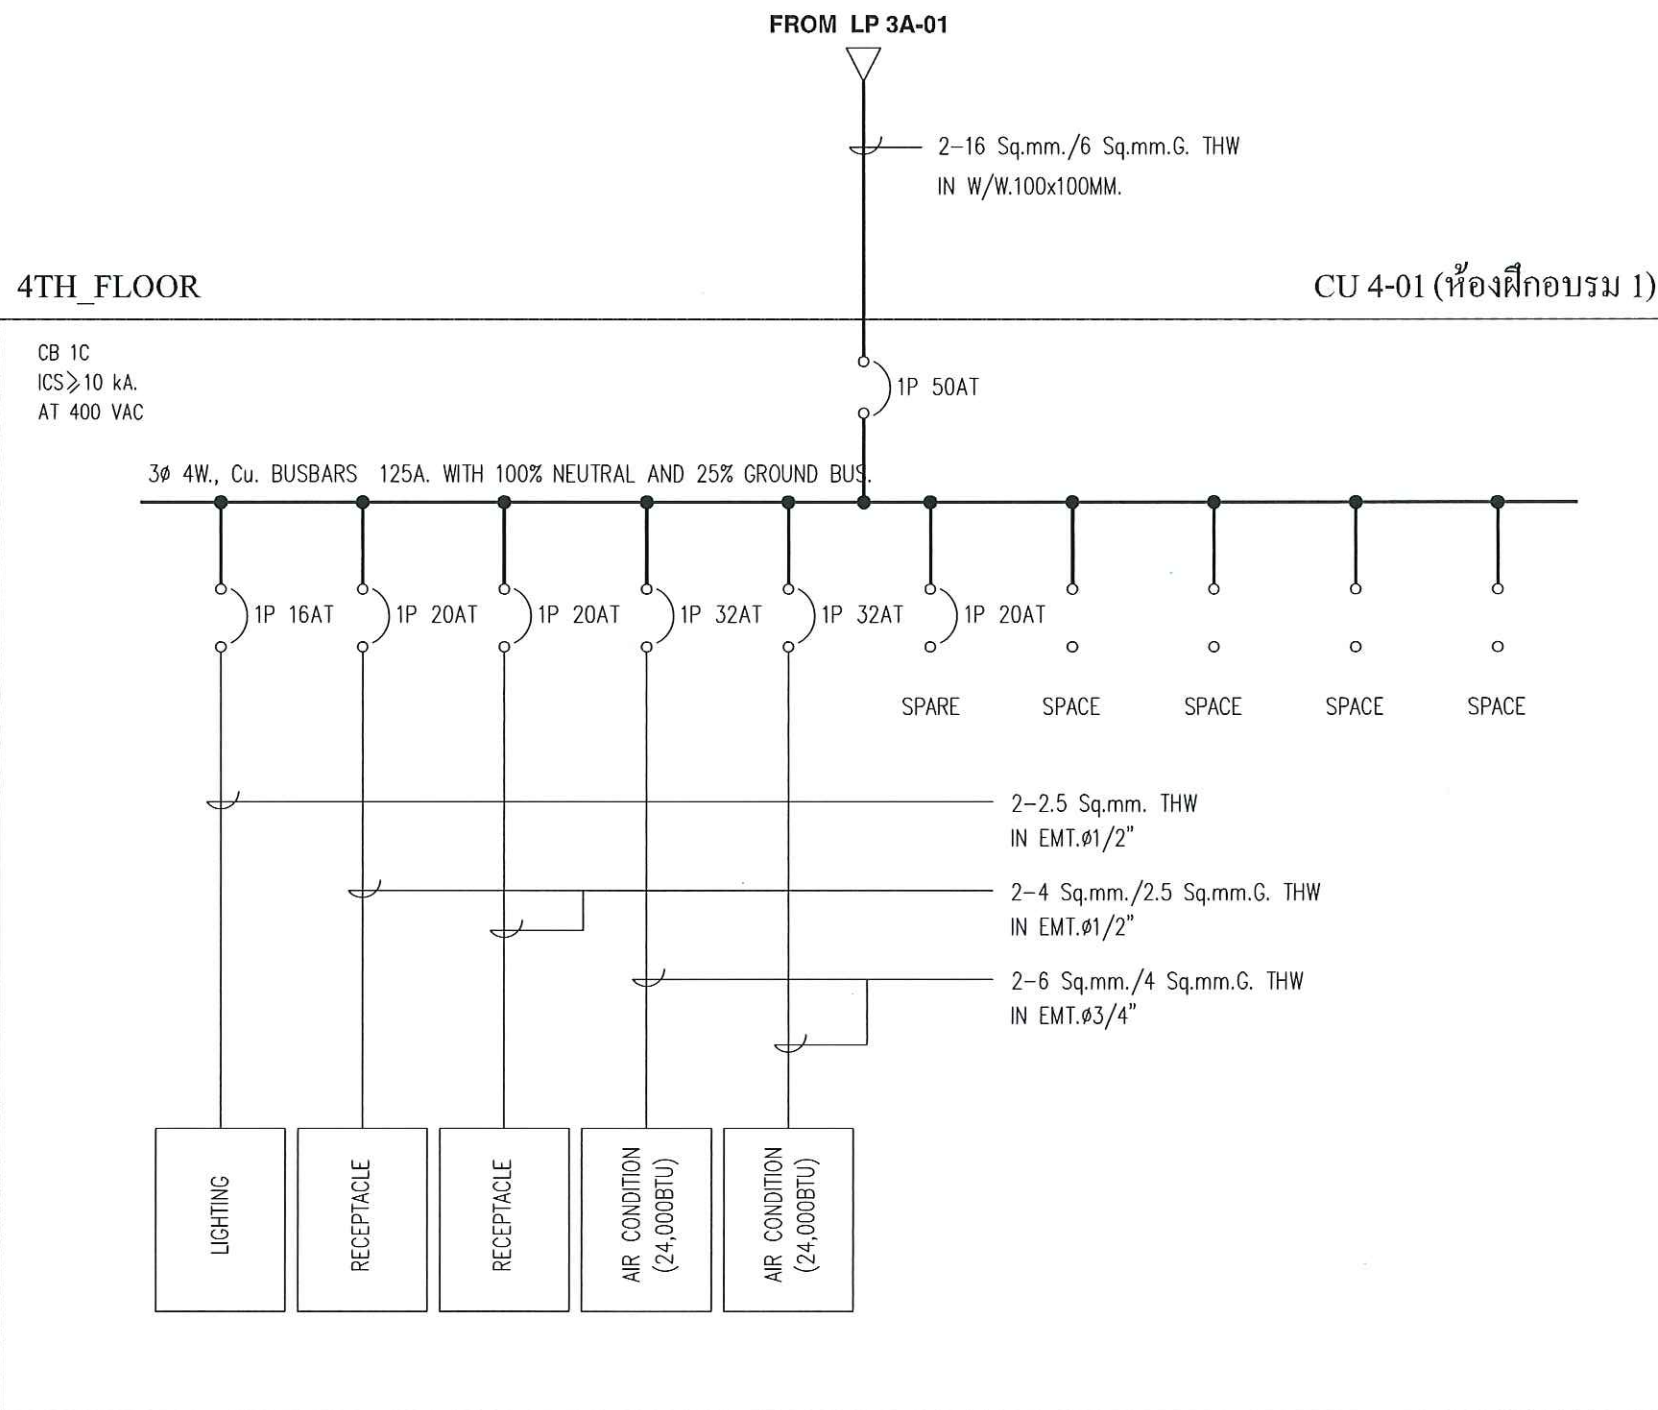

OWNER :

CONSULTANT :



King Mongkut's Institute
of Technology Ladkrabang
Chalongkrung Road, Ladkrabang, Bangkok 10520
TEL. (+66) 2-329-8000 , FAX (+66) 2-329-8204

CONTRACTOR :

PRELIMINARY

KEY PLAN

ENGINEER CERTIFICATION

SIGNATURE	
NAME	SONGKRIT TRERATPICHAN
REGISTER No.	วพท. 957

REVISION

No.	DATE	BY	DESCRIPTION
1	07/20/18	-	PRELIMINARY

REVISION OF DRAWING : 0

PROJECT NAME :

Excise Department

DRAWING TITLE :

CU 4-01_SINGLE LINE DIAGRAM

DRAWING No. :

EXD-20180720

SHEET : 1 OF : 13 SIZE : A3


DATE : SCALE :

NTS

DRAW BY :

CHECKED BY :

APPROVED BY :

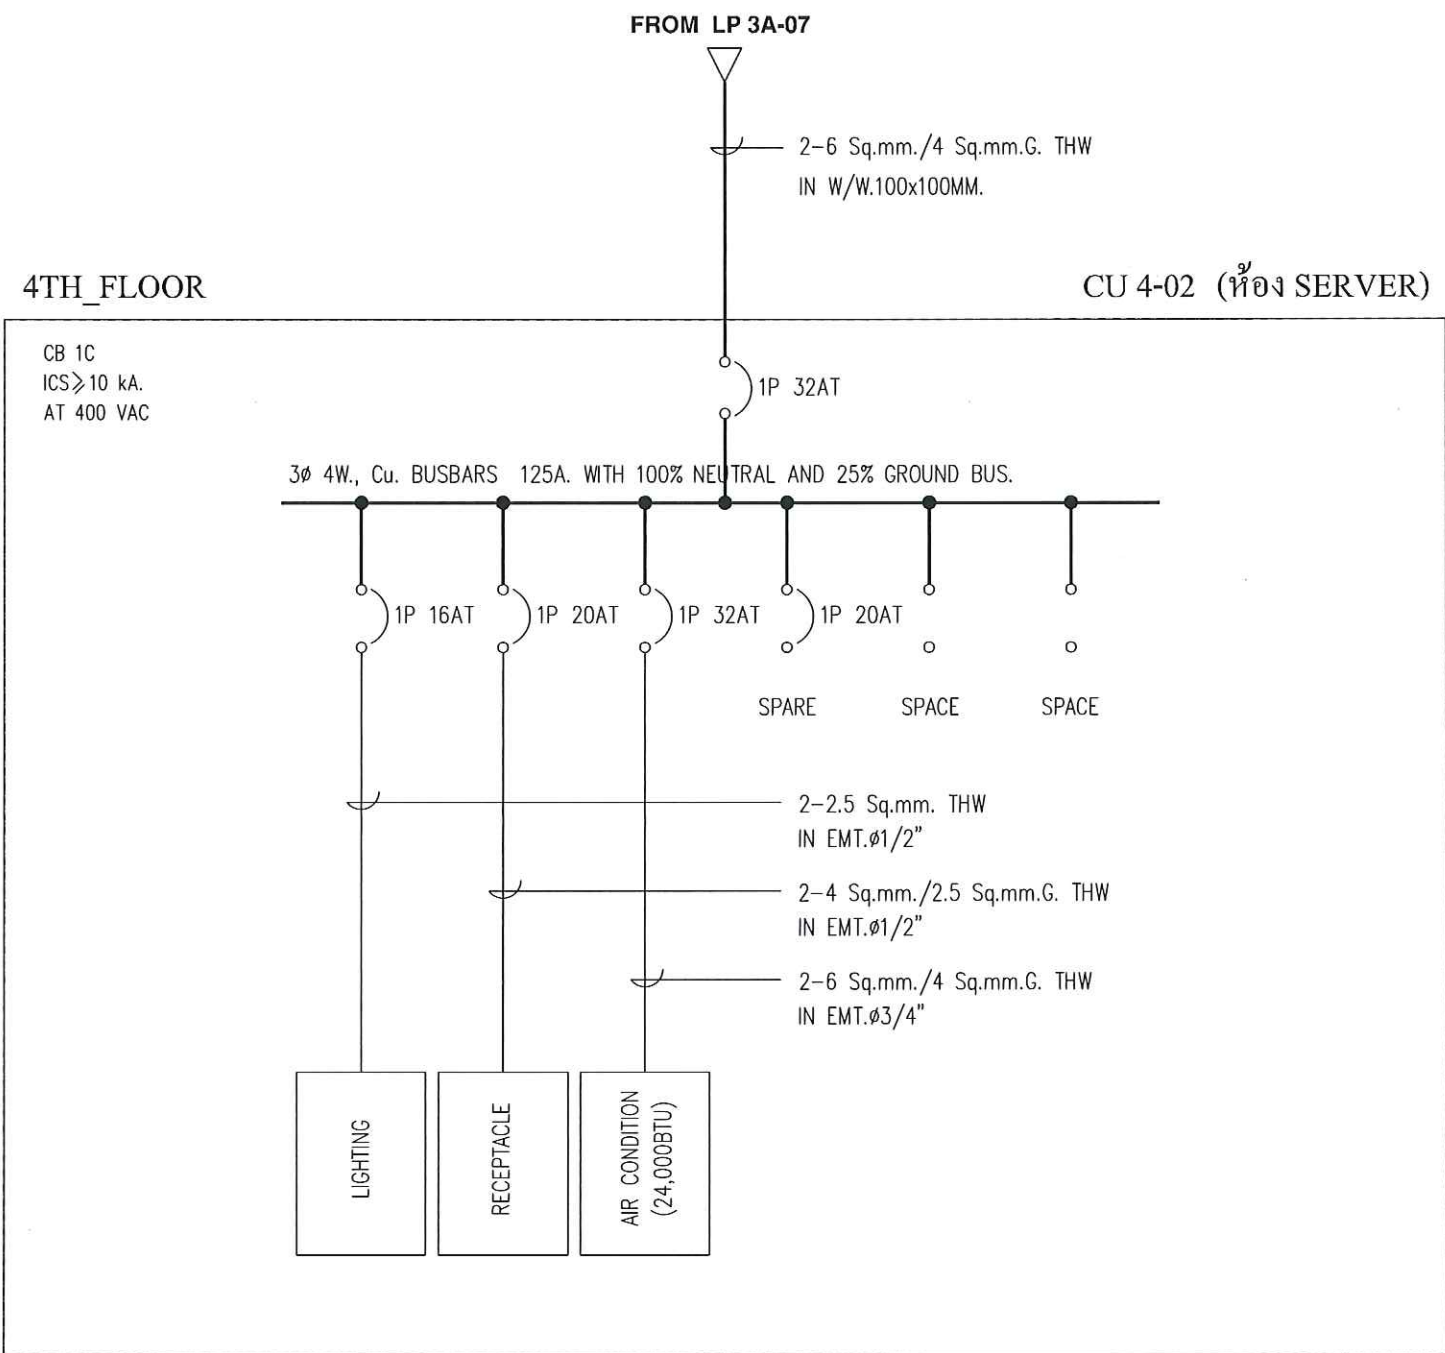

OWNER :

CONSULTANT :



King Mongkut's Institute
of Technology Ladkrabang
Chalongkrung Road, Ladkrabang, Bangkok 10520
TEL (+66) 2-329-8000 , FAX (+66) 2-329-8204

CONTRACTOR :

PRELIMINARY

KEY PLAN

ENGINEER CERTIFICATION

SIGNATURE	
NAME	SONGKRIT TRERATPICHAN
REGISTER No.	วทป 957

REVISION

No.	DATE	BY	DESCRIPTION
1	07/20/18	-	PRELIMINARY

REVISION OF DRAWING : 0

PROJECT NAME :

Excise Department

DRAWING TITLE :

CU 4-02_SINGLE LINE DIAGRAM

DRAWING No. :

EXD-20180720


SHEET : 2 OF : 13 SIZE : A3

DATE : SCALE :
NTS

DRAW BY :

CHECKED BY :

APPROVED BY :

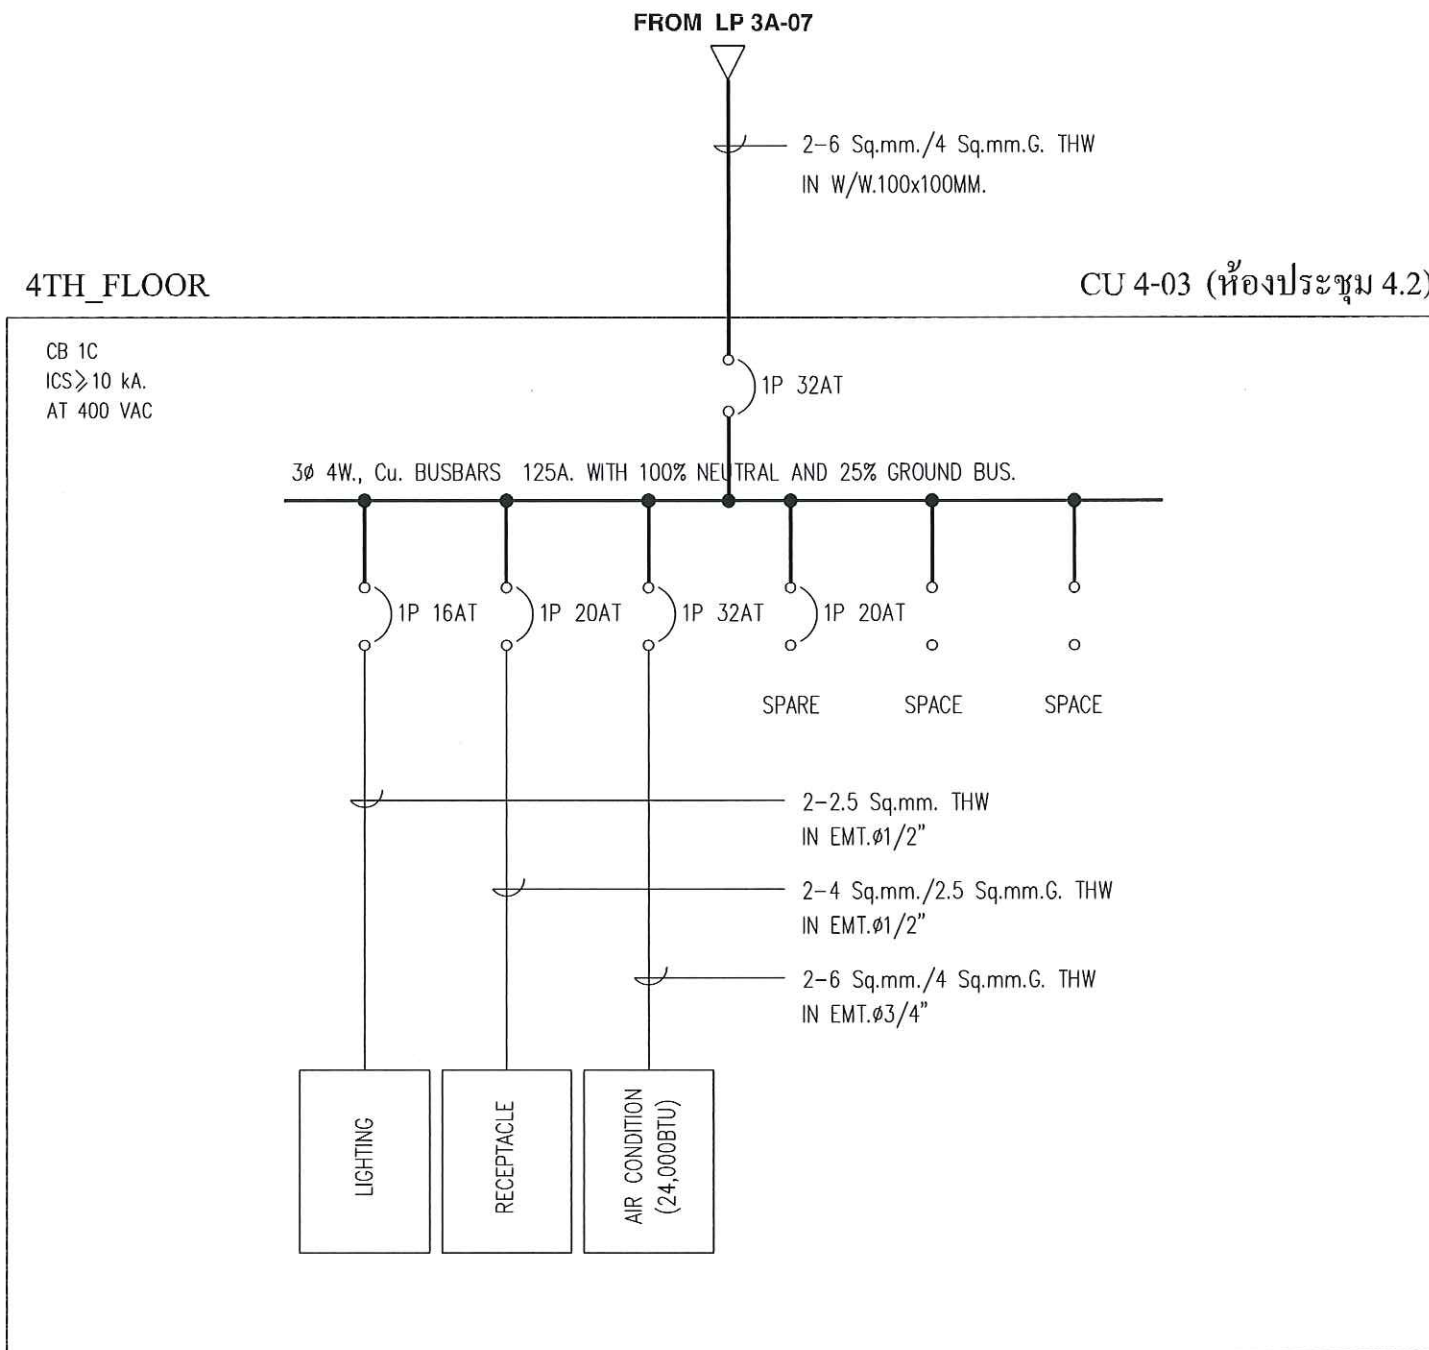

OWNER :

CONSULTANT :



King Mongkut's Institute
of Technology Ladkrabang
Chalongkrung Road, Ladkrabang, Bangkok 10520
TEL (+66) 2-329-8000 , FAX (+66) 2-329-8204

CONTRACTOR :

PRELIMINARY

KEY PLAN

ENGINEER CERTIFICATION

SIGNATURE	
NAME	SONGKRIT TRERATPICHAN
REGISTER No.	วทป 957

REVISION

No.	DATE	BY	DESCRIPTION
1	07/20/18	-	PRELIMINARY

REVISION OF DRAWING : 0

PROJECT NAME :

Excise Department

DRAWING TITLE :

CU 4-03_SINGLE LINE DIAGRAM

DRAWING No. :

EXD-20180720

SHEET : 3 OF : 13 SIZE : A3

DATE : SCALE :
NTS

DRAW BY :


CHECKED BY :

APPROVED BY :

4TH_FLOOR

CU 4-04 (ห้องประชุม 4.3)

CB 1C
ICS ≥ 10 kA.
AT 400 VAC

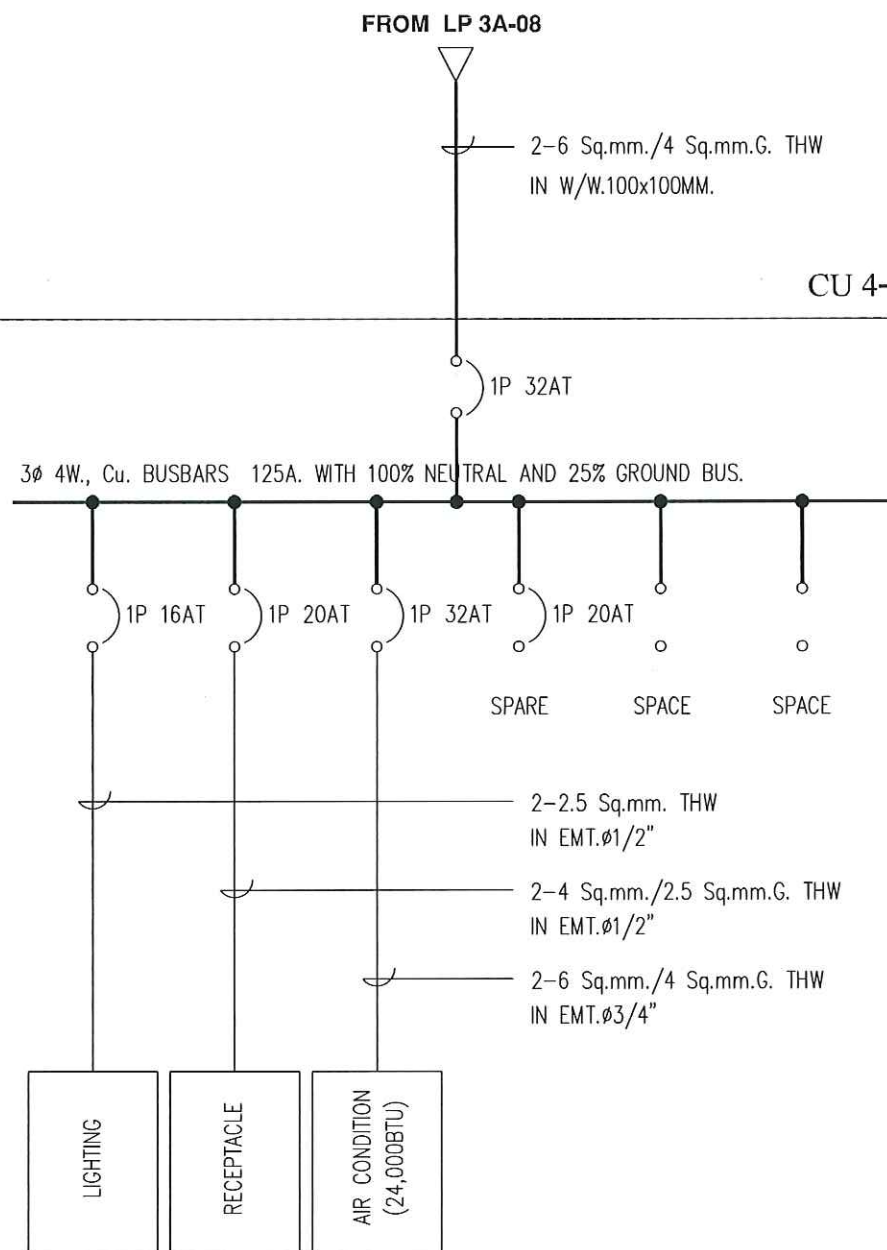

OWNER :

CONSULTANT :



King Mongkut's Institute
of Technology Ladkrabang
Chalongkrung Road, Ladkrabang, Bangkok 10520
TEL. (+66) 2-329-8000 , FAX. (+66) 2-329-8204

CONTRACTOR :

PRELIMINARY

KEY PLAN

ENGINEER CERTIFICATION

SIGNATURE	
NAME	SONGKRIT TRERATPICHAN
REGISTER No.	วทศ 957

REVISION			
No.	DATE	BY	DESCRIPTION
1	07/20/18	-	PRELIMINARY

REVISION OF DRAWING : 0

PROJECT NAME :

Excise Department

DRAWING TITLE :

CU 4-04_SINGLE LINE DIAGRAM

DRAWING No. :

EXD-20180720

SHEET : 4	OF : 13	SIZE : A3
DATE :	SCALE :	NTS
DRAW BY :		
CHECKED BY :		
APPROVED BY :		