



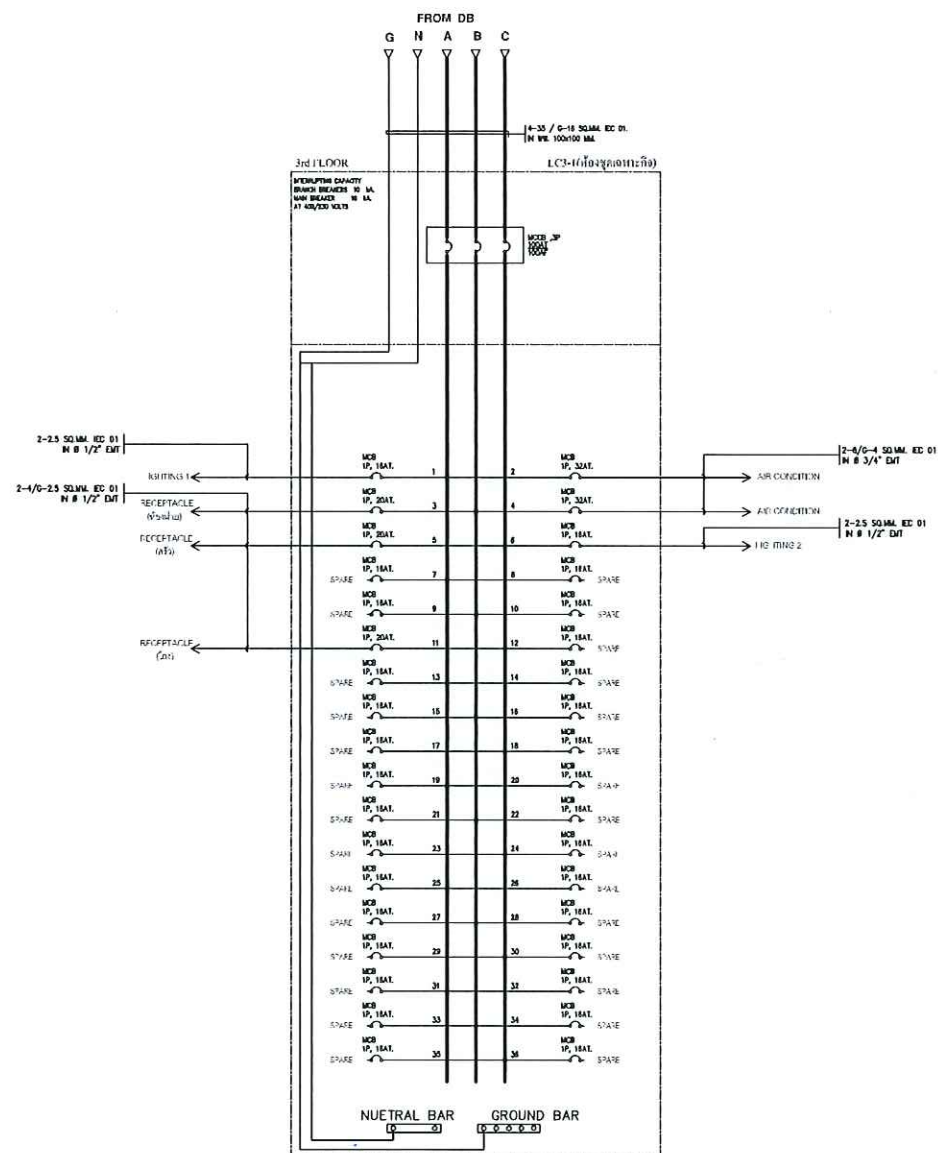

SINGLE LINE DIAGRAM LC 3-1

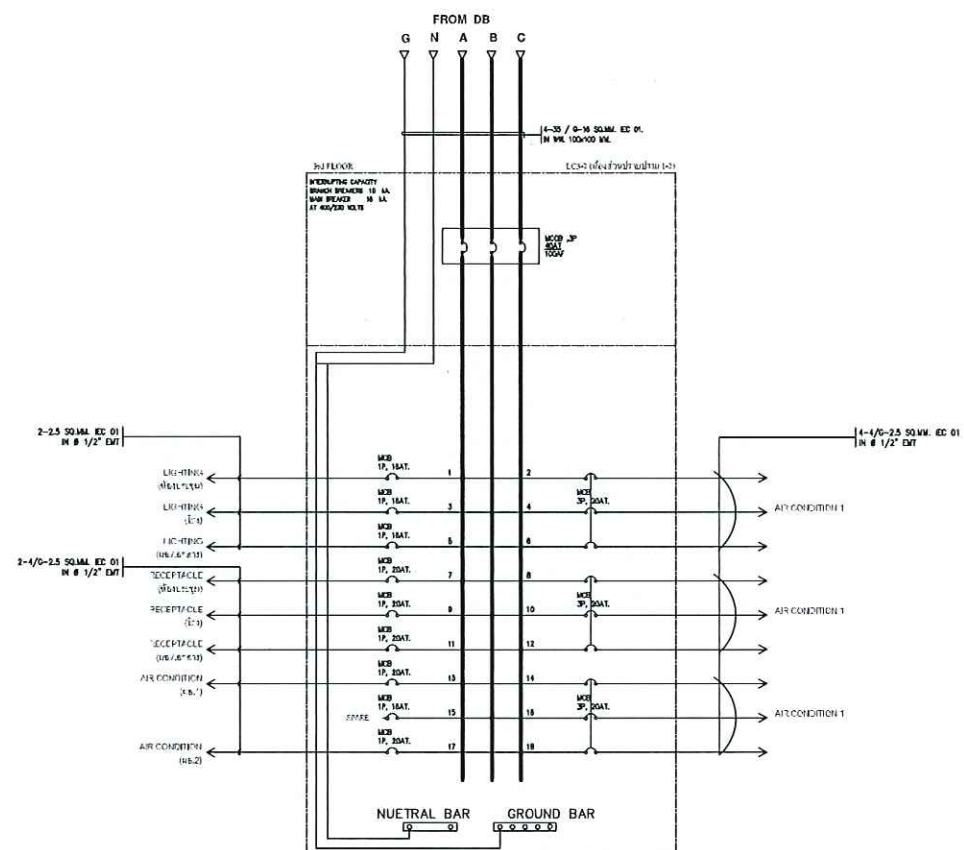

SINGLE LINE DIAGRAM LC 3-2

OWNER :

CONSULTANT :



King Mongkut's Institute
of Technology Ladkrabang
Chalongkrung Road, Ladkrabang, Bangkok 10520
TEL. (+66) 2-329-8000 , FAX. (+66) 2-329-8204

CONTRACTOR :

PRELIMINARY

KEY PLAN

ENGINEER CERTIFICATION

SIGNATURE
NAME SONGKRIT TRERATPICHAN
REGISTER No. 957

REVISION

No.	DATE	BY	DESCRIPTION
1	07/20/18	-	PRELIMINARY

REVISION OF DRAWING : 0

PROJECT NAME :

Excise Department

DRAWING TITLE :

DIAGRAM LC 3-1&LC 3-2

DRAWING No. :

EXD-20180720

SHEET : 1 OF : 1 SIZE : A3

DATE : SCALE : 1:1

DRAW BY :

CHECKED BY :

APPROVED BY :

CONTRACTOR :

PRELIMINARY

KEY PLAN

ENGINEER CERTIFICATION

SIGNATURE

NAME

REGISTER N

REVISION

No.	DATE	BY	DESCRIPTION
1	07/20/18	—	PRELIMINARY

REVISION OF DRAWING : 0

PROJECT NAME :

Excise Department

DRAWING TITLE :

DIAGRAM LC 3-5&LC 3-6

DRAWING No. :

EXP-20180720

SHEET : 1

OF : 1

SIZE : A3

DATE :


SCALE :

1:1


DRAW BY :

CHECKED BY :

APPROVED BY :

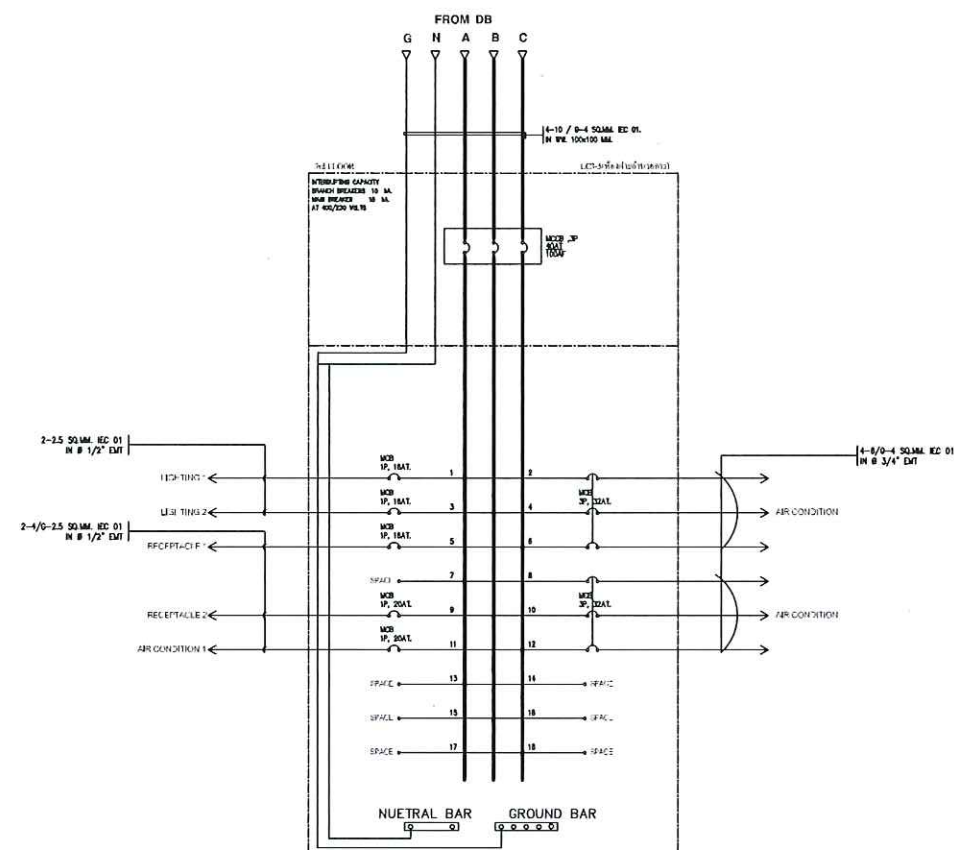

SINGLE LINE DIAGRAM LC 3-5

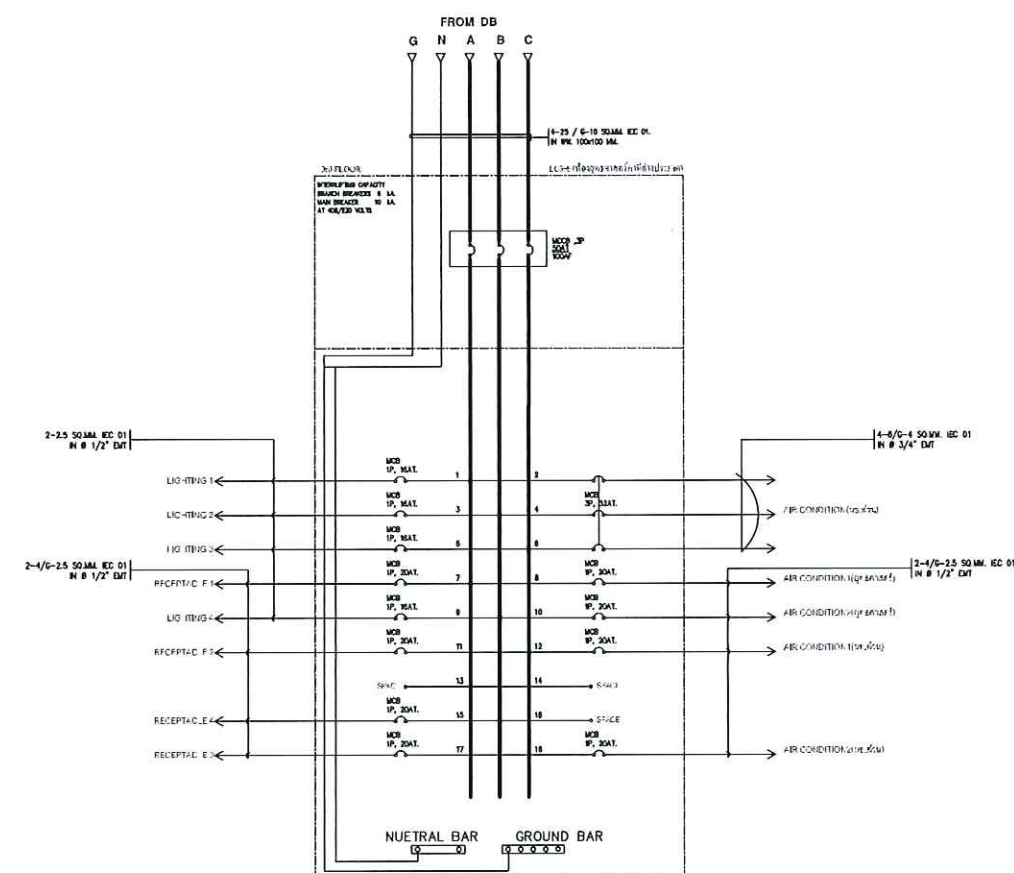


SINGLE LINE DIAGRAM LC 3-6

Handwritten signature: *[Signature]*


SINGLE LINE DIAGRAM LC 3-9

APPROVED BY :



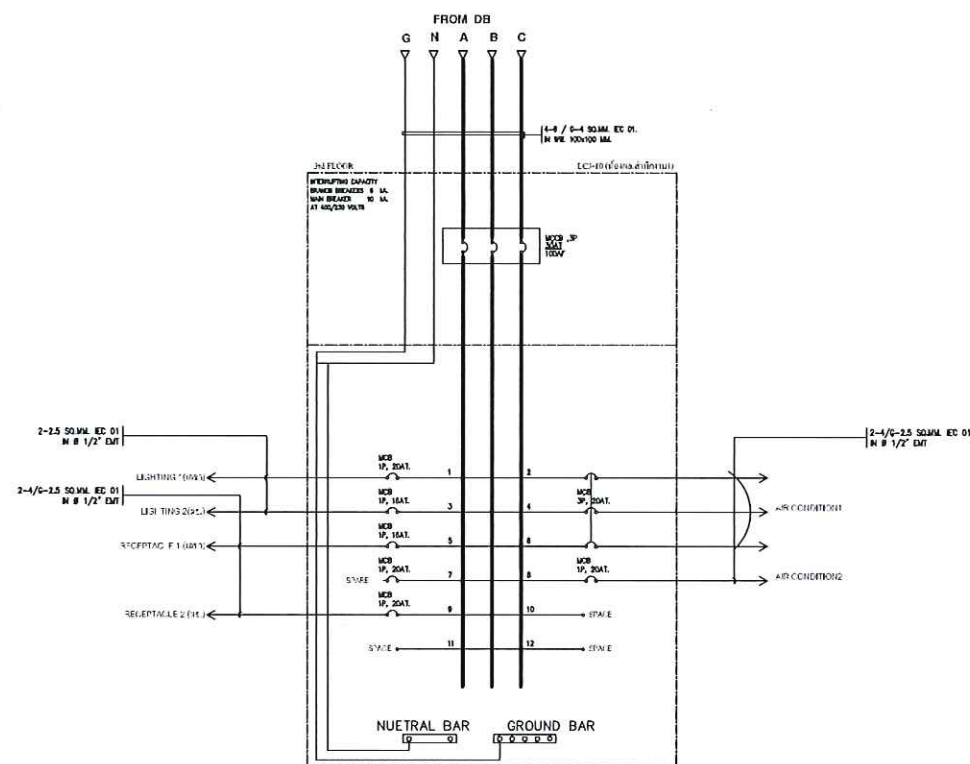

SINGLE LINE DIAGRAM LC 3-10

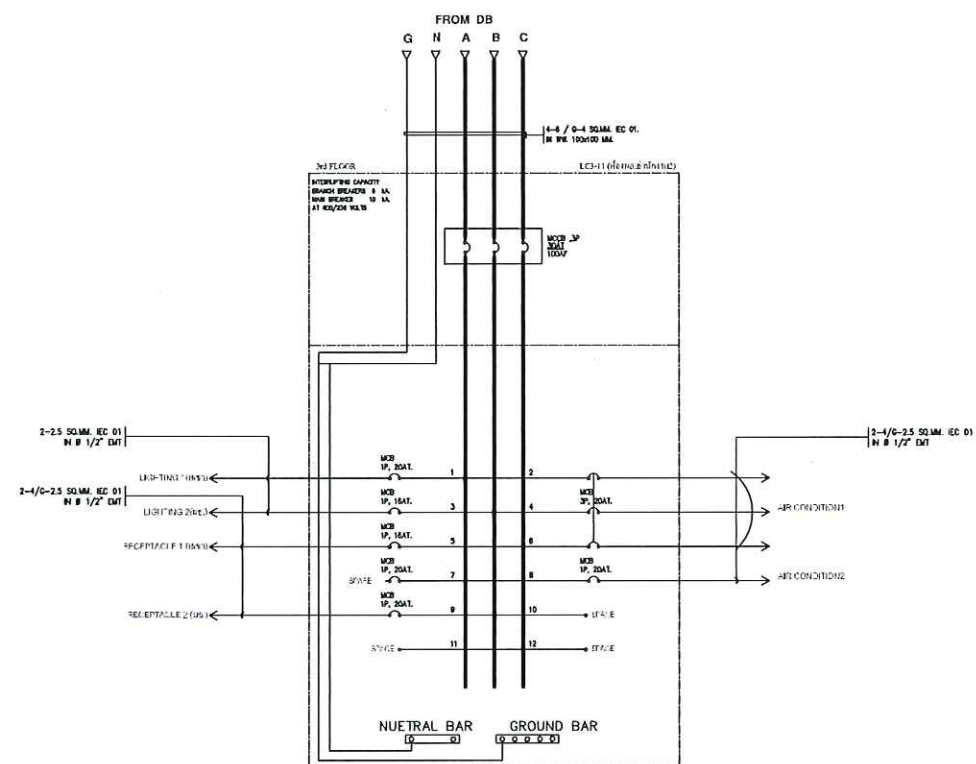

SINGLE LINE DIAGRAM LC 3-11

[Handwritten signatures]

OWNER :

CONSULTANT :



King Mongkut's Institute
of Technology Ladkrabang
Chalongkrung Road, Ladkrabang, Bangkok 10520
TEL. (+66) 2-329-8000 , FAX. (+66) 2-329-8204

CONTRACTOR :

PRELIMINARY

KEY PLAN

ENGINEER CERTIFICATION

SIGNATURE *[Signature]*
NAME SONGKRIT TRERATPICHAN
REGISTER No. ๖๗ ๙๕๗

REVISION

No.	DATE	BY	DESCRIPTION
1	07/20/18	-	PRELIMINARY

REVISION OF DRAWING : 0

PROJECT NAME :

Excise Department


DRAWING TITLE :

DIAGRAM LC 3-10&LC 3-11

DRAWING No. :


EXD-20180720


SHEET : 1	OF : 1	SIZE : A3
DATE :	SCALE :	NTS
DRAW BY :		
CHECKED BY :		
APPROVED BY :		

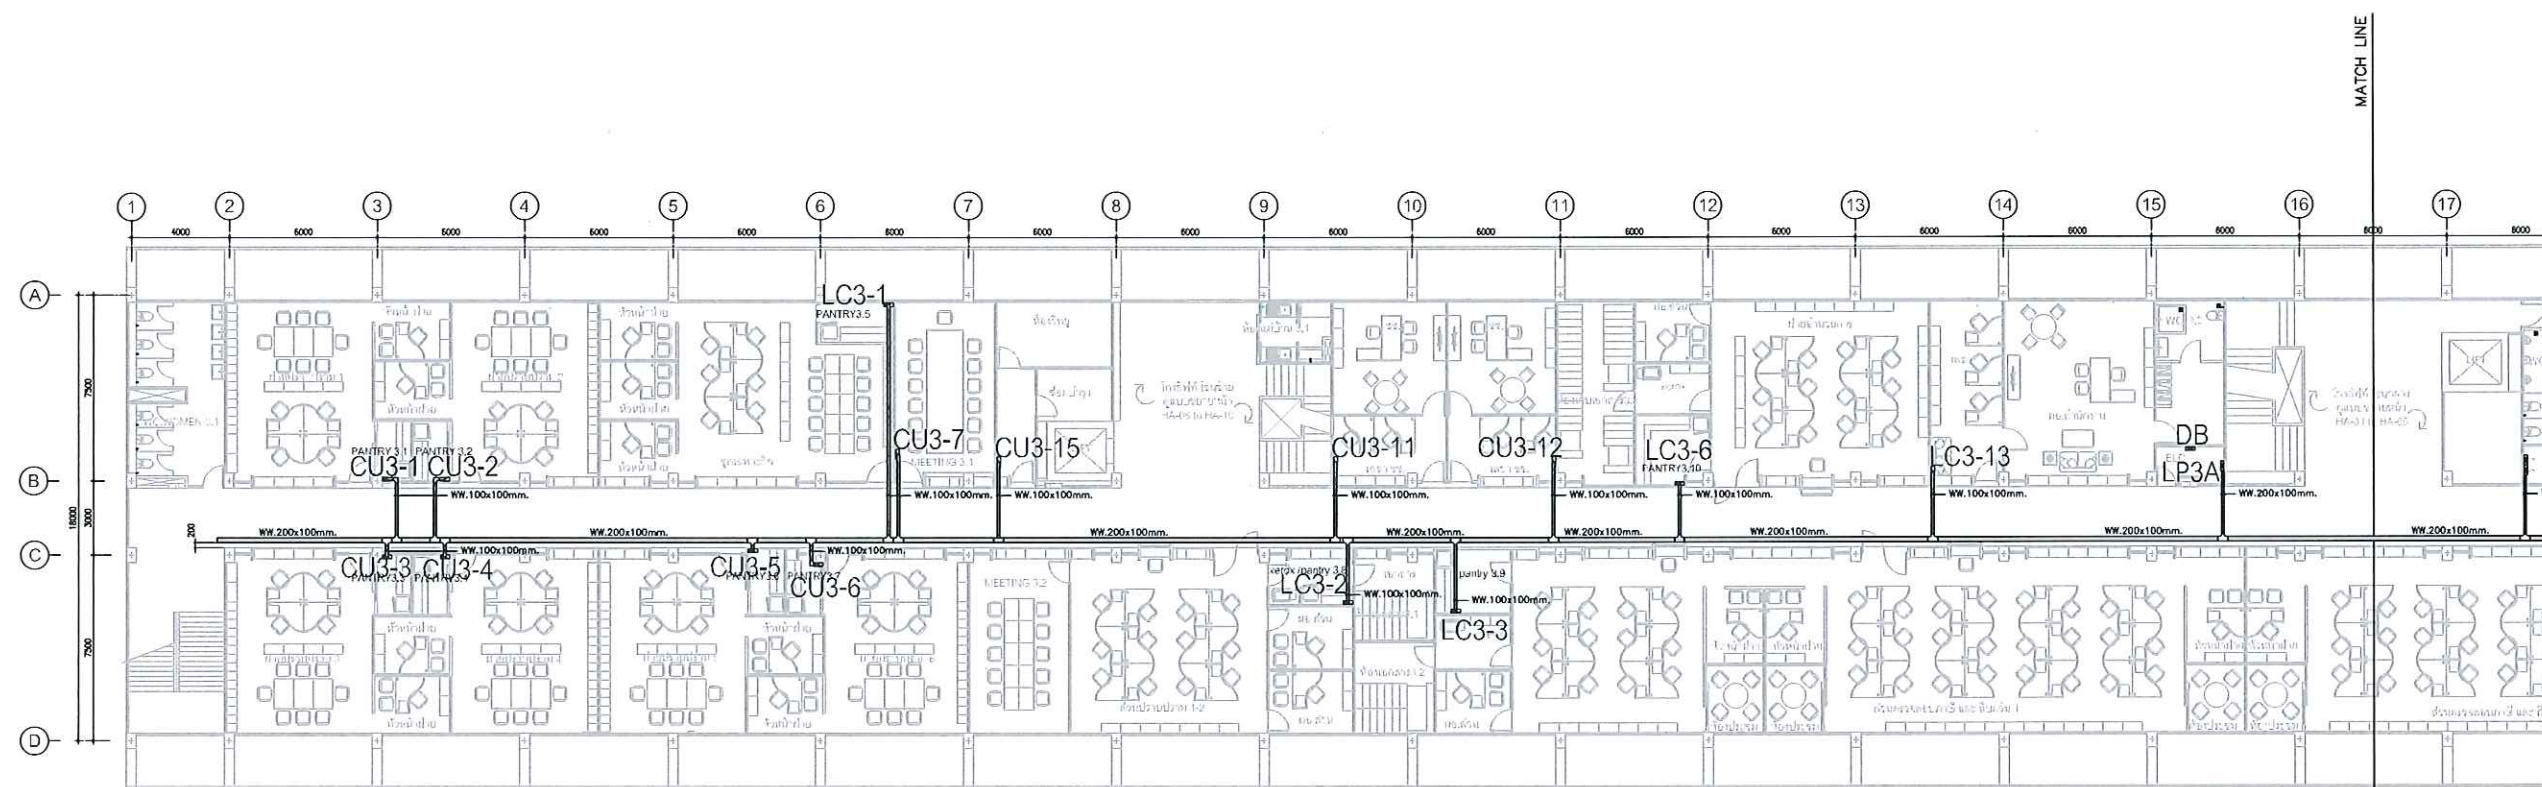

ผังรวมระบบไฟฟ้า ชั้น 3 ส่วนที่ 1

OWNER :		
CONSULTANT :		
 King Mongkut's Institute of Technology Ladkrabang Chalongkrung Road, Ladkrabang, Bangkok 10520 TEL. (+66) 2-329-8000 , FAX. (+66) 2-329-8204		
CONTRACTOR :		
PRELIMINARY		
KEY PLAN		
ENGINEER CERTIFICATION		
SIGNATURE		
NAME	SONGKRIT TRERATPICHAN	
REGISTER No.	ทพ 957	
REVISION		
No.	DATE	DESCRIPTION
1	07/20/18	PRELIMINARY
REVISION OF DRAWING : 0		
PROJECT NAME :		
Excise Department		
DRAWING TITLE :		
3 rd FLOOR PLAN		
DRAWING No. :		
EXD-20180720		
SHEET : 1	OF : 2	SIZE : A3
DATE :	SCALE : 1:300	
DRAW BY :		
CHECKED BY :		
APPROVED BY :		

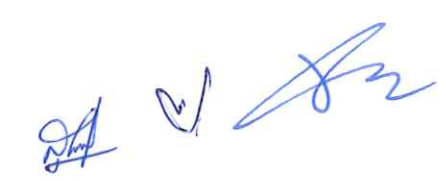

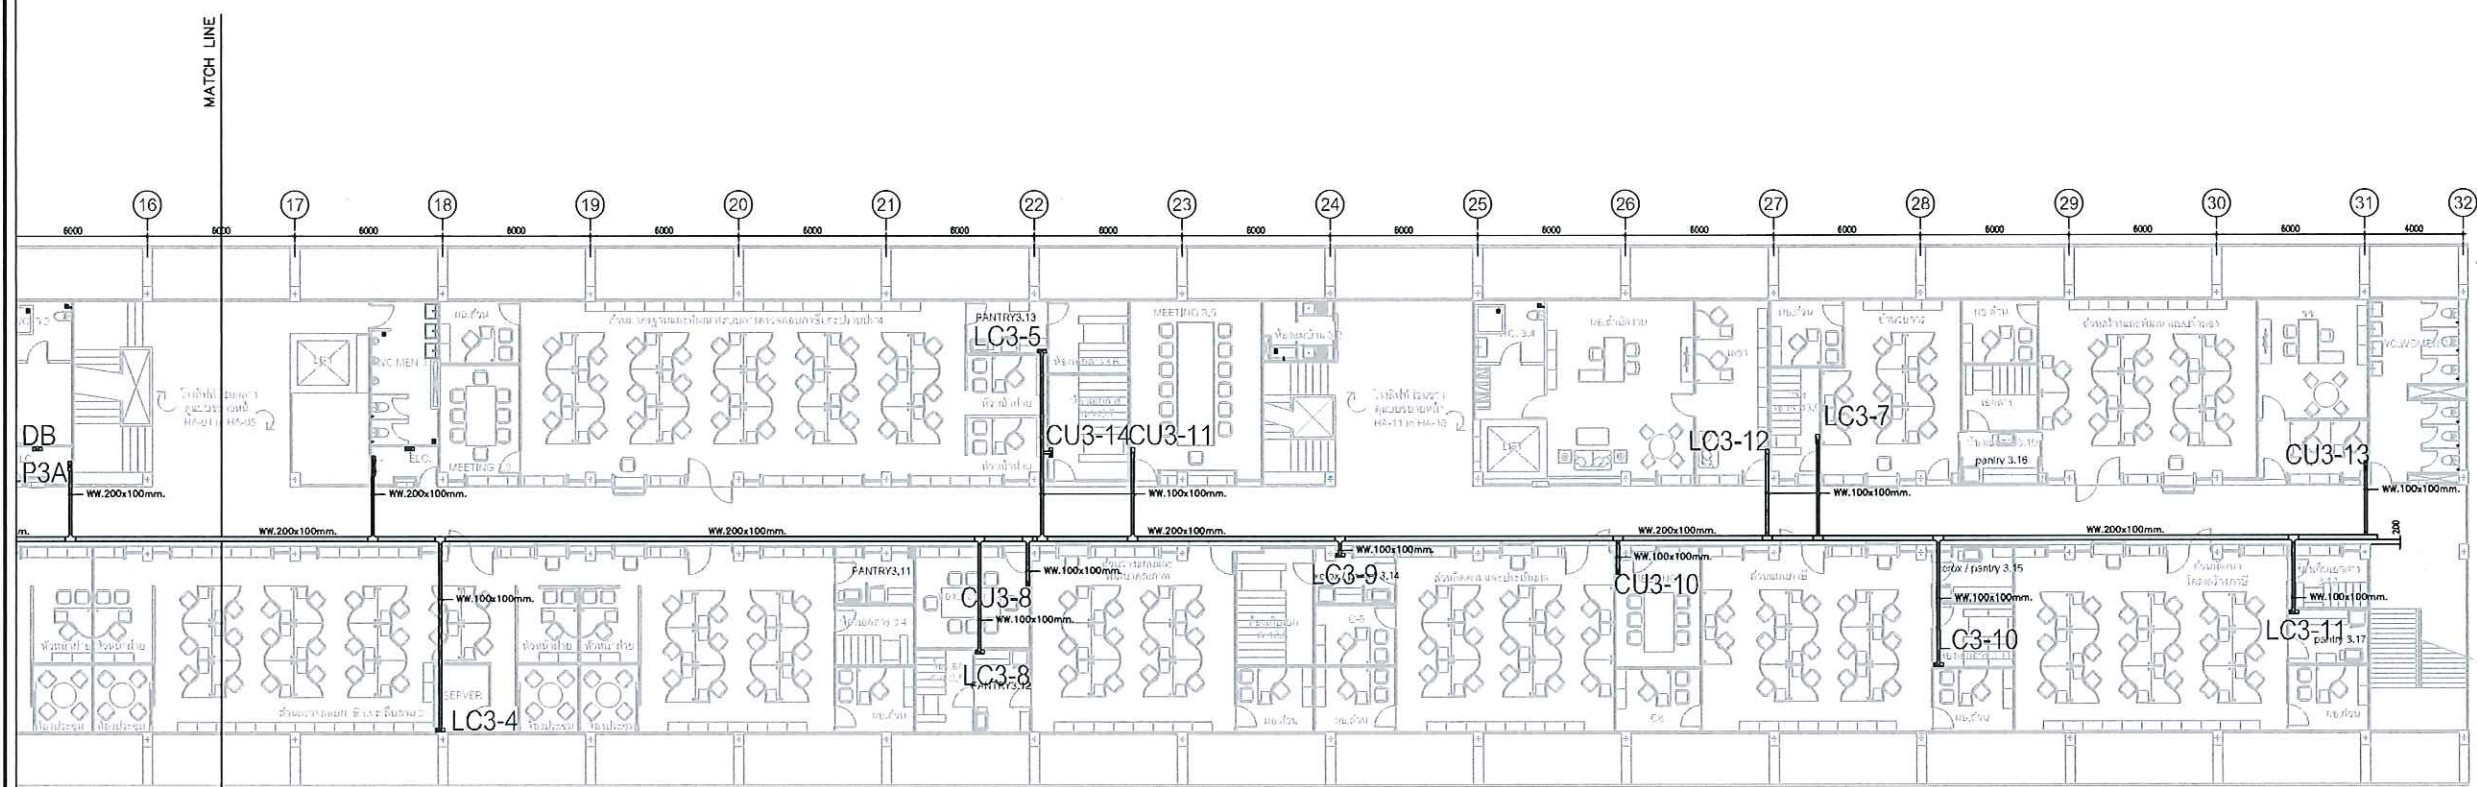

ผังรวมระบบไฟฟ้า ชั้น 3 ส่วนที่ 2

OWNER :

CONSULTANT :

 King Mongkut's Institute of Technology Ladkrabang
 Chalongkrung Road, Ladkrabang, Bangkok 10520
 TEL. (+66) 2-329-8000 , FAX (+66) 2-329-8204

CONTRACTOR :

PRELIMINARY
KEY PLAN

ENGINEER CERTIFICATION

SIGNATURE	
NAME	SONGKRIT TRERATPICHAN
REGISTER No.	วทศ 957

REVISION

No.	DATE	BY	DESCRIPTION
1	07/20/18	-	PRELIMINARY

REVISION OF DRAWING : 0


PROJECT NAME :
Excise Department

DRAWING TITLE :
3 rd FLOOR PLAN

DRAWING No. :
EXD-20180720

SHEET : 2	OF : 2	SIZE : A3
DATE :	SCALE :	1:300
DRAW BY :		
CHECKED BY :		
APPROVED BY :		

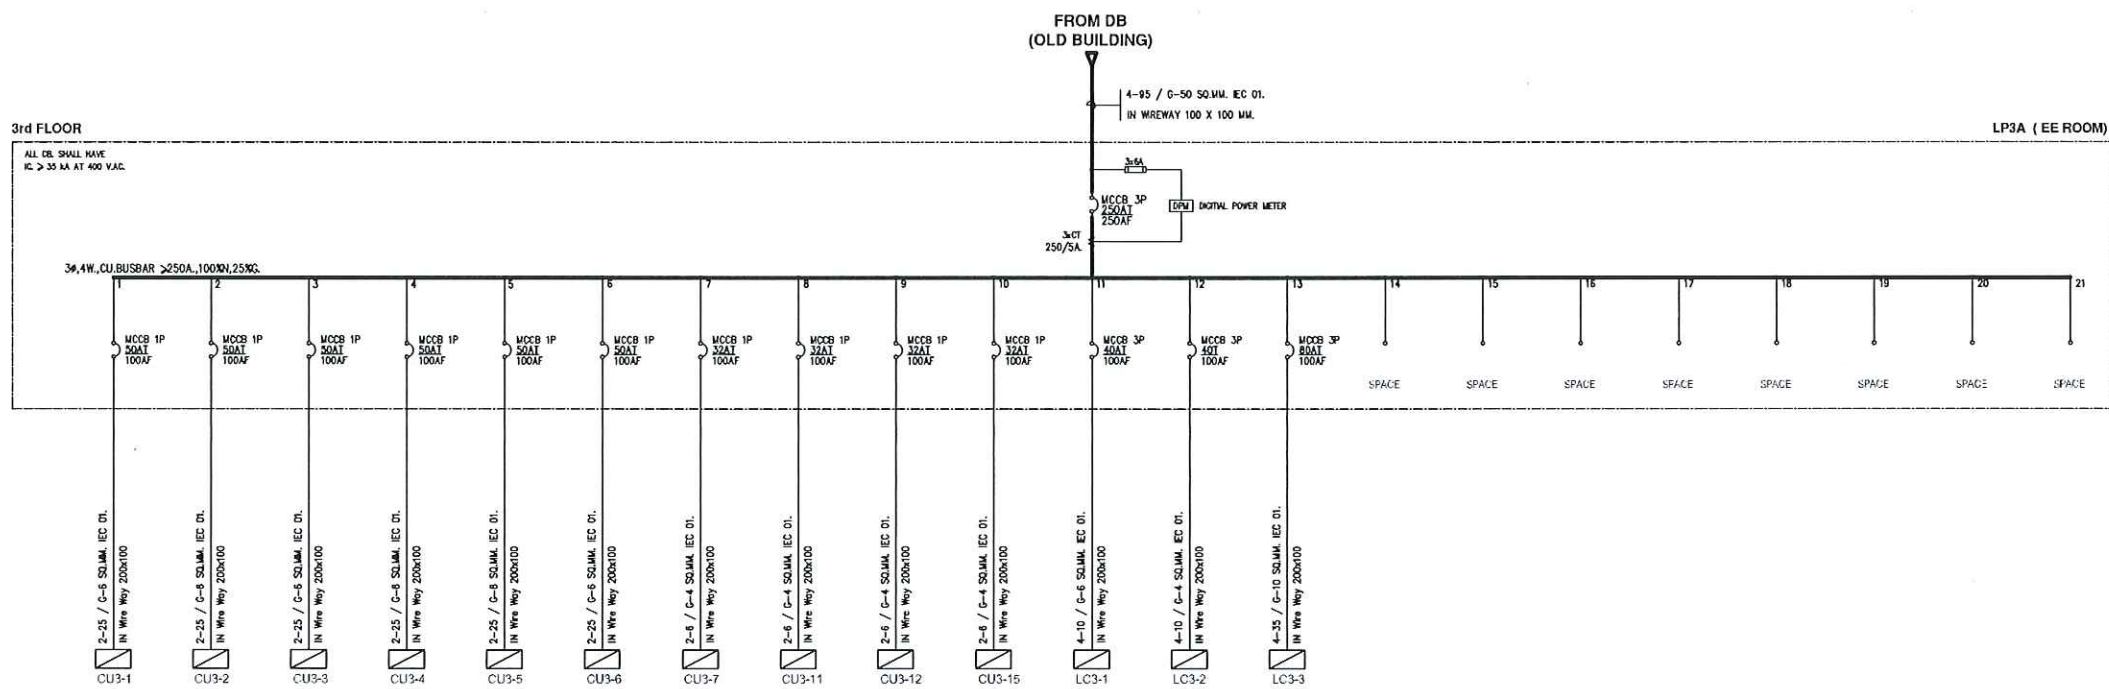

SINGLE LINE DIAGRAM LP3A

2/27 ✓ 2/28

OWNER :

CONSULTANT :



King Mongkut's Institute
of Technology Ladkrabang
Chalongkrung Road, Ladkrabang, Bangkok 10520
TEL. (+66) 2-329-8000 , FAX. (+66) 2-329-8204

CONTRACTOR :

PRELIMINARY

KEY PLAN

ENGINEER CERTIFICATION

SIGNATURE

NAME SONGKRIT TRERATPICHAN

REGISTER No. ๖๗๙ 957

REVISION

No.	DATE	BY	DESCRIPTION
1	07/20/18	-	PRELIMINARY

REVISION OF DRAWING : 0

PROJECT NAME :

Excise Department


DRAWING TITLE :

LP3 SINGLE LINE DIAGRAM

DRAWING No. :

EXD-20180720

SHEET : 1	OF : 3	SIZE : A3
DATE :	SCALE :	NTS
DRAW BY :		
CHECKED BY :		
APPROVED BY :		

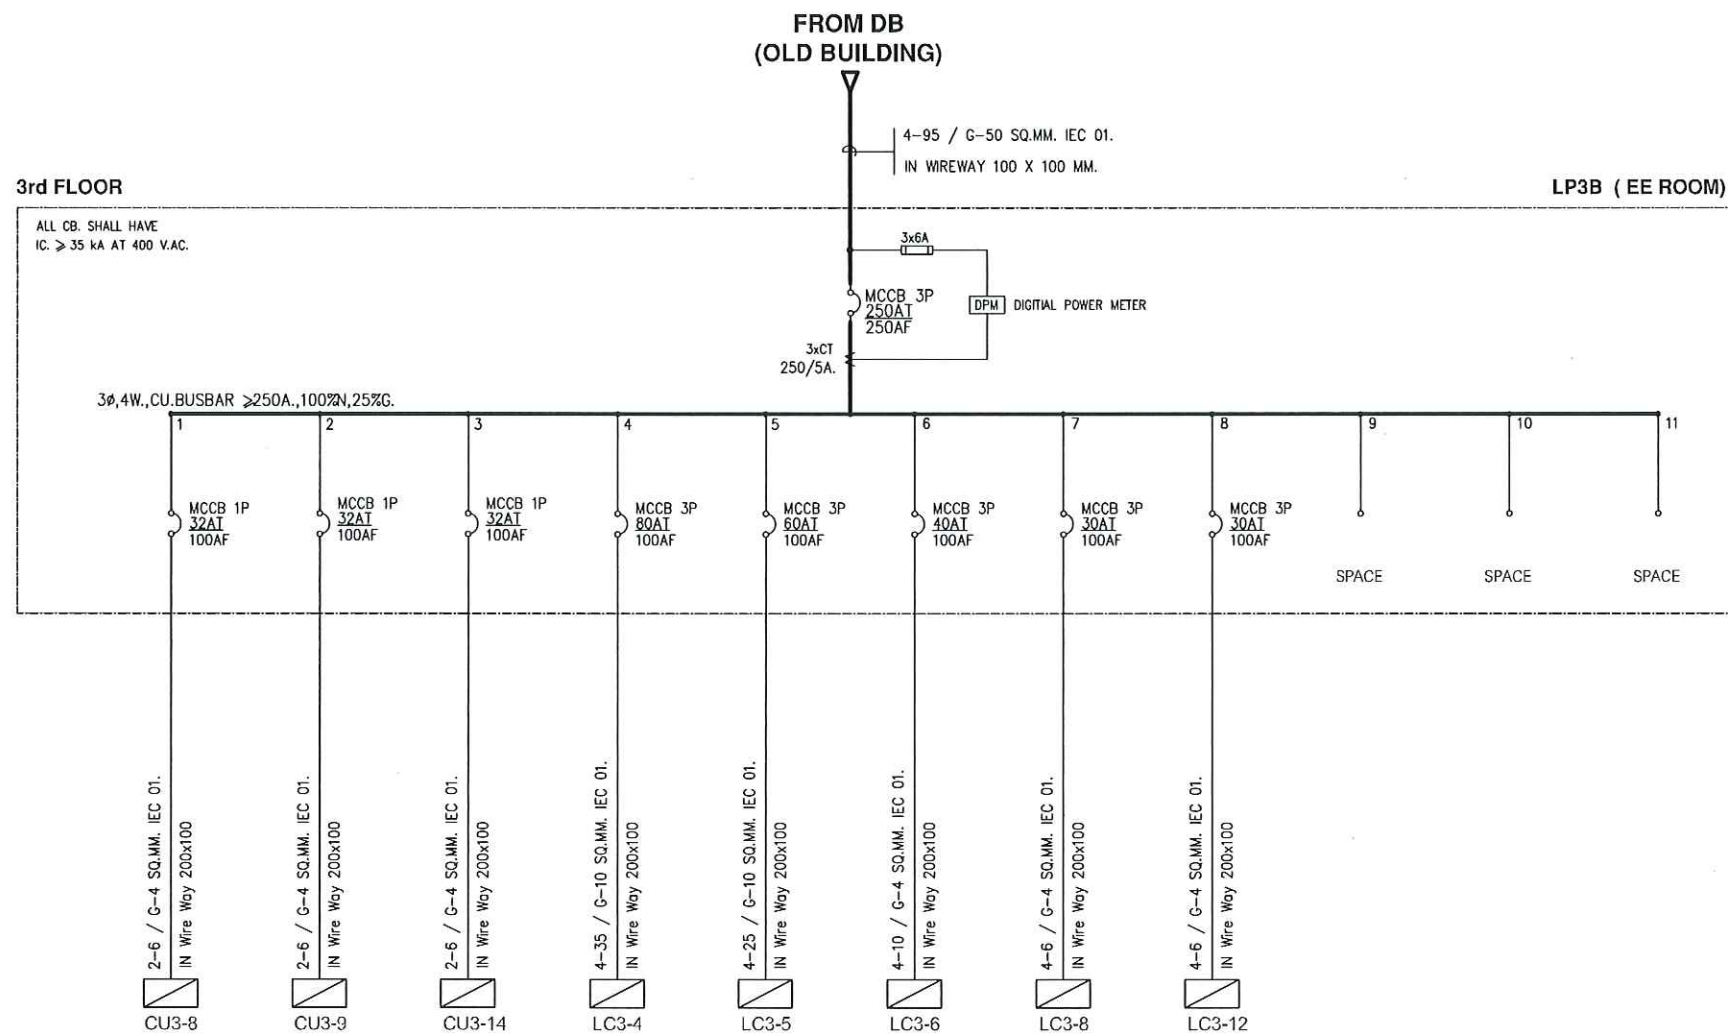

SINGLE LINE DIAGRAM LP3B

OWNER :

CONSULTANT :



King Mongkut's Institute
of Technology Ladkrabang
Chalongkrung Road, Ladkrabang, Bangkok 10520
TEL. (+66) 2-329-8000 , FAX. (+66) 2-329-8204

CONTRACTOR :

PRELIMINARY

KEY PLAN

ENGINEER CERTIFICATION

SIGNATURE	
NAME	SONGKRIT TRERATPICHAN
REGISTER No.	๖๗๙ 957

REVISION

No.	DATE	BY	DESCRIPTION
1	07/20/18	-	PRELIMINARY

REVISION OF DRAWING : 0

PROJECT NAME :

Excise Department

DRAWING TITLE :

LP3 SINGLE LINE DIAGRAM

DRAWING No. :

EXD-20180720

SHEET : 2 OF : 3 SIZE : A3

DATE : SCALE :
NTS

DRAW BY :

CHECKED BY :

APPROVED BY :