



SINGLE LINE DIAGRAM PANEL LC 1-6

[Handwritten signature] ✓ *[Handwritten signature]*

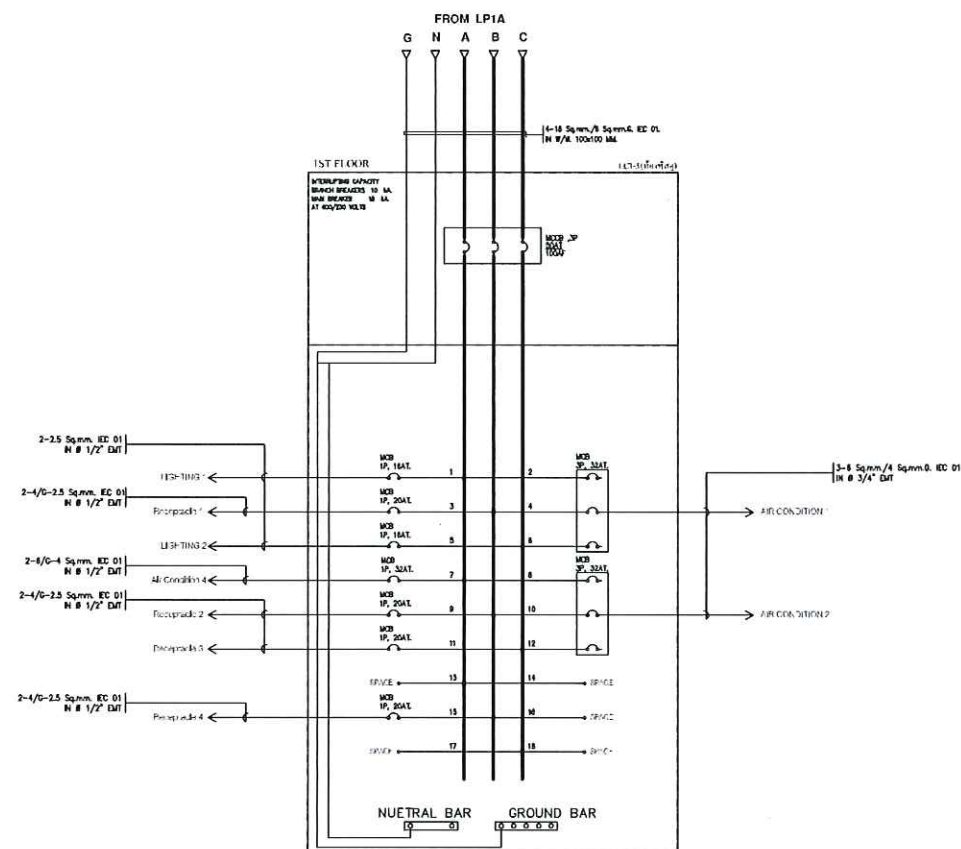

SINGLE LINE DIAGRAM PANEL LC 1-5

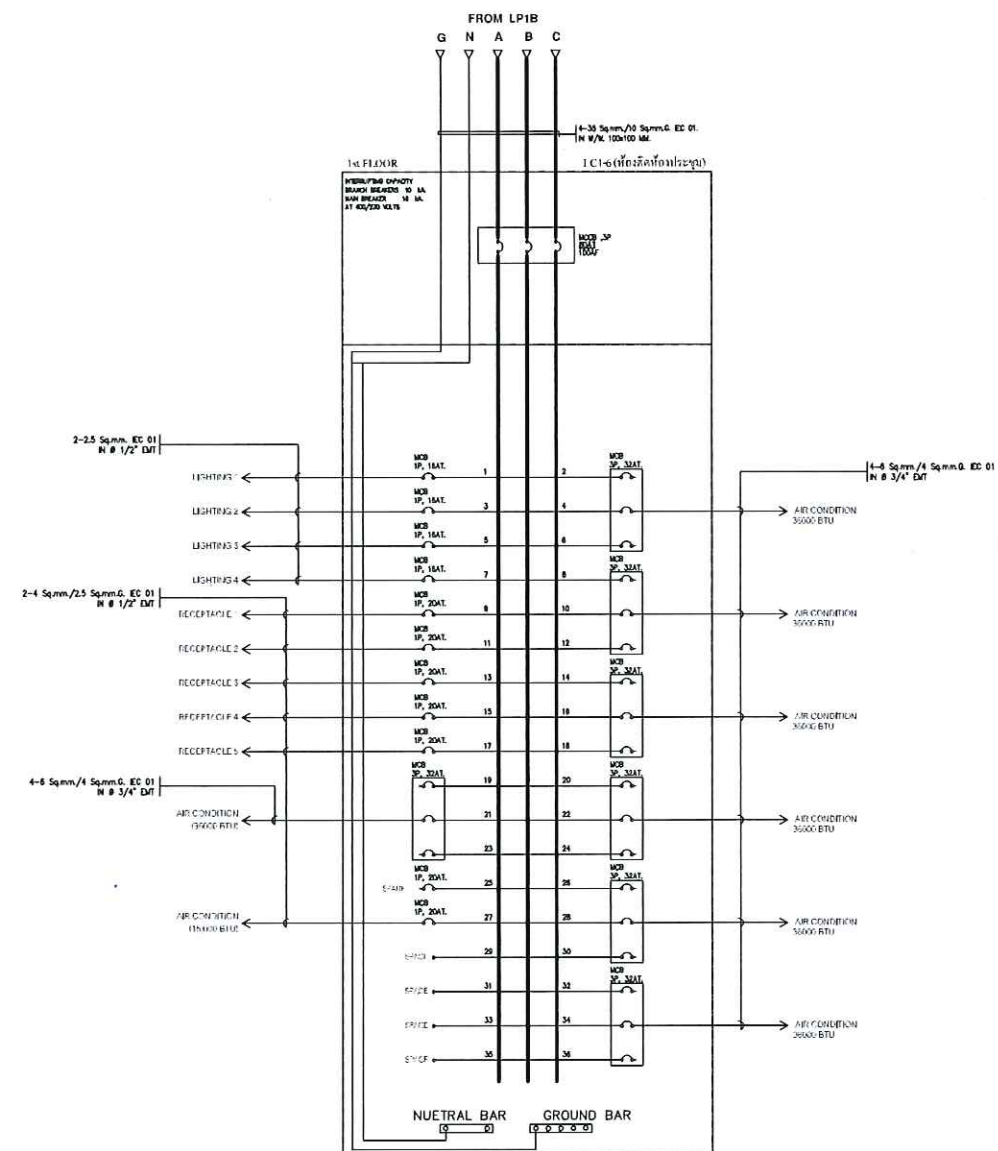

SINGLE LINE DIAGRAM PANEL LC 1-6

OWNER :

CONSULTANT :



King Mongkut's Institute
of Technology Ladkrabang
Chalongkrung Road, Ladkrabang, Bangkok 10520
TEL. (+66) 2-329-8000 , FAX. (+66) 2-329-8204

CONTRACTOR :

PRELIMINARY

KEY PLAN

ENGINEER CERTIFICATION

SIGNATURE

NAME	SONGKRIT TRERATPICHAN
------	-----------------------

REGISTER No.	၁၇၇ ၉၅၇
--------------	---------

REVISION

No.	DATE	BY	DESCRIPTION
-----	------	----	-------------

--	--	--	--

07/20/18	-	PRELIMINARY
----------	---	-------------

REVISION OF DRAWING : 0

PROJECT NAME :

Excise Department

DRAWING TITLE :

DIAGRAM LC 1-5 & LC 1-6

DRAWING No. :

EXD-20180720

SHEET : 1	OF : 1	SIZE : A3
-----------	--------	-----------

DATE :	SCALE :
--------	---------

	NTS
--	-----

DRAW BY : _____


CHECKED BY :

APPROVED BY : _____

2ND FLOOR

CU 2-02 (ห้องประชุม 2.2)

CB 1C
ICS $\geq$ 10 kA.
AT 400 VAC

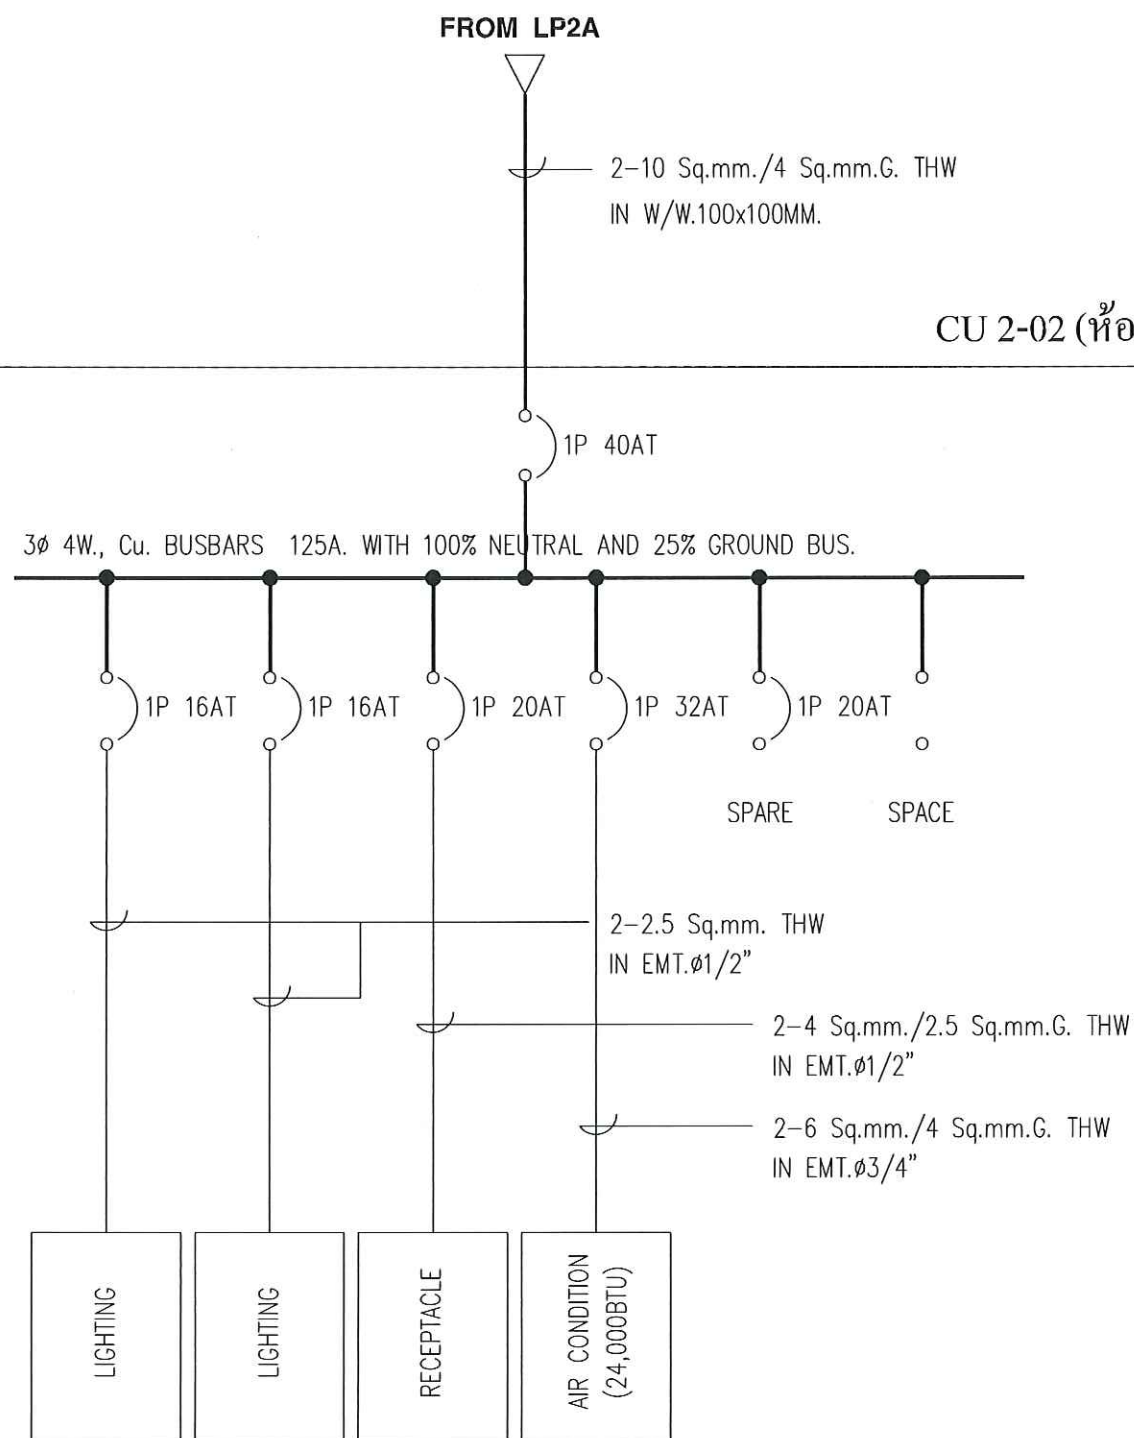

OWNER :

CONSULTANT :



King Mongkut's Institute
of Technology Ladkrabang
Chalongkrung Road, Ladkrabang, Bangkok 10520
TEL. (+66) 2-329-8000 , FAX. (+66) 2-329-8204

CONTRACTOR :

PRELIMINARY

KEY PLAN

ENGINEER CERTIFICATION

SIGNATURE	
NAME	SONGKRIT TRERATPICHAN
REGISTER No.	วพ. 957

REVISION

No.	DATE	BY	DESCRIPTION
1	07/20/18	-	PRELIMINARY

REVISION OF DRAWING : 0

PROJECT NAME :

Excise Department

DRAWING TITLE :

CU 2_SINGLE LINE DIAGRAM

DRAWING No. :

EXD-20180720

SHEET : 2 OF : 12 SIZE : A3


DATE : SCALE :

NTS

DRAW BY :

CHECKED BY :

APPROVED BY :

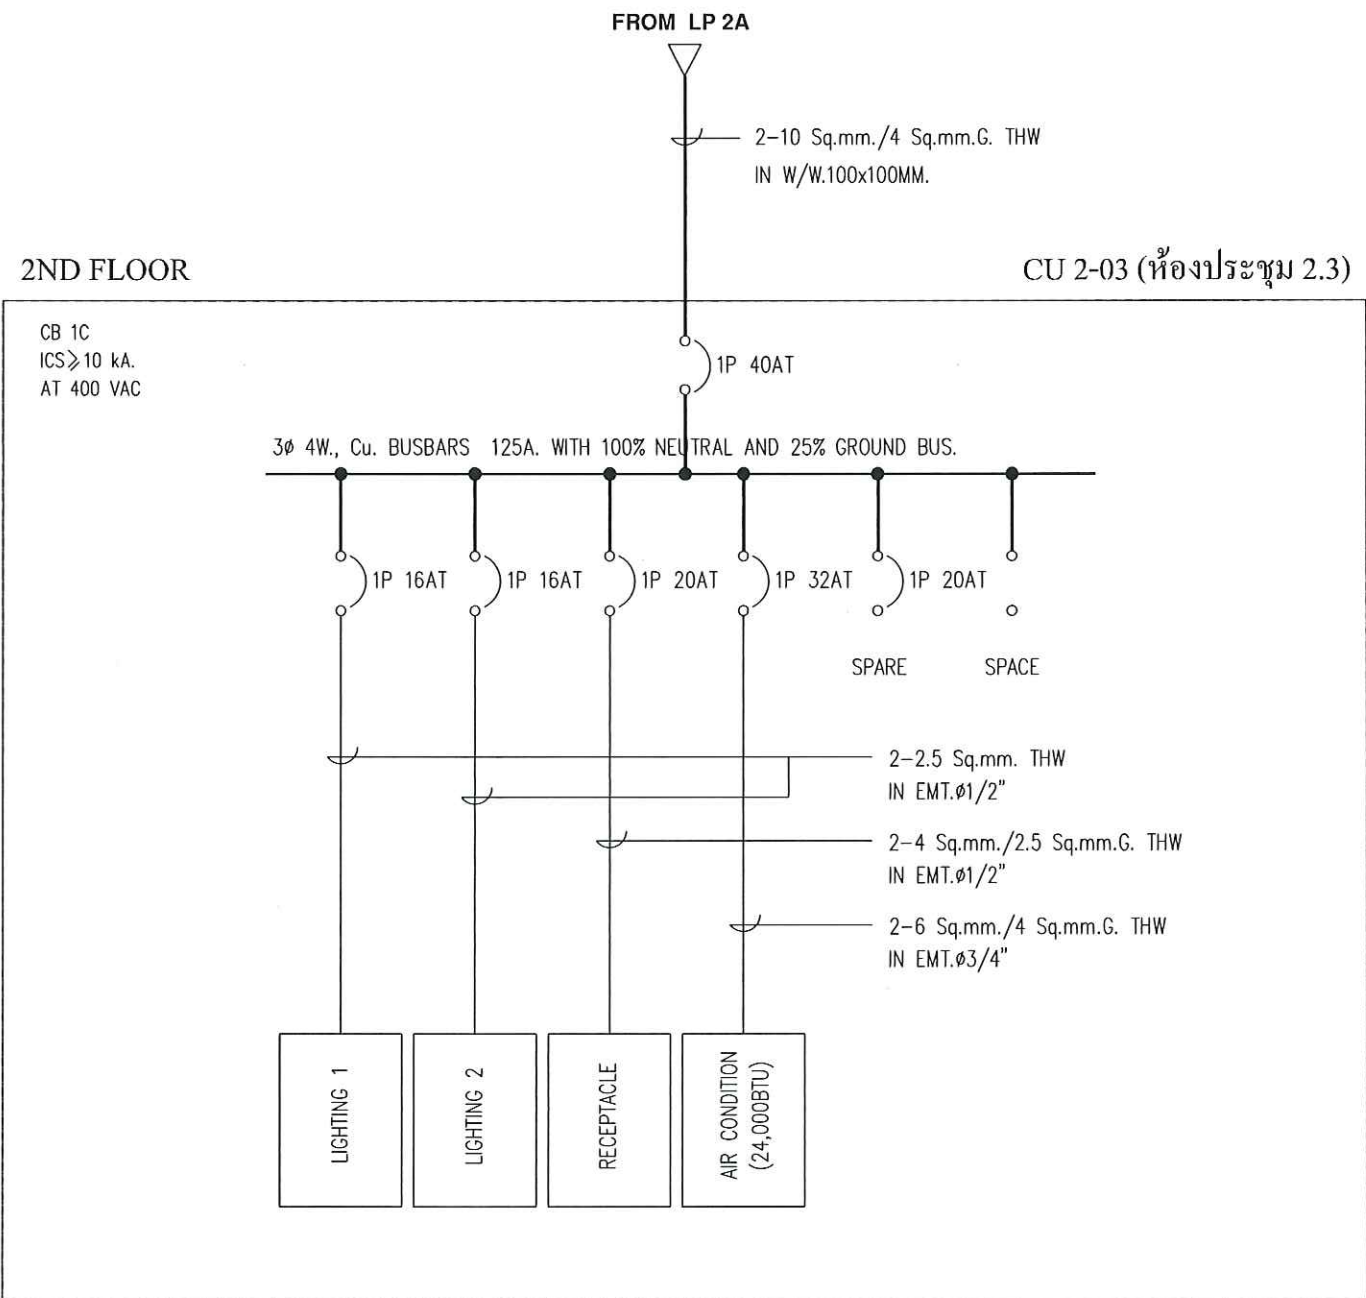

OWNER :

CONSULTANT :



King Mongkut's Institute
of Technology Ladkrabang
Chalongkrung Road, Ladkrabang, Bangkok 10520
TEL. (+66) 2-329-8000 , FAX. (+66) 2-329-8204

CONTRACTOR :

PRELIMINARY

KEY PLAN

ENGINEER CERTIFICATION

SIGNATURE

NAME SONGKRIT TRERATPICHAN

REGISTER No. ๖๗๙ 957

REVISION

No.	DATE	BY	DESCRIPTION
1	07/20/18	-	PRELIMINARY

REVISION OF DRAWING : 0

PROJECT NAME :

Excise Department

DRAWING TITLE :

CU 2_SINGLE LINE DIAGRAM

DRAWING No. :

EXD-20180720


SHEET : 3 OF : 12 SIZE : A3

DATE : SCALE : NTS

DRAW BY :

CHECKED BY :

APPROVED BY :

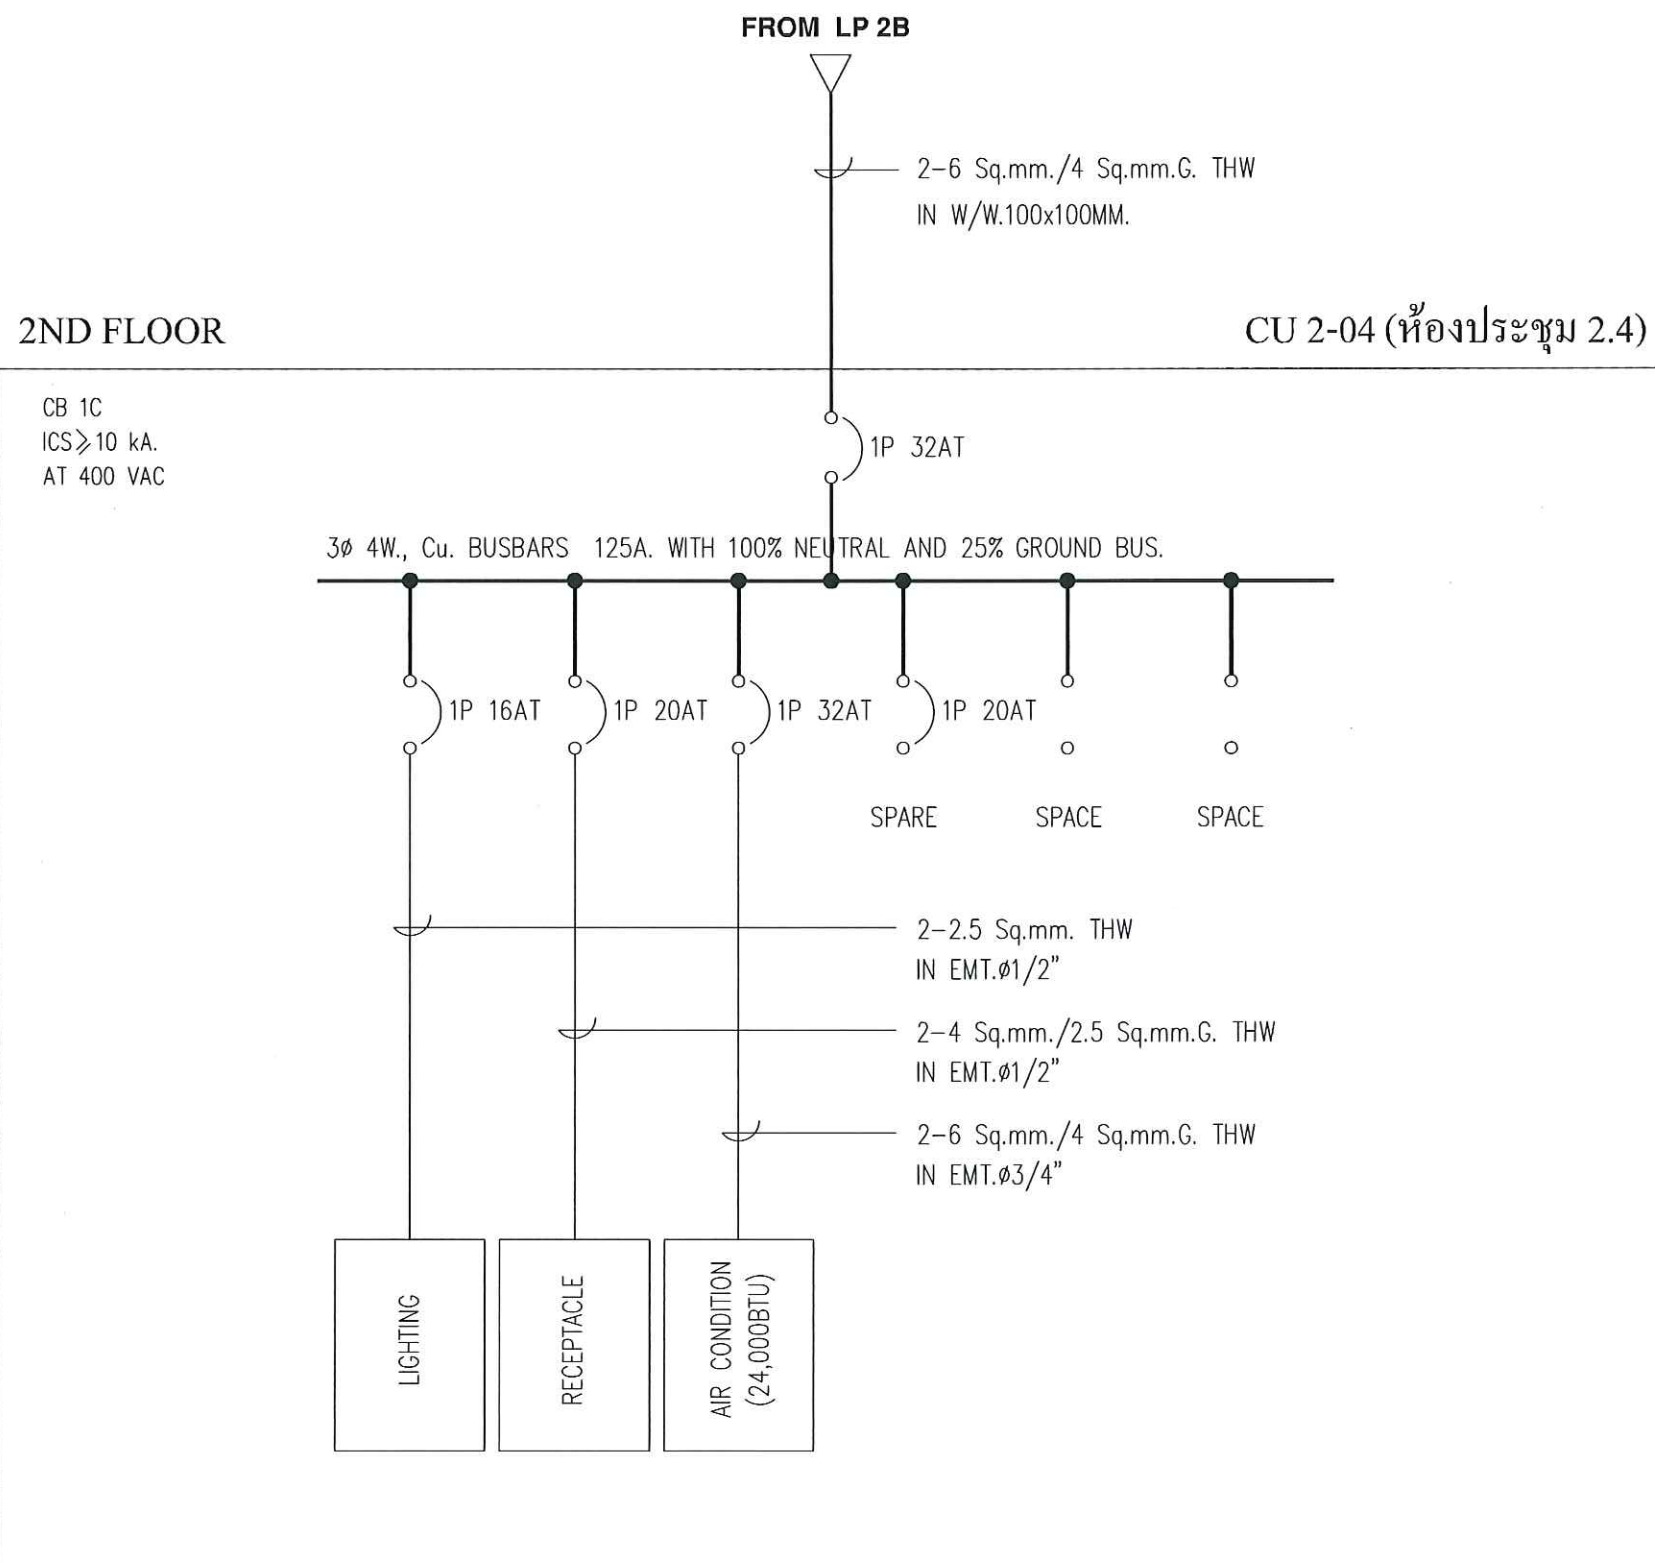

OWNER :

CONSULTANT :



King Mongkut's Institute
of Technology Ladkrabang
Chalongkrung Road, Ladkrabang, Bangkok 10520
TEL. (+66) 2-329-8000 , FAX. (+66) 2-329-8204

CONTRACTOR :

PRELIMINARY

KEY PLAN

ENGINEER CERTIFICATION

SIGNATURE	
NAME	SONGKRIT TRERATPICHAN
REGISTER No.	วพท 957

REVISION				
No.	DATE	BY	DESCRIPTION	
1	07/20/18	-	PRELIMINARY	

REVISION OF DRAWING : 0

PROJECT NAME :

Excise Department

DRAWING TITLE :


CU 2_SINGLE LINE DIAGRAM

DRAWING No. :

EXD-20180720

SHEET : 4	OF : 12	SIZE : A3
DATE :	SCALE :	NTS
DRAW BY :		
CHECKED BY :		
APPROVED BY :		

2ND FLOOR

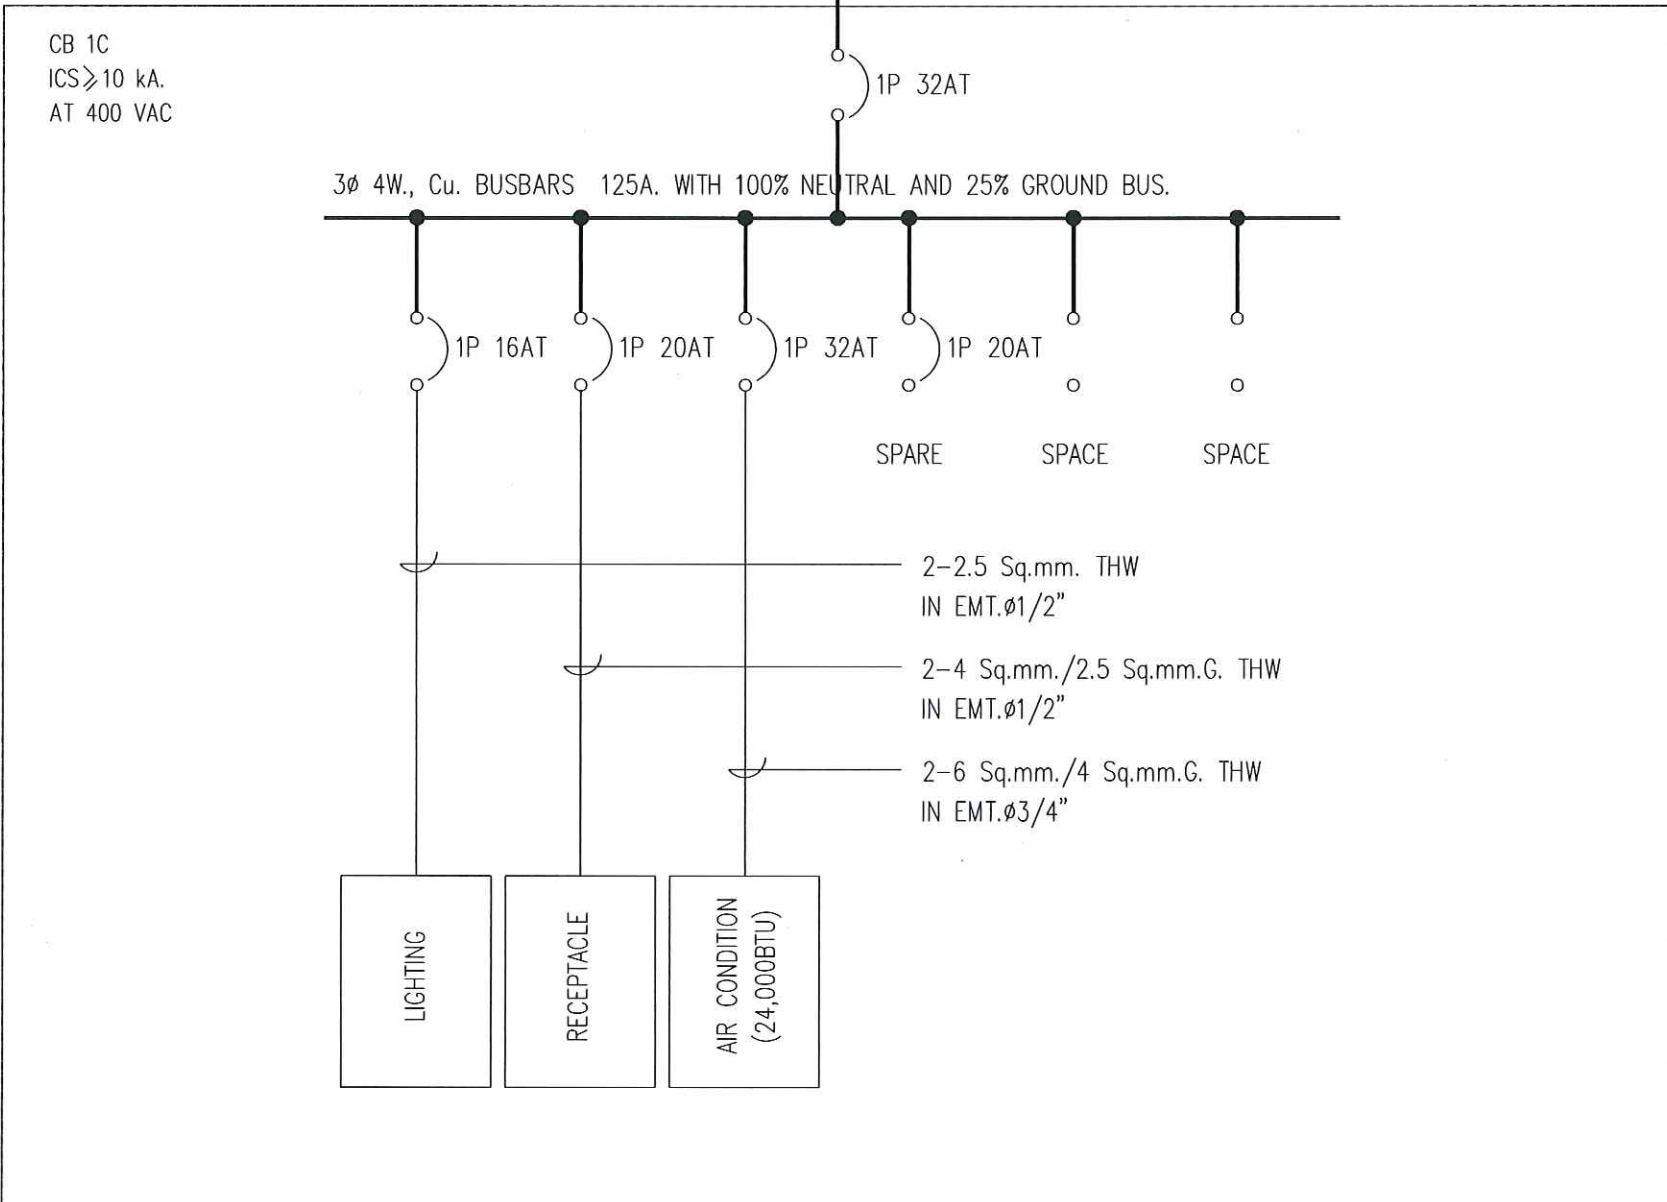

Handwritten signature and initials in blue ink.

OWNER :

CONSULTANT :

King Mongkut's Institute of Technology Ladkrabang
Chalongkrung Road, Ladkrabang, Bangkok 10520
TEL (+66) 2-329-8000 , FAX (+66) 2-329-8204

CONTRACTOR :

PRELIMINARY

KEY PLAN

ENGINEER CERTIFICATION

SIGNATURE 

NAME SONGKRIT TRERATPICHAN

REGISTER No. ๖๗๙ ๙๕๗

REVISION

No.	DATE	BY	DESCRIPTION
1	07/20/18	-	PRELIMINARY

REVISION OF DRAWING : 0

PROJECT NAME :
Excise Department

DRAWING TITLE :
CU 2_SINGLE LINE DIAGRAM

DRAWING No. :
EXD-20180720

SHEET : 5	OF : 12	SIZE : A3
DATE :	SCALE : NTS	
DRAW BY :		
CHECKED BY :		
APPROVED BY :		

APPROVED BY :



2ND FLOOR


CB 1C
ICS $\geq$ 10 kA.
AT 400 VAC

FROM LP 2A-XX

2-6 Sq.mm./4 Sq.mm.G. THW
IN W/W.100x100MM.

CU 2-07 (ห้องประชุม 2.7)

3 ϕ 4W., Cu. BUSBARS 125A. WITH 100% NEUTRAL AND 25% GROUND BUS.

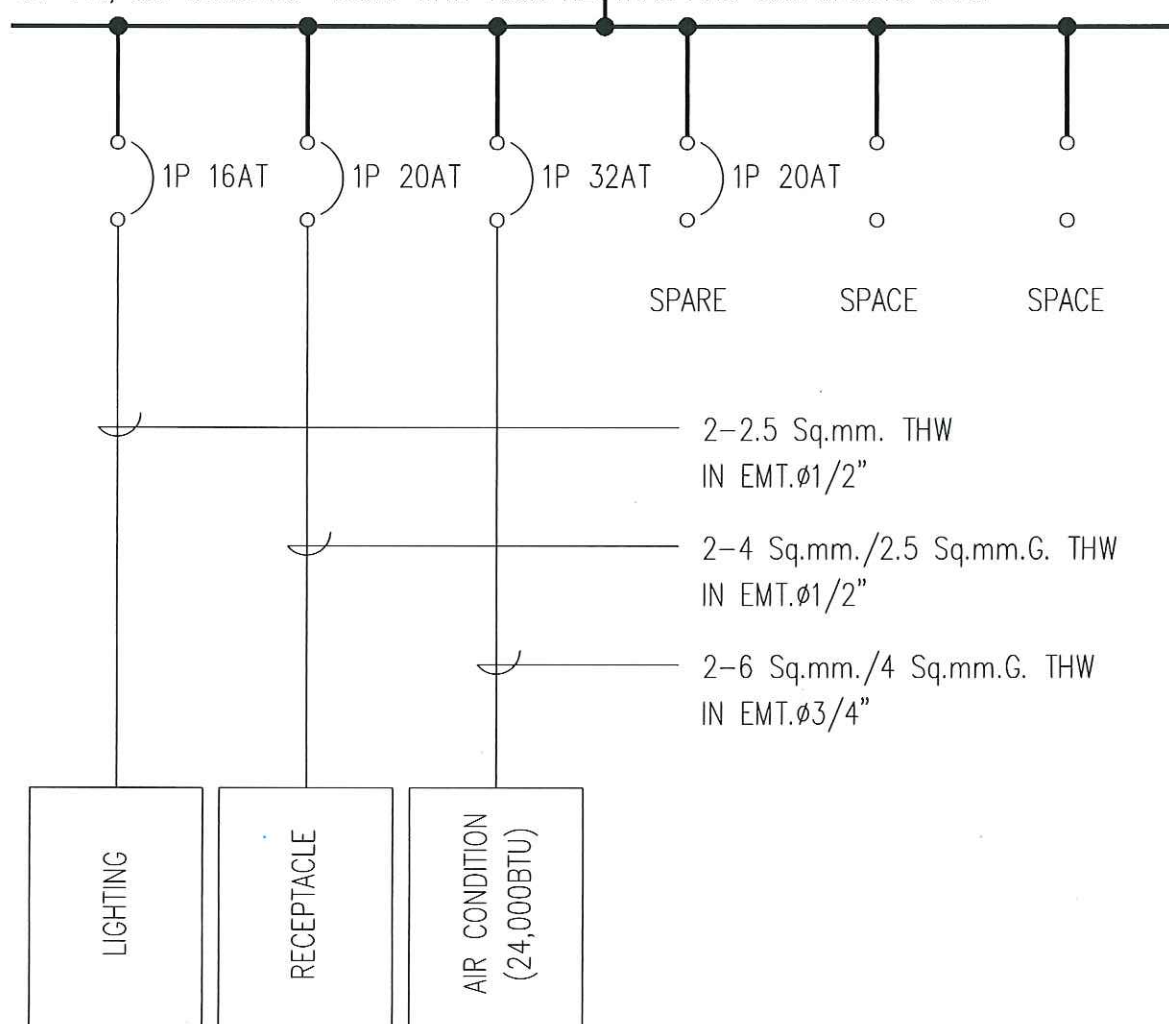

OWNER :

CONSULTANT :



King Mongkut's Institute
of Technology Ladkrabang
Chalongkrung Road, Ladkrabang, Bangkok 10520
TEL. (+66) 2-329-8000 , FAX. (+66) 2-329-8204

CONTRACTOR :

PRELIMINARY

KEY PLAN

ENGINEER CERTIFICATION

SIGNATURE	
NAME	SONGKRIT TRERATPICHAN
REGISTER No.	วพ. 957

REVISION

No.	DATE	BY	DESCRIPTION
1	07/20/18	-	PRELIMINARY

REVISION OF DRAWING : 0

PROJECT NAME :

Excise Department

DRAWING TITLE :

CU 2_SINGLE LINE DIAGRAM

DRAWING No. :

EXD-20180720

SHEET : 7 OF : 12 SIZE : A3

DATE : SCALE :

NTS

DRAW BY :

CHECKED BY :

APPROVED BY :

FROM LP 2A-XX


2-6 Sq.mm./4 Sq.mm.G. THW
IN W/W.100x100MM.

2ND FLOOR

CU 2-08 (ห้องประชุม 2.8)

CB 1C
ICS $\geq$ 10 kA.
AT 400 VAC

3 ϕ 4W., Cu. BUSBARS 125A. WITH 100% NEUTRAL AND 25% GROUND BUS.

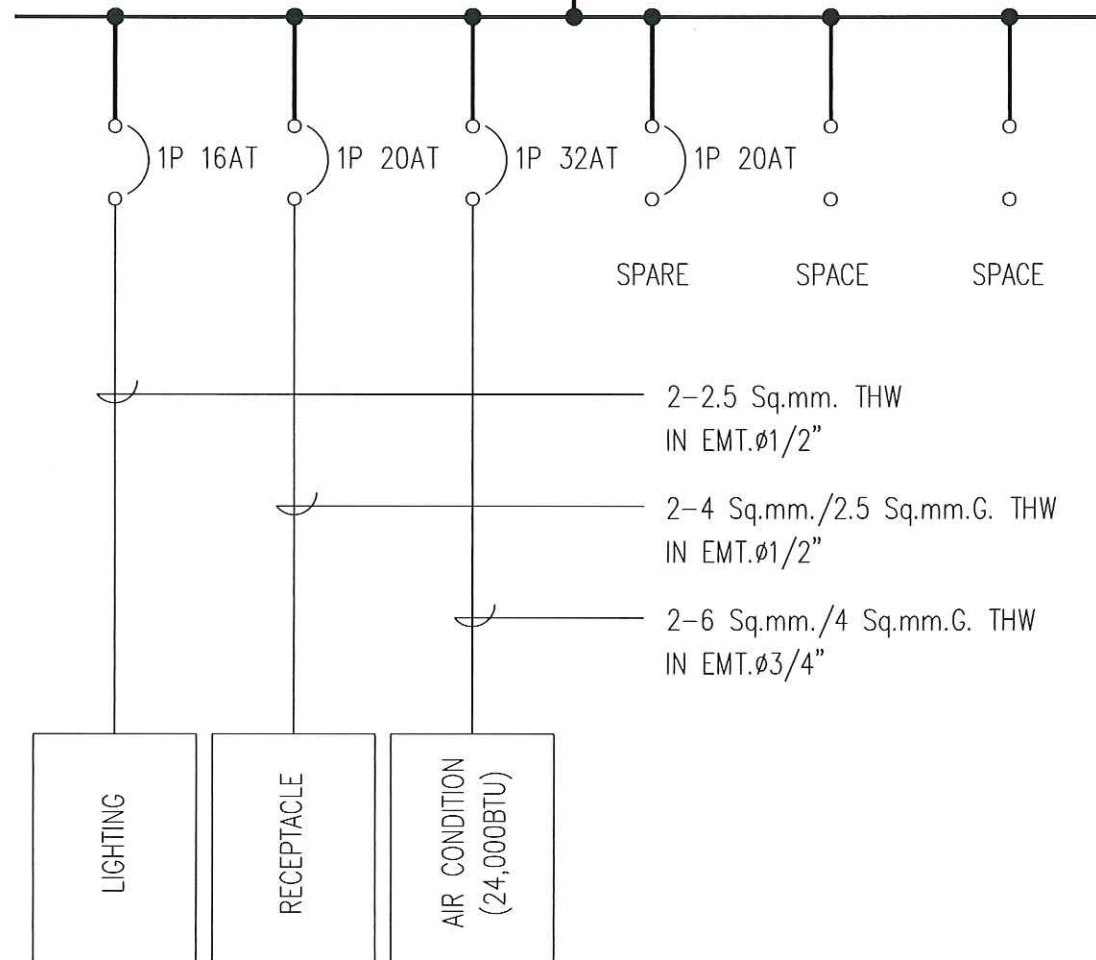

OWNER :

CONSULTANT :



King Mongkut's Institute
of Technology Ladkrabang
Chalongkrung Road, Ladkrabang, Bangkok 10520
TEL. (+66) 2-329-8000 , FAX (+66) 2-329-8204

CONTRACTOR :

PRELIMINARY

KEY PLAN

ENGINEER CERTIFICATION

SIGNATURE	
NAME	SONGKRIT TRERATPICHAN
REGISTER No.	วพ. 957

REVISION

No.	DATE	BY	DESCRIPTION
1	07/20/18	-	PRELIMINARY

REVISION OF DRAWING : 0

PROJECT NAME :

Excise Department

DRAWING TITLE :

CU 2_SINGLE LINE DIAGRAM

DRAWING No. :

EXD-20180720

SHEET : 8 OF : 12 SIZE : A3

DATE : SCALE :
NTS

DRAW BY :


CHECKED BY :

APPROVED BY :

2ND FLOOR

CU 2-09 (ห้องประชุม 2.9)

CB 1C
ICS $\geq$ 10 kA.
AT 400 VAC

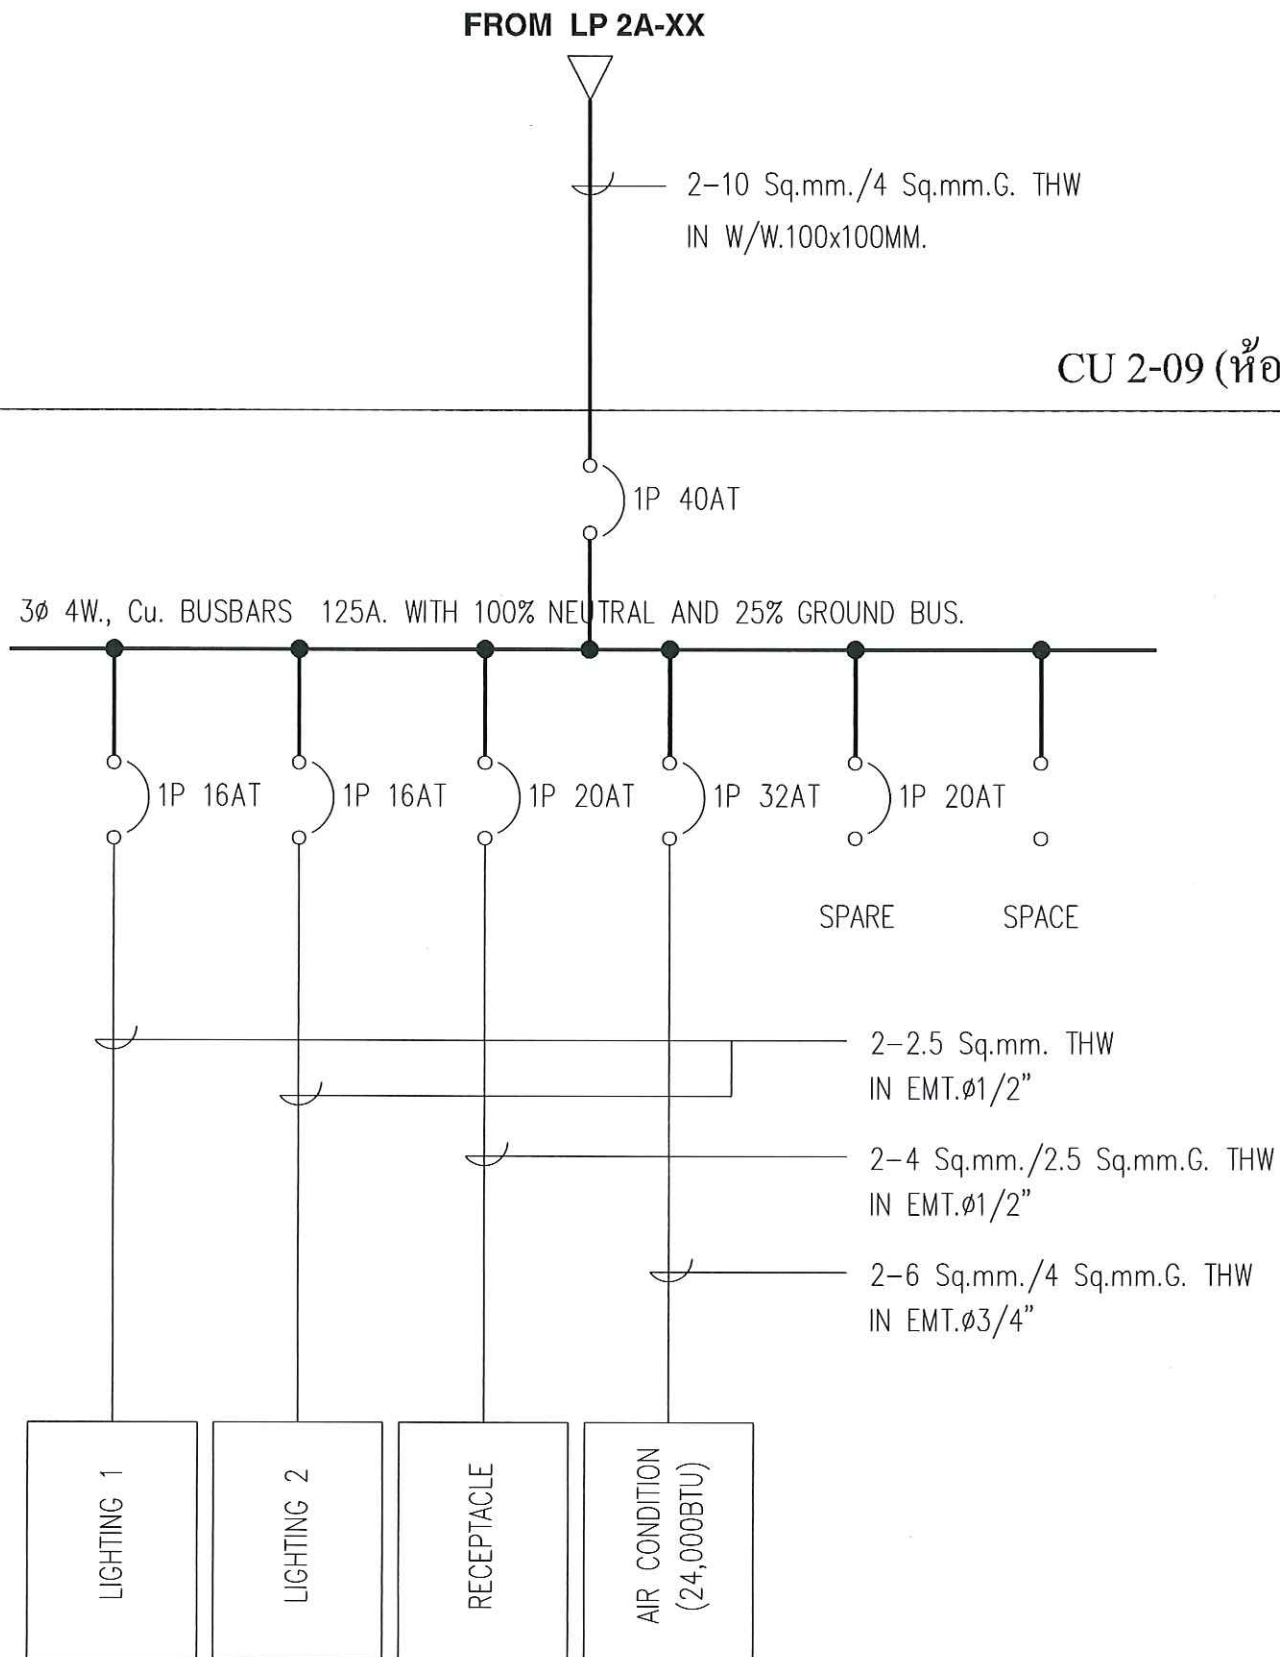

OWNER :

CONSULTANT :



King Mongkut's Institute
of Technology Ladkrabang
Chalongkrung Road, Ladkrabang, Bangkok 10520
TEL. (+66) 2-329-8000 , FAX. (+66) 2-329-8204

CONTRACTOR :

PRELIMINARY

KEY PLAN

ENGINEER CERTIFICATION

SIGNATURE

NAME SONGKRIT TRERATPICHAN

REGISTER No. ๖๗๙ ๙๕๗

REVISION

No.	DATE	BY	DESCRIPTION
1	07/20/18	-	PRELIMINARY

REVISION OF DRAWING : 0

PROJECT NAME :

Excise Department

DRAWING TITLE :

CU 2_SINGLE LINE DIAGRAM

DRAWING No. :

EXD-20180720

SHEET : 9 OF : 12 SIZE : A3

DATE : SCALE :
NTS

DRAW BY :


CHECKED BY :

APPROVED BY :

2ND FLOOR

CU 2-10 (ห้อง ข.1)

CB 1C
ICS ≥ 10 kA.
AT 400 VAC

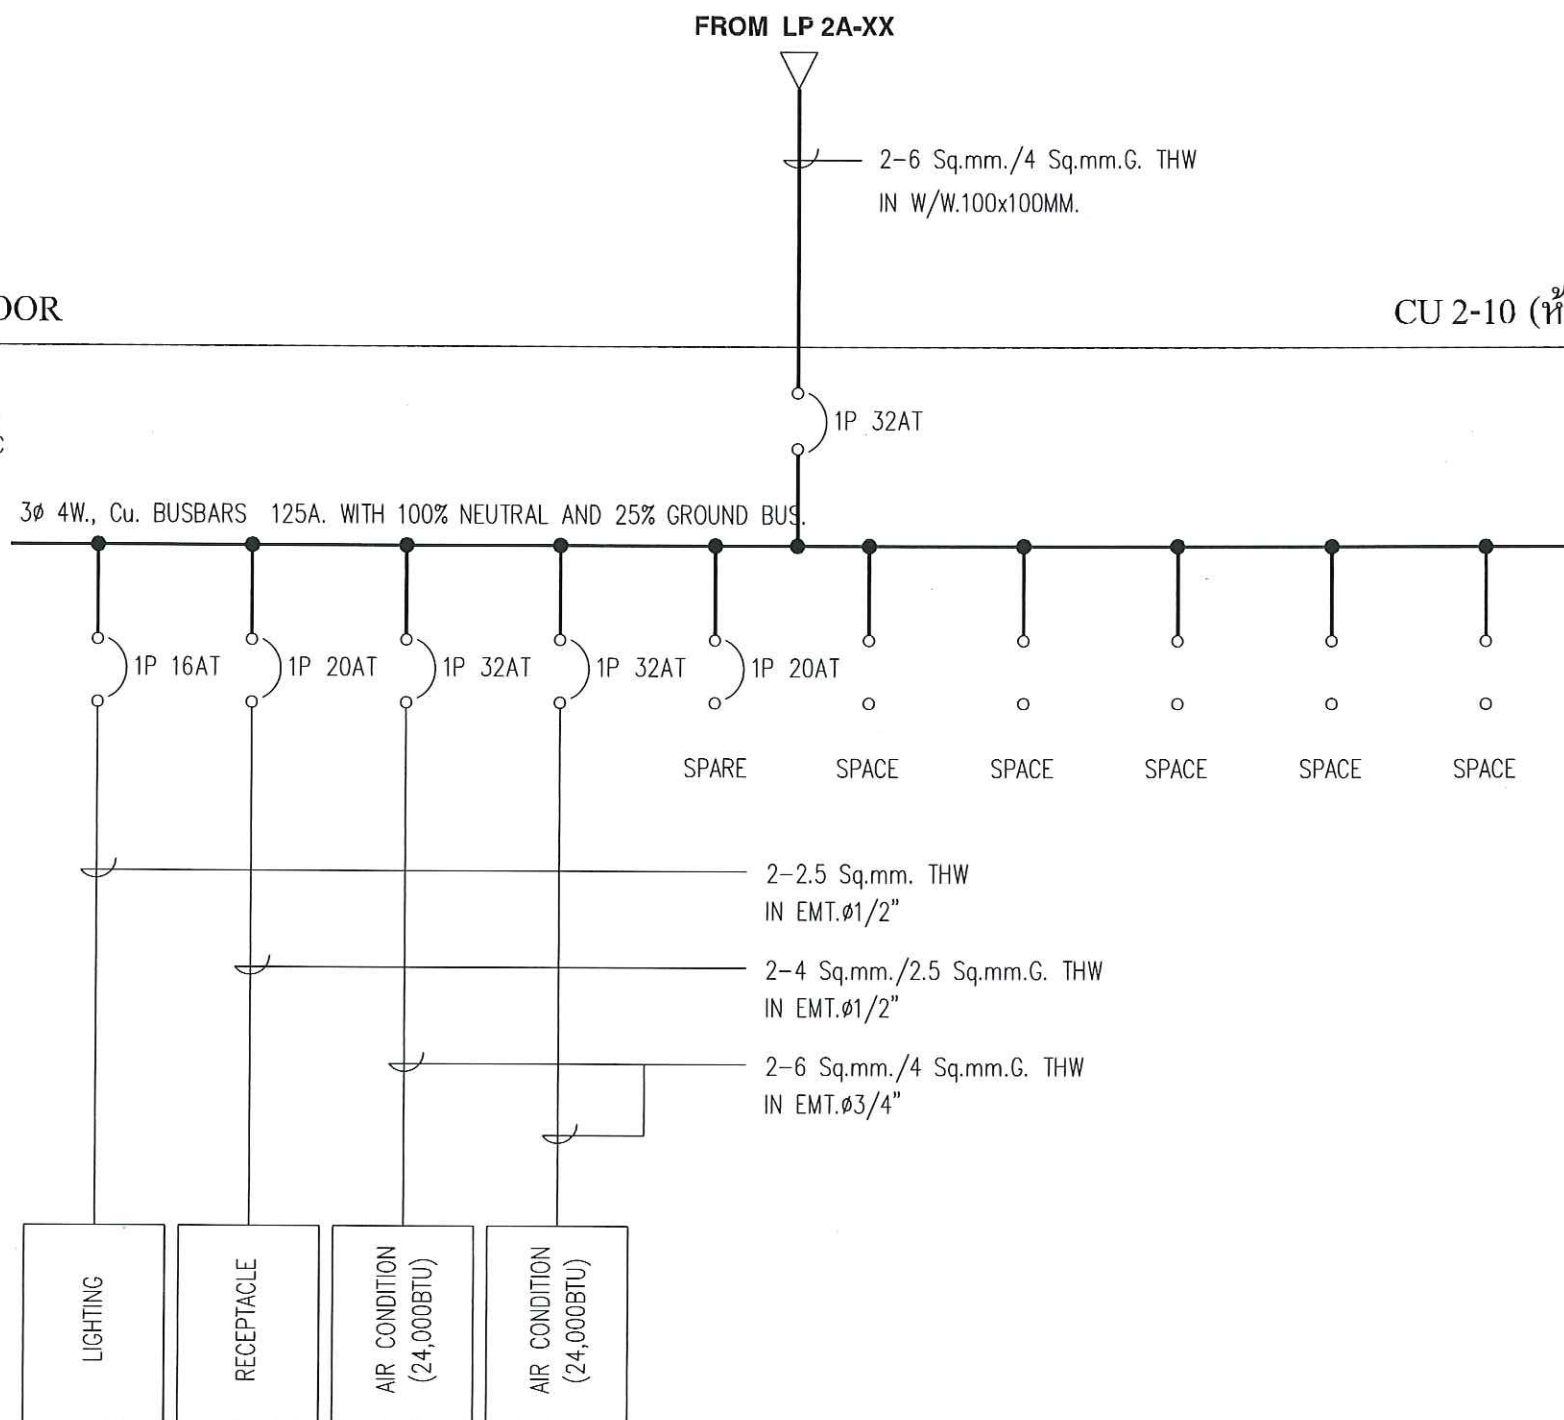

OWNER :

CONSULTANT :



King Mongkut's Institute
of Technology Ladkrabang
Chalongkrung Road, Ladkrabang, Bangkok 10520
TEL. (+66) 2-329-8000 , FAX. (+66) 2-329-8204

CONTRACTOR :

PRELIMINARY

KEY PLAN

ENGINEER CERTIFICATION

SIGNATURE	
NAME	SONGKRIT TRERAPICHAN
REGISTER No.	จพท 957

REVISION

No.	DATE	BY	DESCRIPTION
1	07/20/18	-	PRELIMINARY

REVISION OF DRAWING : 0

PROJECT NAME :

Excise Department

DRAWING TITLE :

CU 2_SINGLE LINE DIAGRAM

DRAWING No. :

EXD-20180720

SHEET : 10 OF : 12 SIZE : A3

DATE : SCALE :
NTS

DRAW BY :


CHECKED BY :

APPROVED BY :

2ND FLOOR

CU 2-11 (ห้อง ขข.2)

CB 1C
ICS $\geq$ 10 kA.
AT 400 VAC

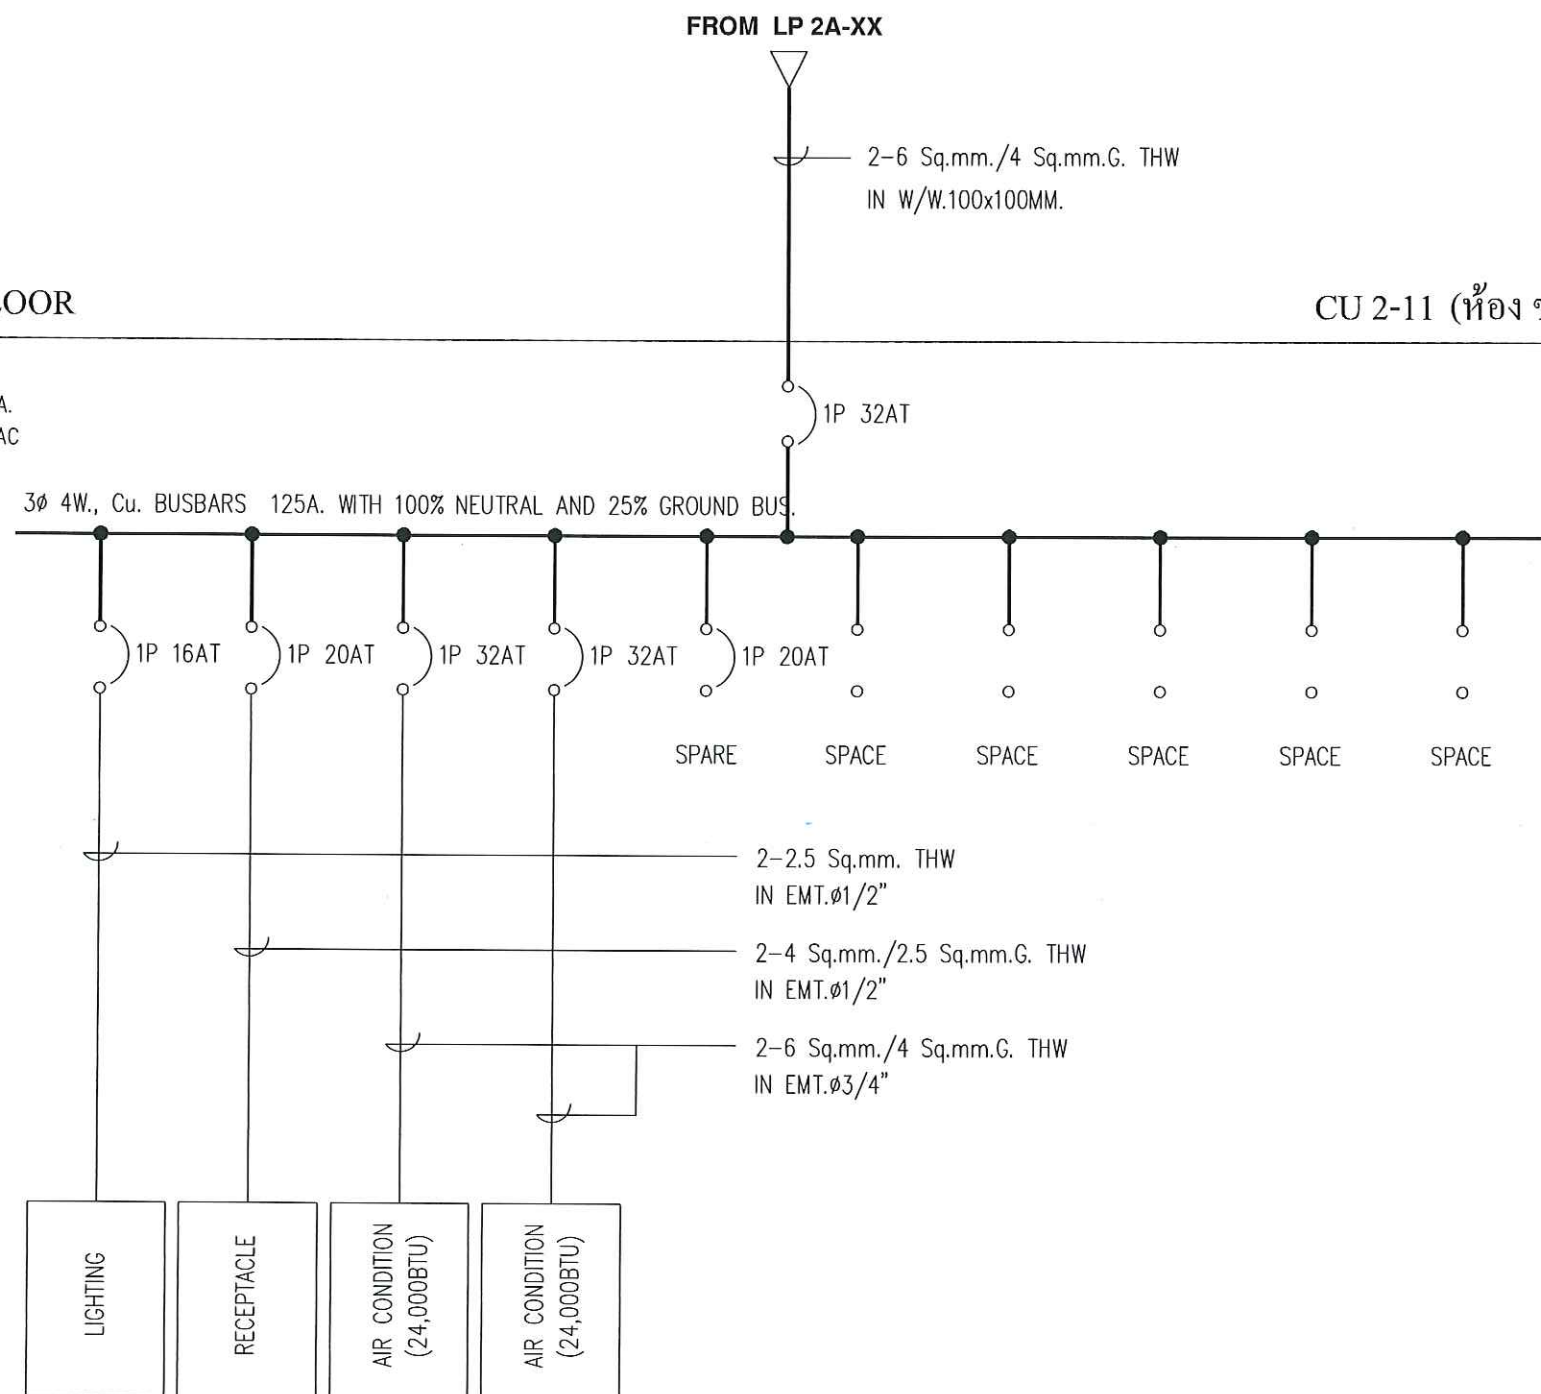

OWNER :

CONSULTANT :



King Mongkut's Institute
of Technology Ladkrabang
Chalongkrung Road, Ladkrabang, Bangkok 10520
TEL (+66) 2-320-8000 , FAX (+66) 2-320-8204

CONTRACTOR :

PRELIMINARY

KEY PLAN

ENGINEER CERTIFICATION

SIGNATURE	
NAME	SONGKRIT TRERATPICHAN
REGISTER No.	จพท 957

REVISION

No.	DATE	BY	DESCRIPTION
1	07/20/18	-	PRELIMINARY

REVISION OF DRAWING : 0

PROJECT NAME :

Excise Department

DRAWING TITLE :

CU 2_SINGLE LINE DIAGRAM

DRAWING No. :


EXD-20180720

SHEET : 11	OF : 12	SIZE : A3
DATE :	SCALE :	NTS

DRAW BY :

CHECKED BY :

APPROVED BY :

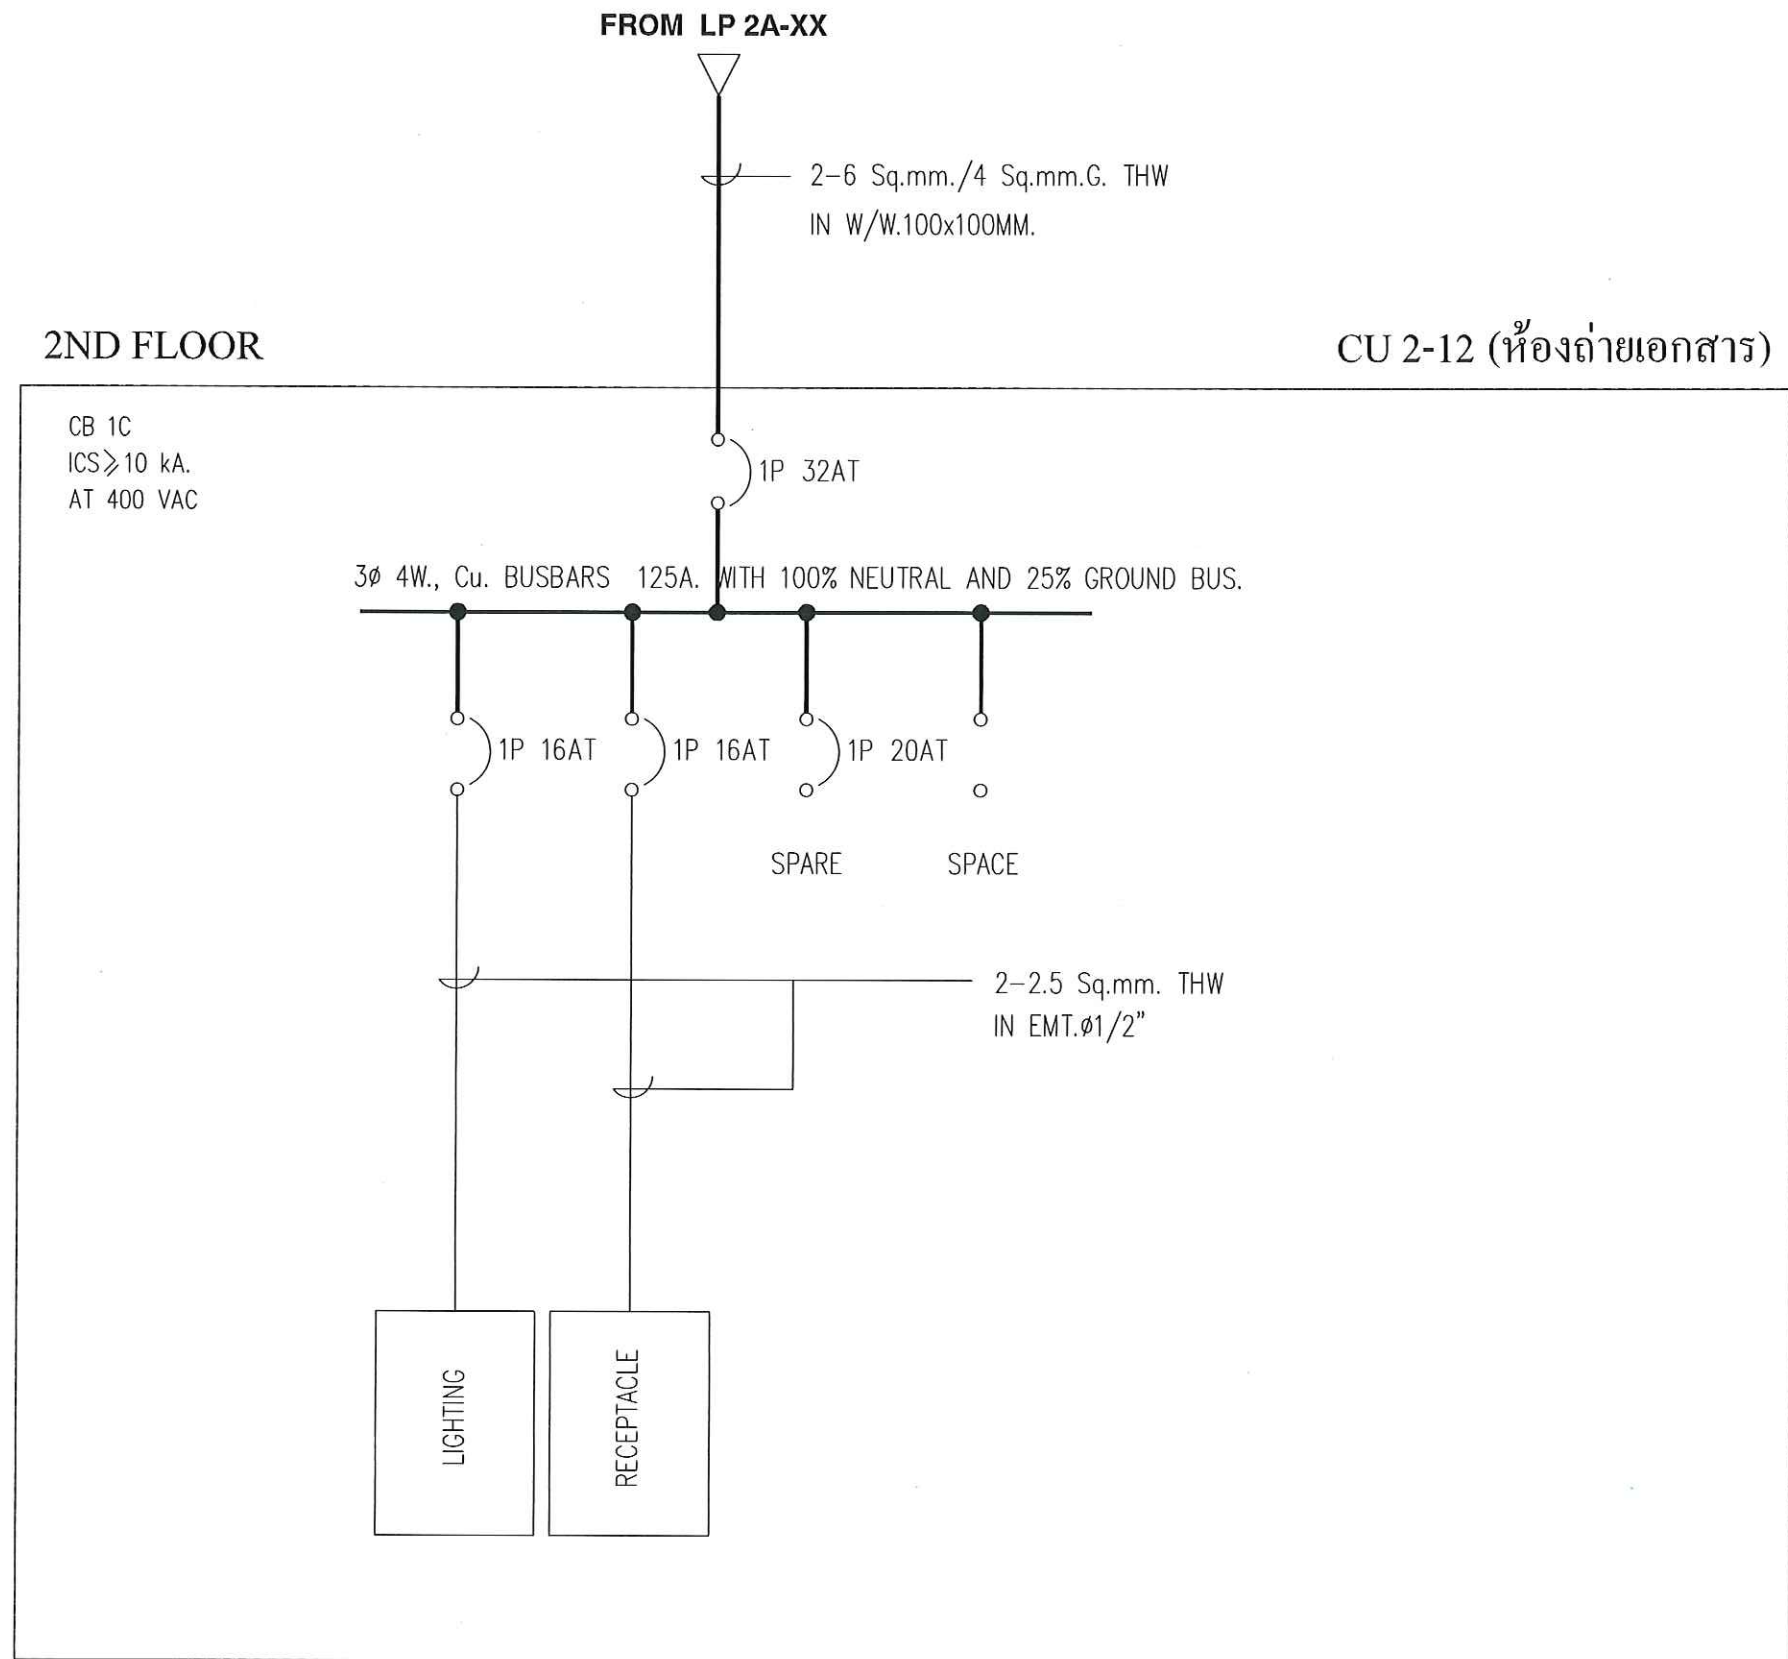

OWNER :		
CONSULTANT :		
 King Mongkut's Institute of Technology Ladkrabang Chalongkrung Road, Ladkrabang, Bangkok 10520 TEL. (+66) 2-329-8000 , FAX (+66) 2-329-8204		
CONTRACTOR :		
PRELIMINARY		
KEY PLAN		
ENGINEER CERTIFICATION		
SIGNATURE		
NAME	SONGKRIT TRERATPICHAN	
REGISTER No.	วพค 957	
REVISION		
No.	DATE	BY
1	07/20/18	-
PRELIMINARY		
REVISION OF DRAWING : 0		
PROJECT NAME :		
Excise Department		
DRAWING TITLE :		
CU 2_SINGLE LINE DIAGRAM		
DRAWING No. :		
EXD-20180720		
SHEET : 12	OF : 12	SIZE : A3
DATE :	SCALE :	
	NTS	
DRAW BY :		
CHECKED BY :		
APPROVED BY :		