



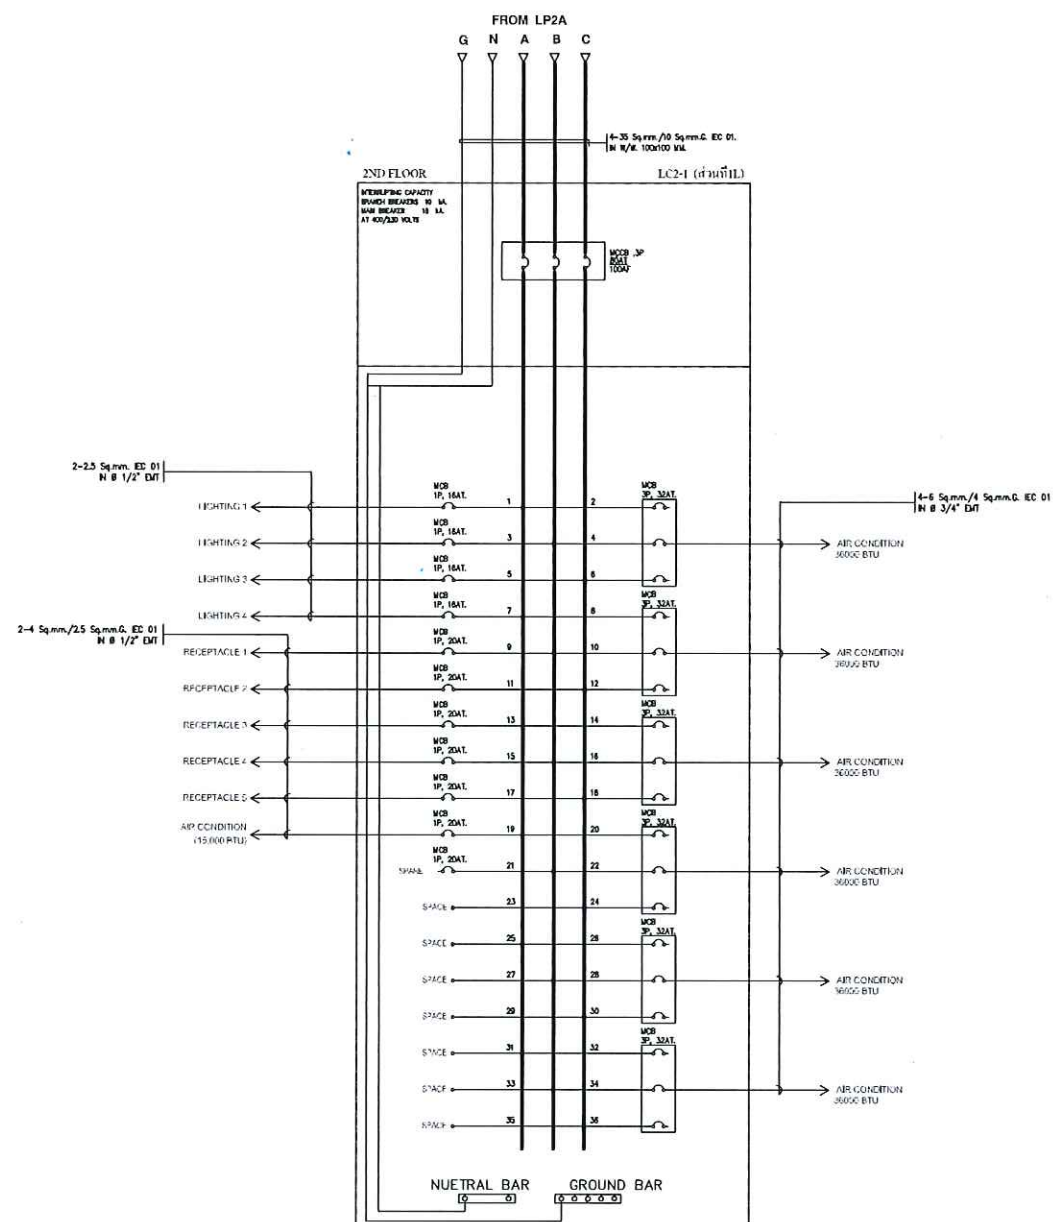

SINGLE LINE DIAGRAM PANEL LC 2-1

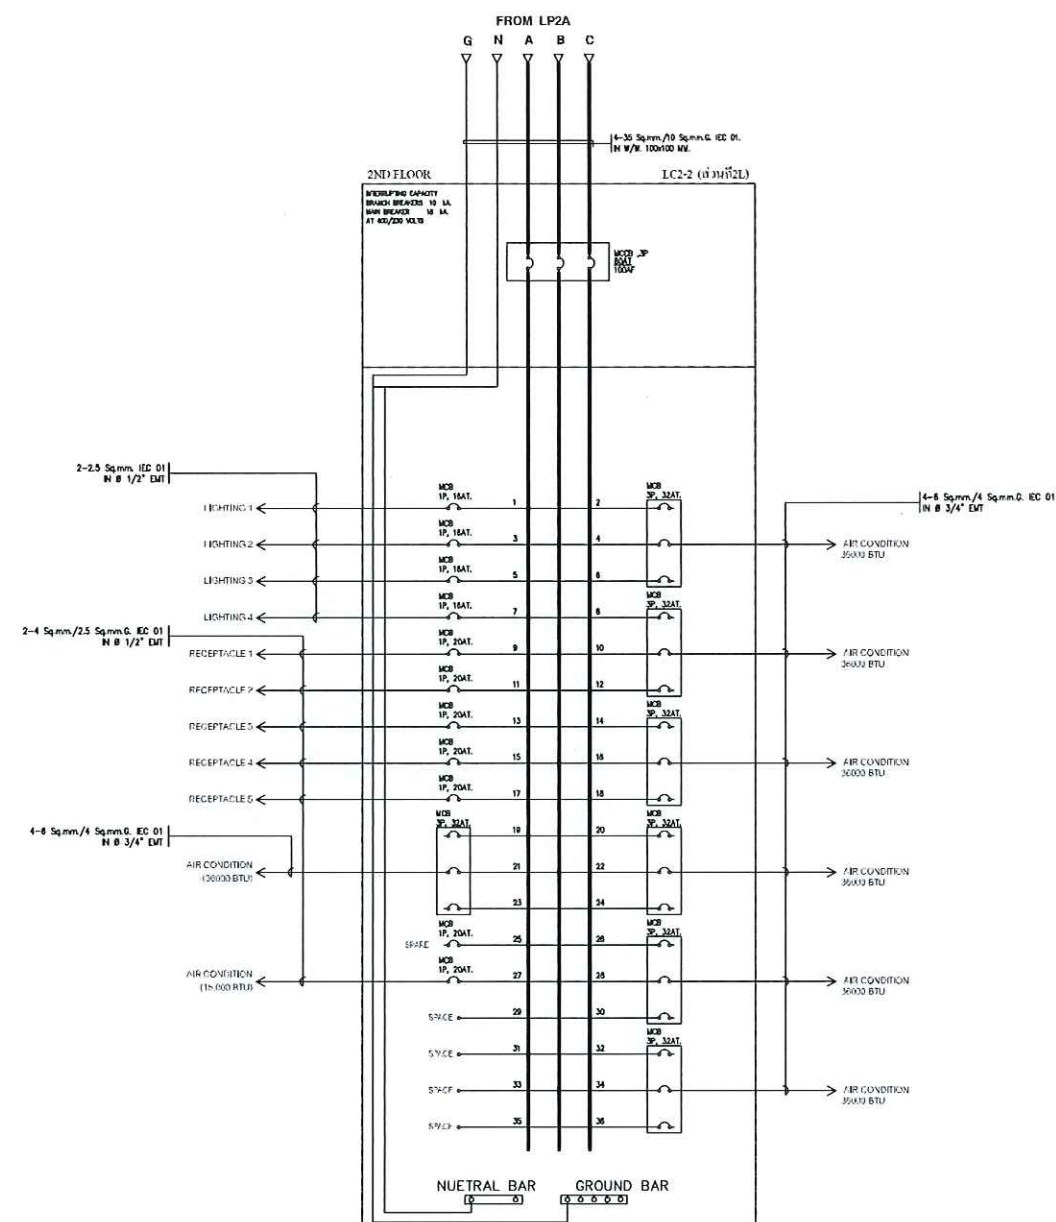

SINGLE LINE DIAGRAM PANEL LC 2-2

OWNER :

CONSULTANT :



King Mongkut's Institute
of Technology Ladkrabang
Chalongkrung Road, Ladkrabang, Bangkok 10520
TEL. (+66) 2-329-8000 , FAX. (+66) 2-329-8204

CONTRACTOR :

PRELIMINARY

KEY PLAN

ENGINEER CERTIFICATION

SIGNATURE
NAME SONGKRIT TRERATPICHAN
REGISTER No. ๖๗๙ 957

REVISION

No.	DATE	BY	DESCRIPTION
1	07/20/18	-	PRELIMINARY

REVISION OF DRAWING : 0

PROJECT NAME :

Excise Department

DRAWING TITLE :

LC 2_SINGLE LINE DIAGRAM

DRAWING No. :

EXD-20180720


SHEET : 1 OF : 5 SIZE : A3

DATE : SCALE :
NTS


DRAW BY :

CHECKED BY :

APPROVED BY :

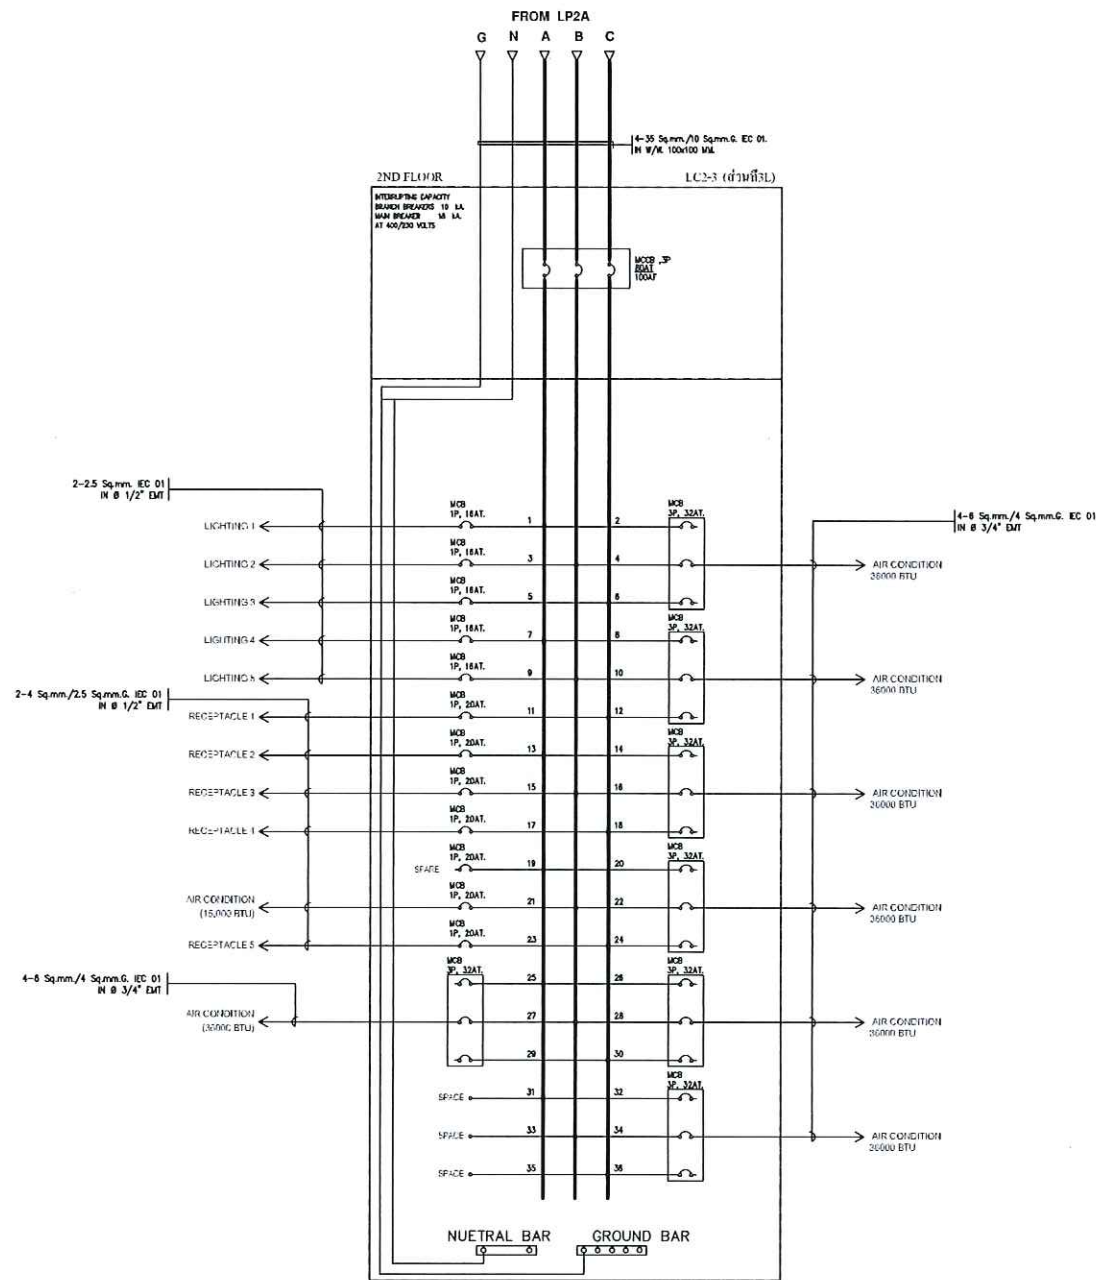

SINGLE LINE DIAGRAM PANEL LC 2-3

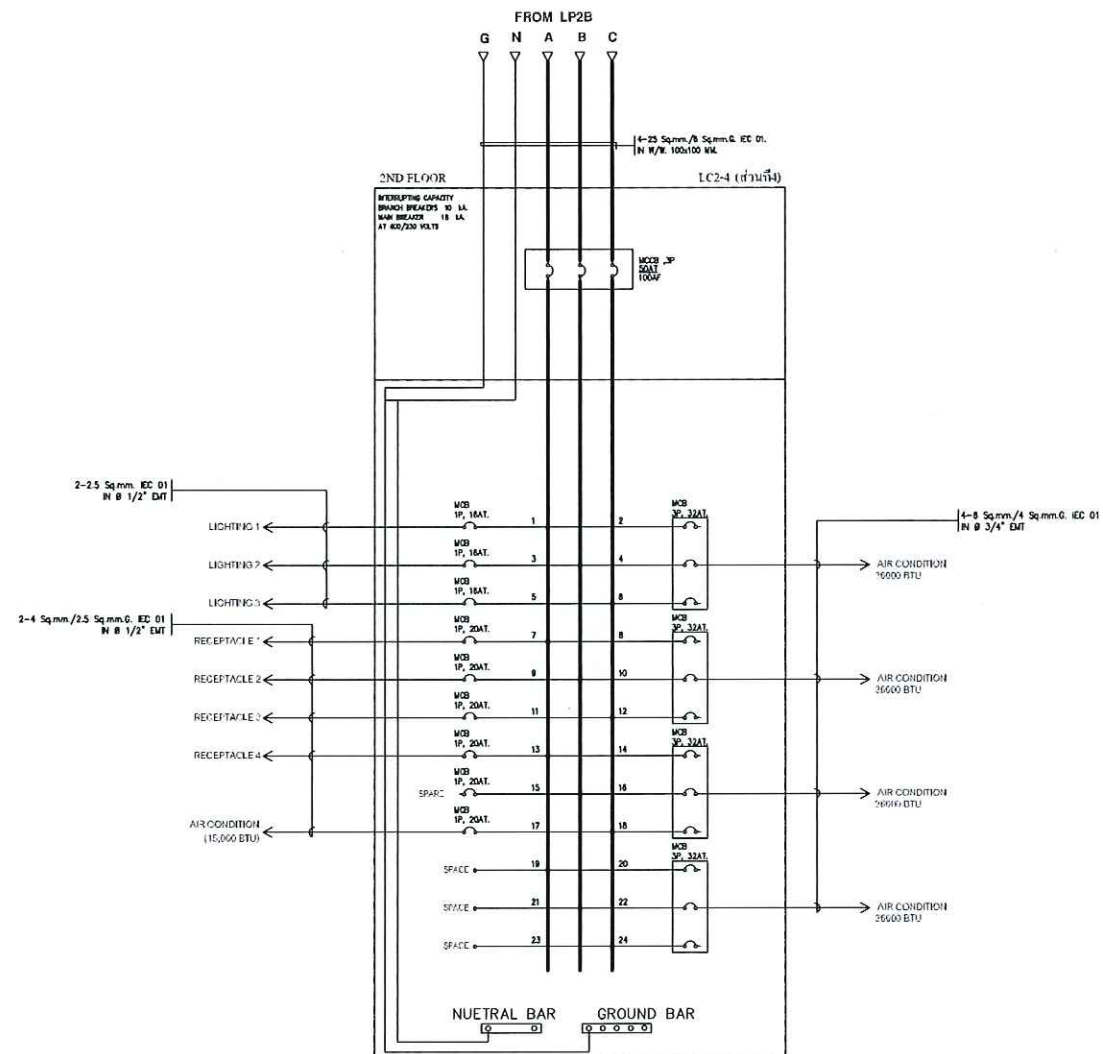

SINGLE LINE DIAGRAM PANEL LC 2-4

OWNER :

CONSULTANT :



King Mongkut's Institute
of Technology Ladkrabang
Chalongkrung Road, Ladkrabang, Bangkok 10520
TEL (+66) 2-329-8000 , FAX (+66) 2-329-8204

CONTRACTOR :

PRELIMINARY

KEY PLAN

ENGINEER CERTIFICATION

SIGNATURE	
NAME	SONGKRIT TRERATPICHAN
REGISTER No.	๖๗๙ ๙๕๗

REVISION

No.	DATE	BY	DESCRIPTION
1	07/20/18	-	PRELIMINARY

REVISION OF DRAWING : 0

PROJECT NAME :

Excise Department

DRAWING TITLE :

LC 2_SINGLE LINE DIAGRAM

DRAWING No. :

EXD-20180720


SHEET : 2 OF : 5 SIZE : A3

DATE : SCALE : NTS


DRAW BY :

CHECKED BY :

APPROVED BY :

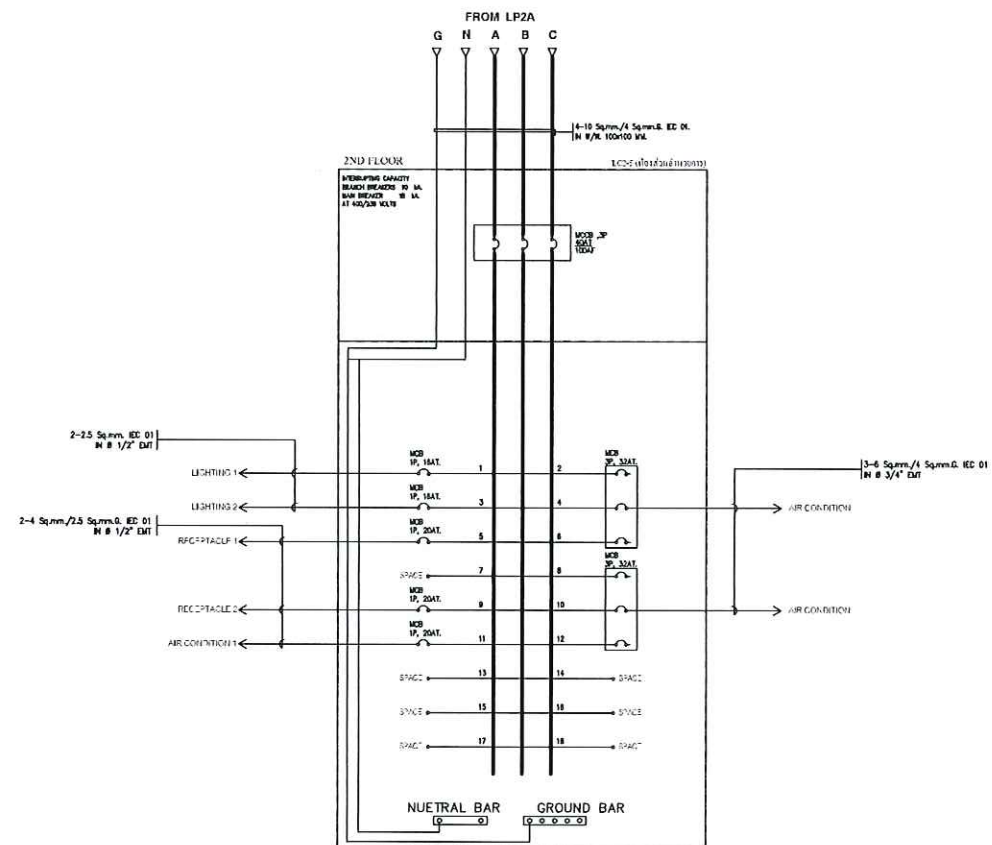

SINGLE LINE DIAGRAM PANEL LC 2-5

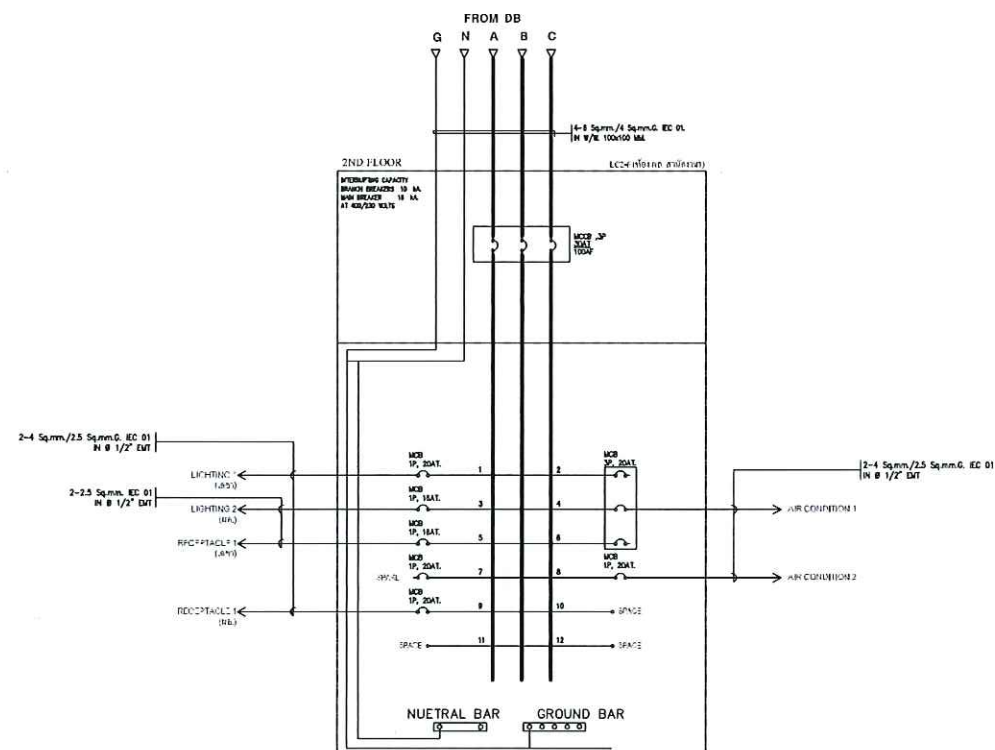

SINGLE LINE DIAGRAM PANEL LC 2-6

OWNER :

CONSULTANT :



King Mongkut's Institute
of Technology Ladkrabang
Chalongkrung Road, Ladkrabang, Bangkok 10520
TEL. (+66) 2-329-8000 , FAX. (+66) 2-329-8204

CONTRACTOR :

PRELIMINARY

KEY PLAN

ENGINEER CERTIFICATION

SIGNATURE	
NAME	SONGKRIT TRERATPICHAN
REGISTER No.	๖๗๓ ๙๕๗

REVISION

No.	DATE	BY	DESCRIPTION
1	07/20/18	-	PRELIMINARY

REVISION OF DRAWING : 0

PROJECT NAME :

Excise Department

DRAWING TITLE :

LC 2_SINGLE LINE DIAGRAM

DRAWING No. :


EXD-20180720

SHEET : 3	OF : 5	SIZE : A3
DATE :	SCALE :	NTS


DRAW BY :

CHECKED BY :

APPROVED BY :

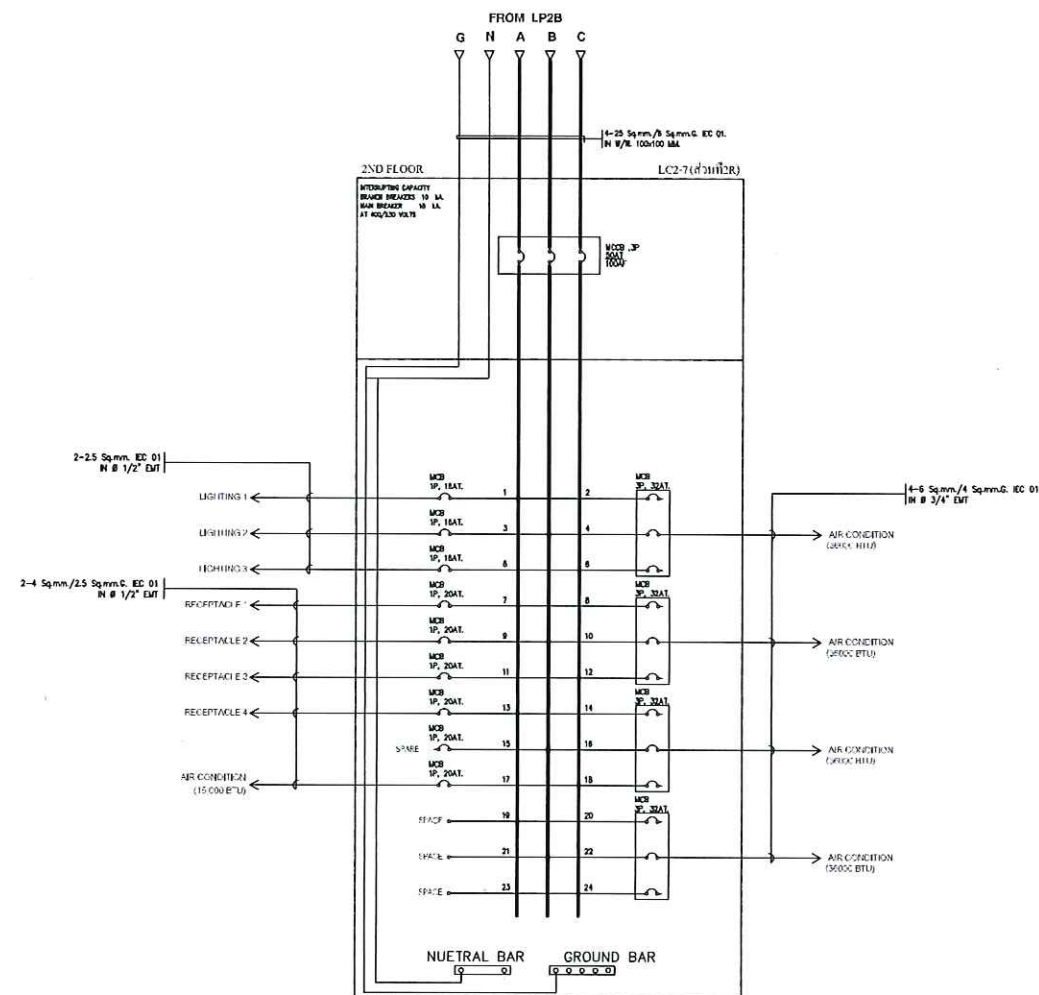

SINGLE LINE DIAGRAM PANEL LC 2-7

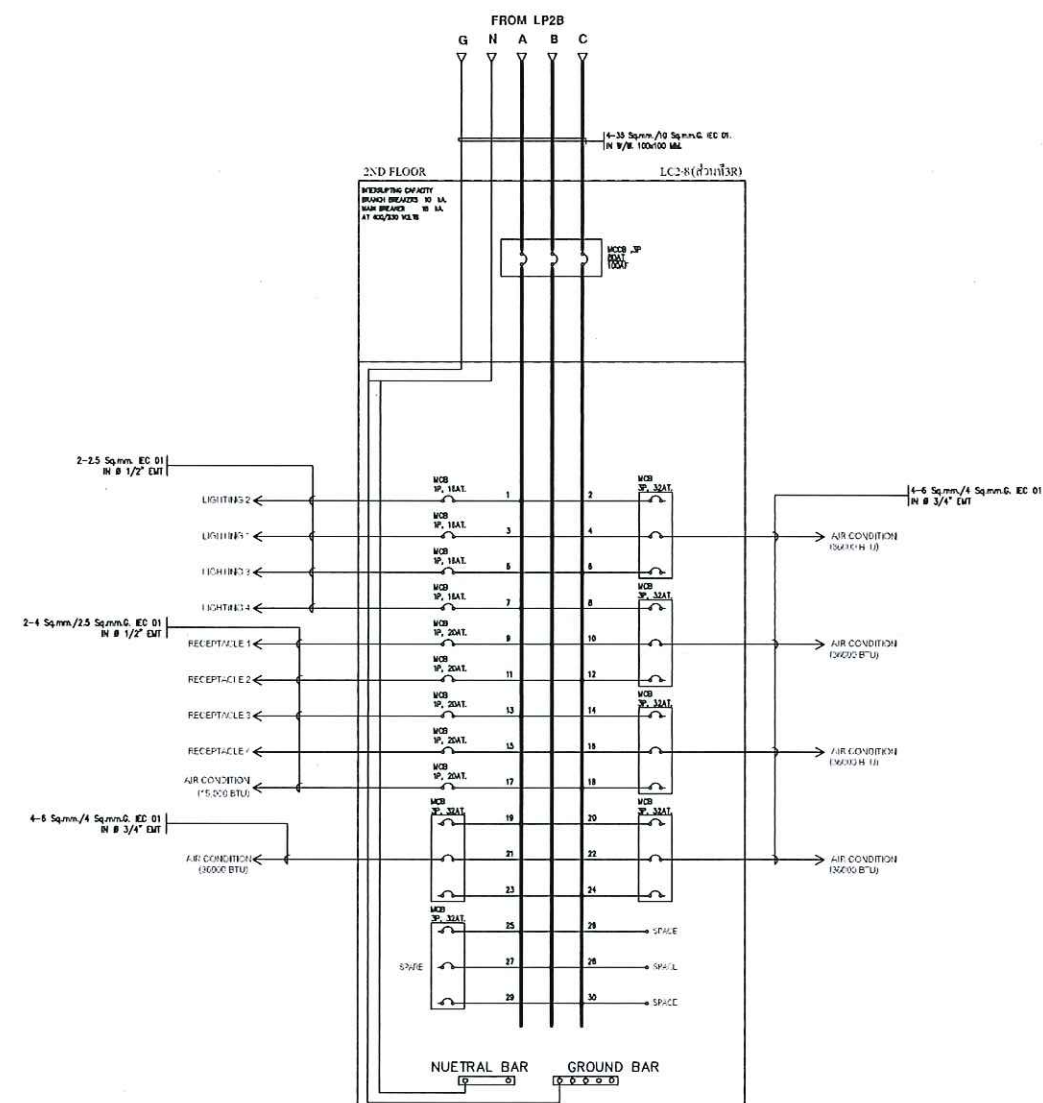

SINGLE LINE DIAGRAM PANEL LC 2-8

OWNER :

CONSULTANT :



King Mongkut's Institute
of Technology Ladkrabang
Chalongkrung Road, Ladkrabang, Bangkok 10520
TEL. (+66) 2-329-8000 , FAX. (+66) 2-329-8204

CONTRACTOR :

PRELIMINARY

KEY PLAN

ENGINEER CERTIFICATION

SIGNATURE 
NAME SONGKRIT TRERATPICHAN
REGISTER No. ๖๗ ๙๕๗

REVISION			
No.	DATE	BY	DESCRIPTION
1	07/20/18	-	PRELIMINARY

REVISION OF DRAWING : 0

PROJECT NAME :

Excise Department

DRAWING TITLE :


LC 2_SINGLE LINE DIAGRAM

DRAWING No. :


EXD-20180720

SHEET : 4	OF : 5	SIZE : A3
DATE :	SCALE :	NTS
DRAW BY :		
CHECKED BY :		
APPROVED BY :		



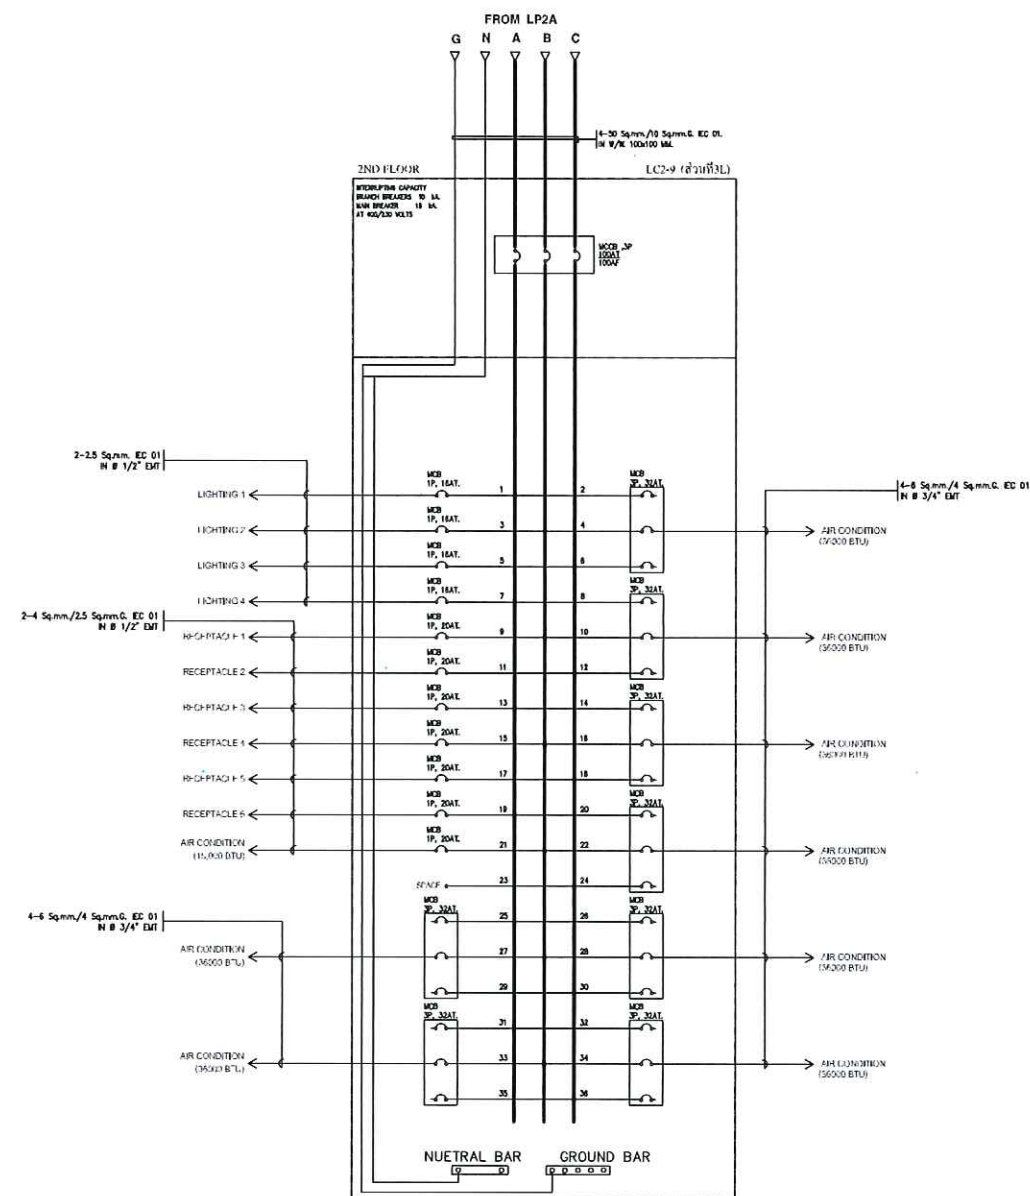

SINGLE LINE DIAGRAM PANEL LC 2-9

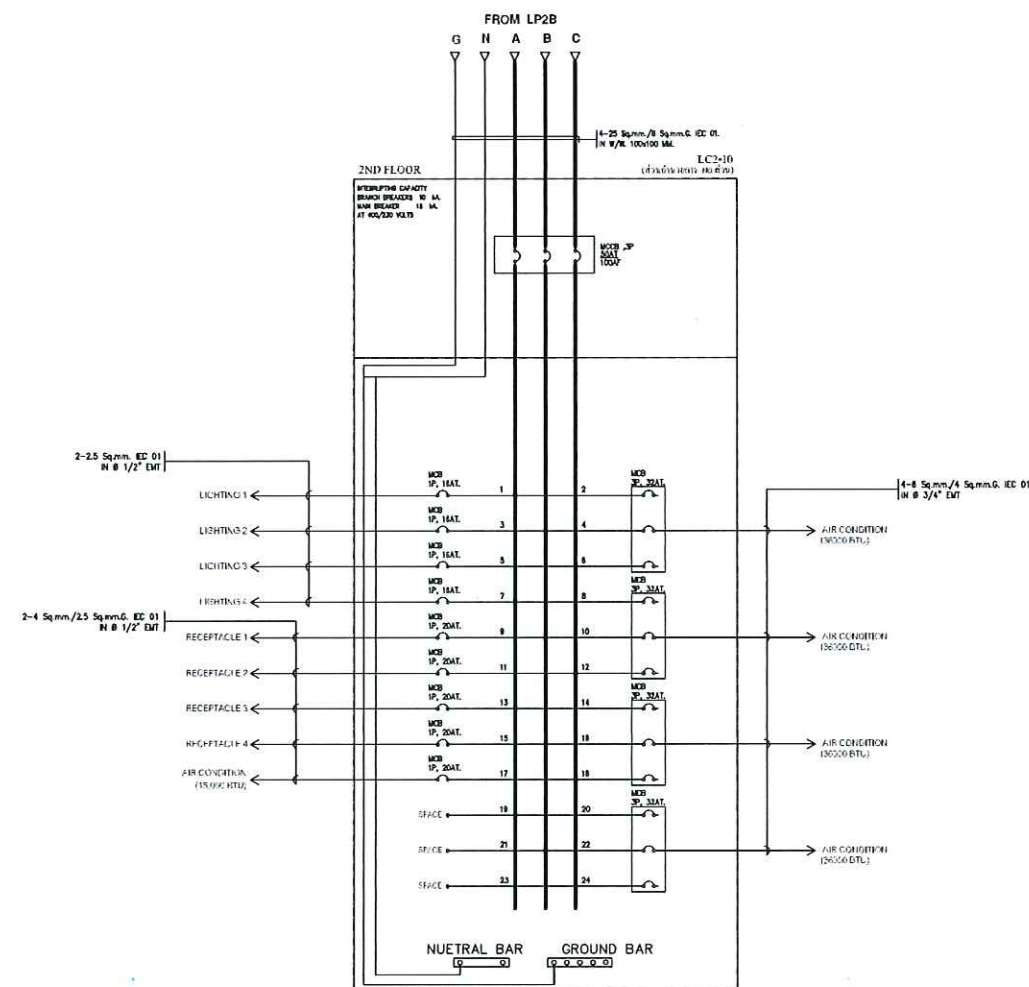

SINGLE LINE DIAGRAM PANEL LC 2-10

OWNER :

CONSULTANT :



King Mongkut's Institute
of Technology Ladkrabang
Chalongkrung Road, Ladkrabang, Bangkok 10520
TEL. (+66) 2-329-8000 , FAX. (+66) 2-329-8204

CONTRACTOR :

PRELIMINARY

KEY PLAN

ENGINEER CERTIFICATION

SIGNATURE	
NAME	SONGKRIT TRERATPICHAN
REGISTER No.	๖๗๙ ๙๕๗

REVISION			
No.	DATE	BY	DESCRIPTION
1	07/20/18	-	PRELIMINARY

REVISION OF DRAWING : 0

PROJECT NAME :

Excise Department


DRAWING TITLE :

LC 2_SINGLE LINE DIAGRAM

DRAWING No. :

EXD-20180720

SHEET : 5	OF : 5	SIZE : A3
DATE :	SCALE :	NTS
DRAW BY :		
CHECKED BY :		
APPROVED BY :		

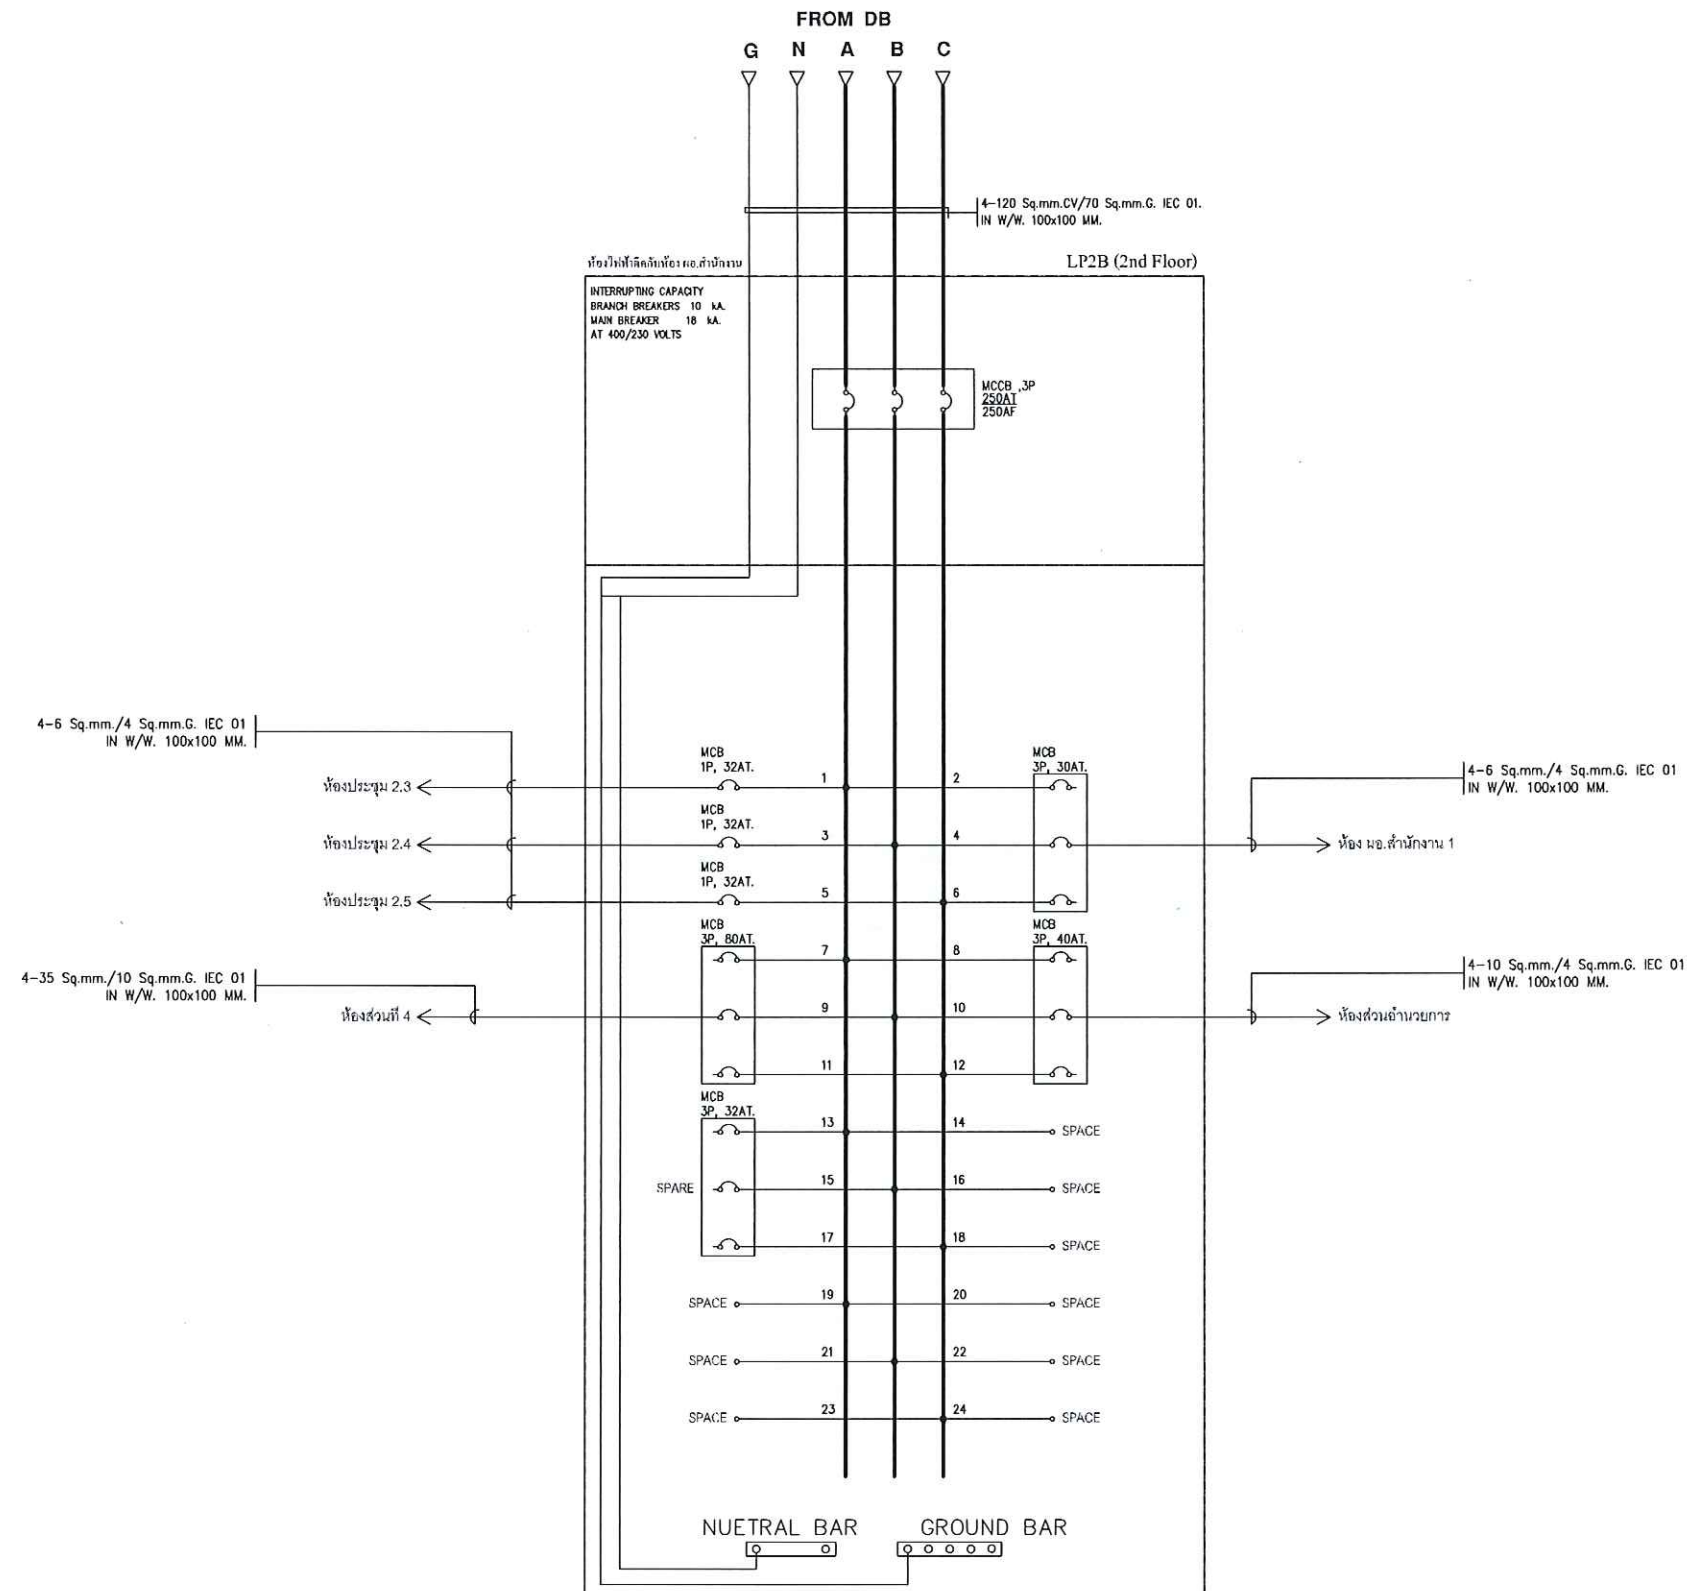**SINGLE LINE DIAGRAM PANEL LP2B**

OWNER :

CONSULTANT :



King Mongkut's Institute
of Technology Ladkrabang
Chalongkrung Road, Ladkrabang, Bangkok 10520
TEL. (+66) 2-329-8000 , FAX. (+66) 2-329-8204

CONTRACTOR :

PRELIMINARY

KEY PLAN

ENGINEER CERTIFICATION

SIGNATURE	
NAME	SONGKRIT TRERATPICHAN
REGISTER No.	รพท 957

REVISION

No.	DATE	BY	DESCRIPTION
1	07/20/18	-	PRELIMINARY

REVISION OF DRAWING : 0

PROJECT NAME :

Excise Department

DRAWING TITLE :

LP 2_SINGLE LINE DIAGRAM

DRAWING No. :

EXD-20180720


SHEET : 2 OF : 4 SIZE : A3

DATE : SCALE : NTS

DRAW BY :

CHECKED BY :

APPROVED BY :

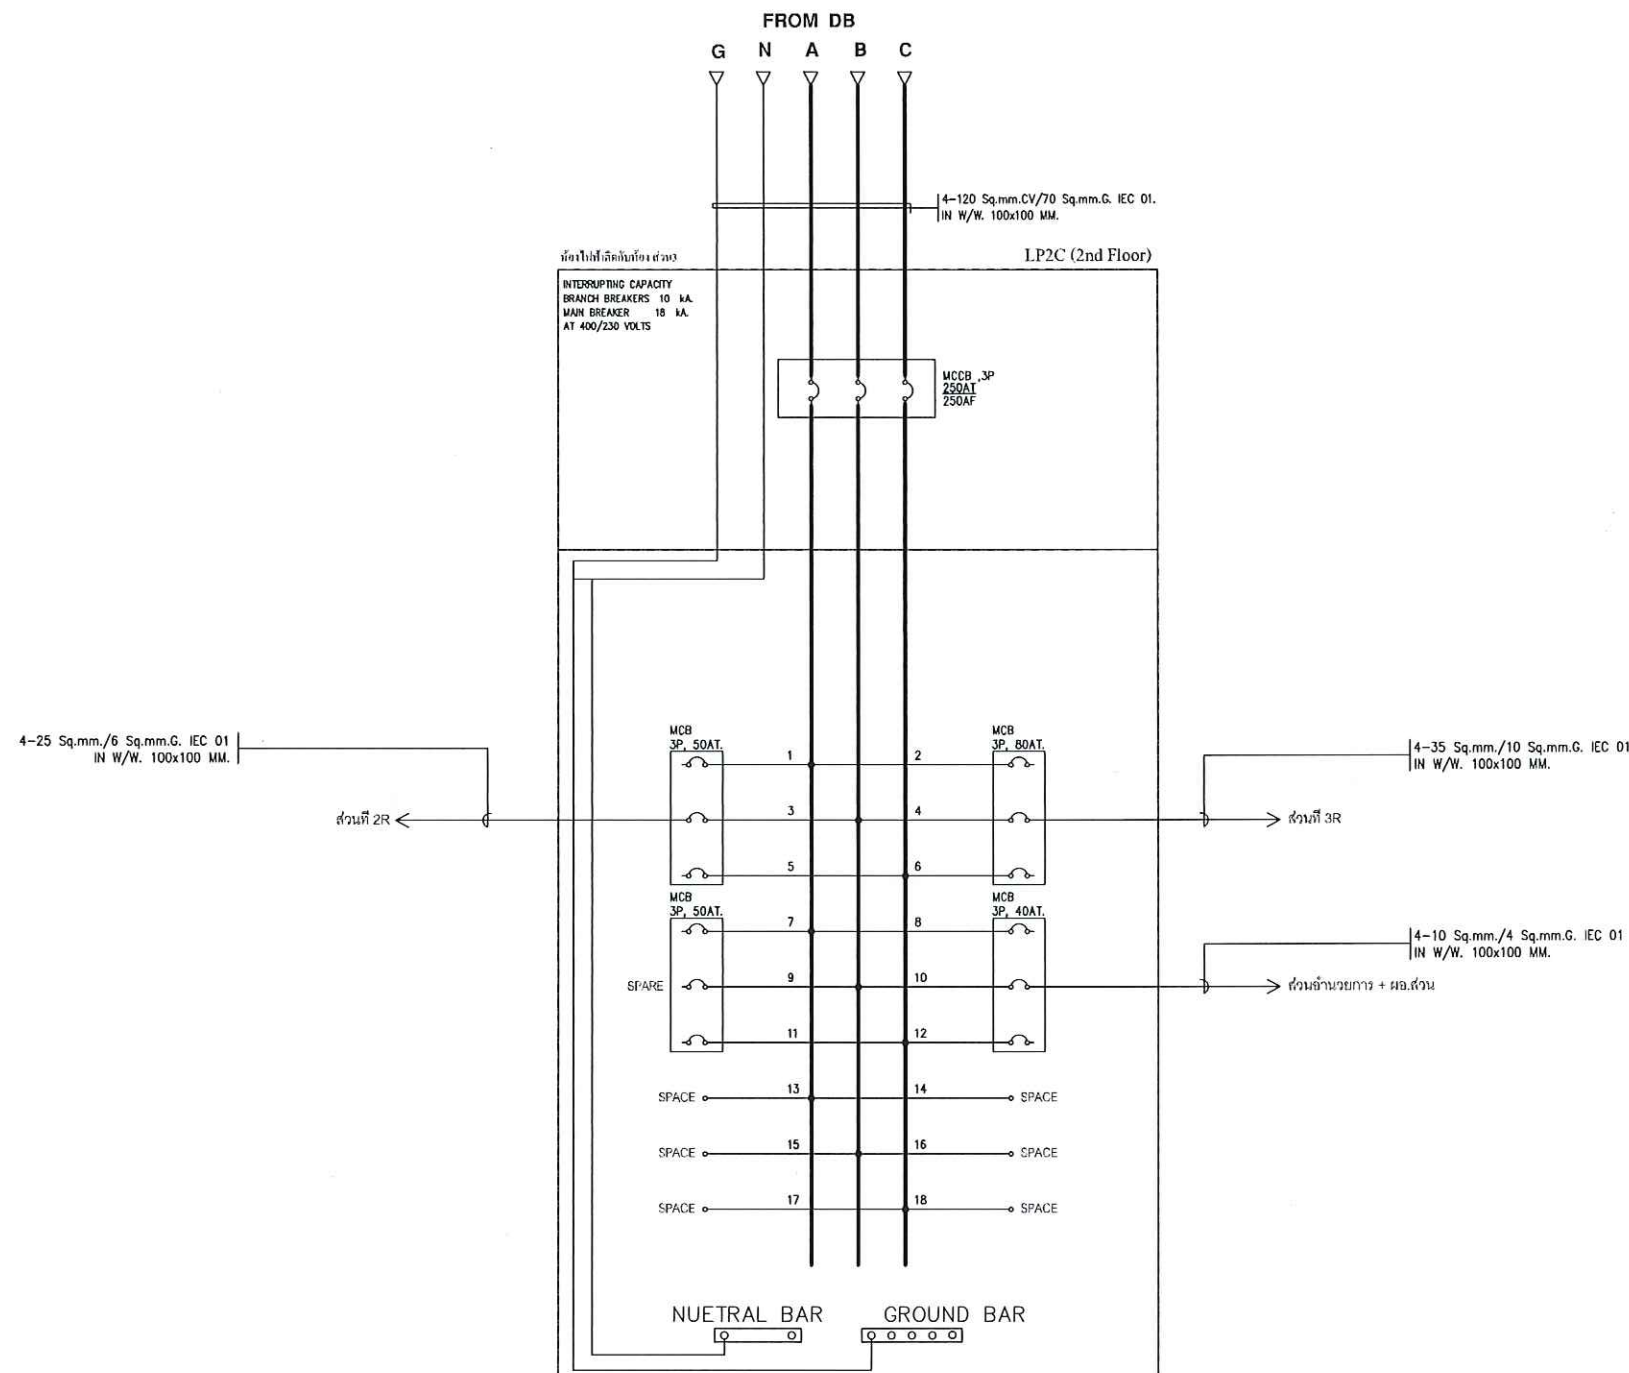

SINGLE LINE DIAGRAM PANEL LP2C

OWNER :

CONSULTANT :



King Mongkut's Institute
of Technology Ladkrabang
Chalongkrung Road, Ladkrabang, Bangkok 10520
TEL. (+66) 2-329-8000 , FAX. (+66) 2-329-8204

CONTRACTOR :

PRELIMINARY

KEY PLAN

ENGINEER CERTIFICATION

SIGNATURE
NAME SONGKRIT TRERATPICHAN
REGISTER No. ๖๗๙ ๙๕๗

REVISION

No.	DATE	BY	DESCRIPTION
1	07/20/18	-	PRELIMINARY

REVISION OF DRAWING : 0

PROJECT NAME :

Excise Department

DRAWING TITLE :

LP 2_SINGLE LINE DIAGRAM

DRAWING No. :


EXD-20180720

SHEET : 3 OF : 4 SIZE : A3
DATE : SCALE : NTS
DRAW BY :
CHECKED BY :
APPROVED BY :



2/2/20

APPROVED BY :

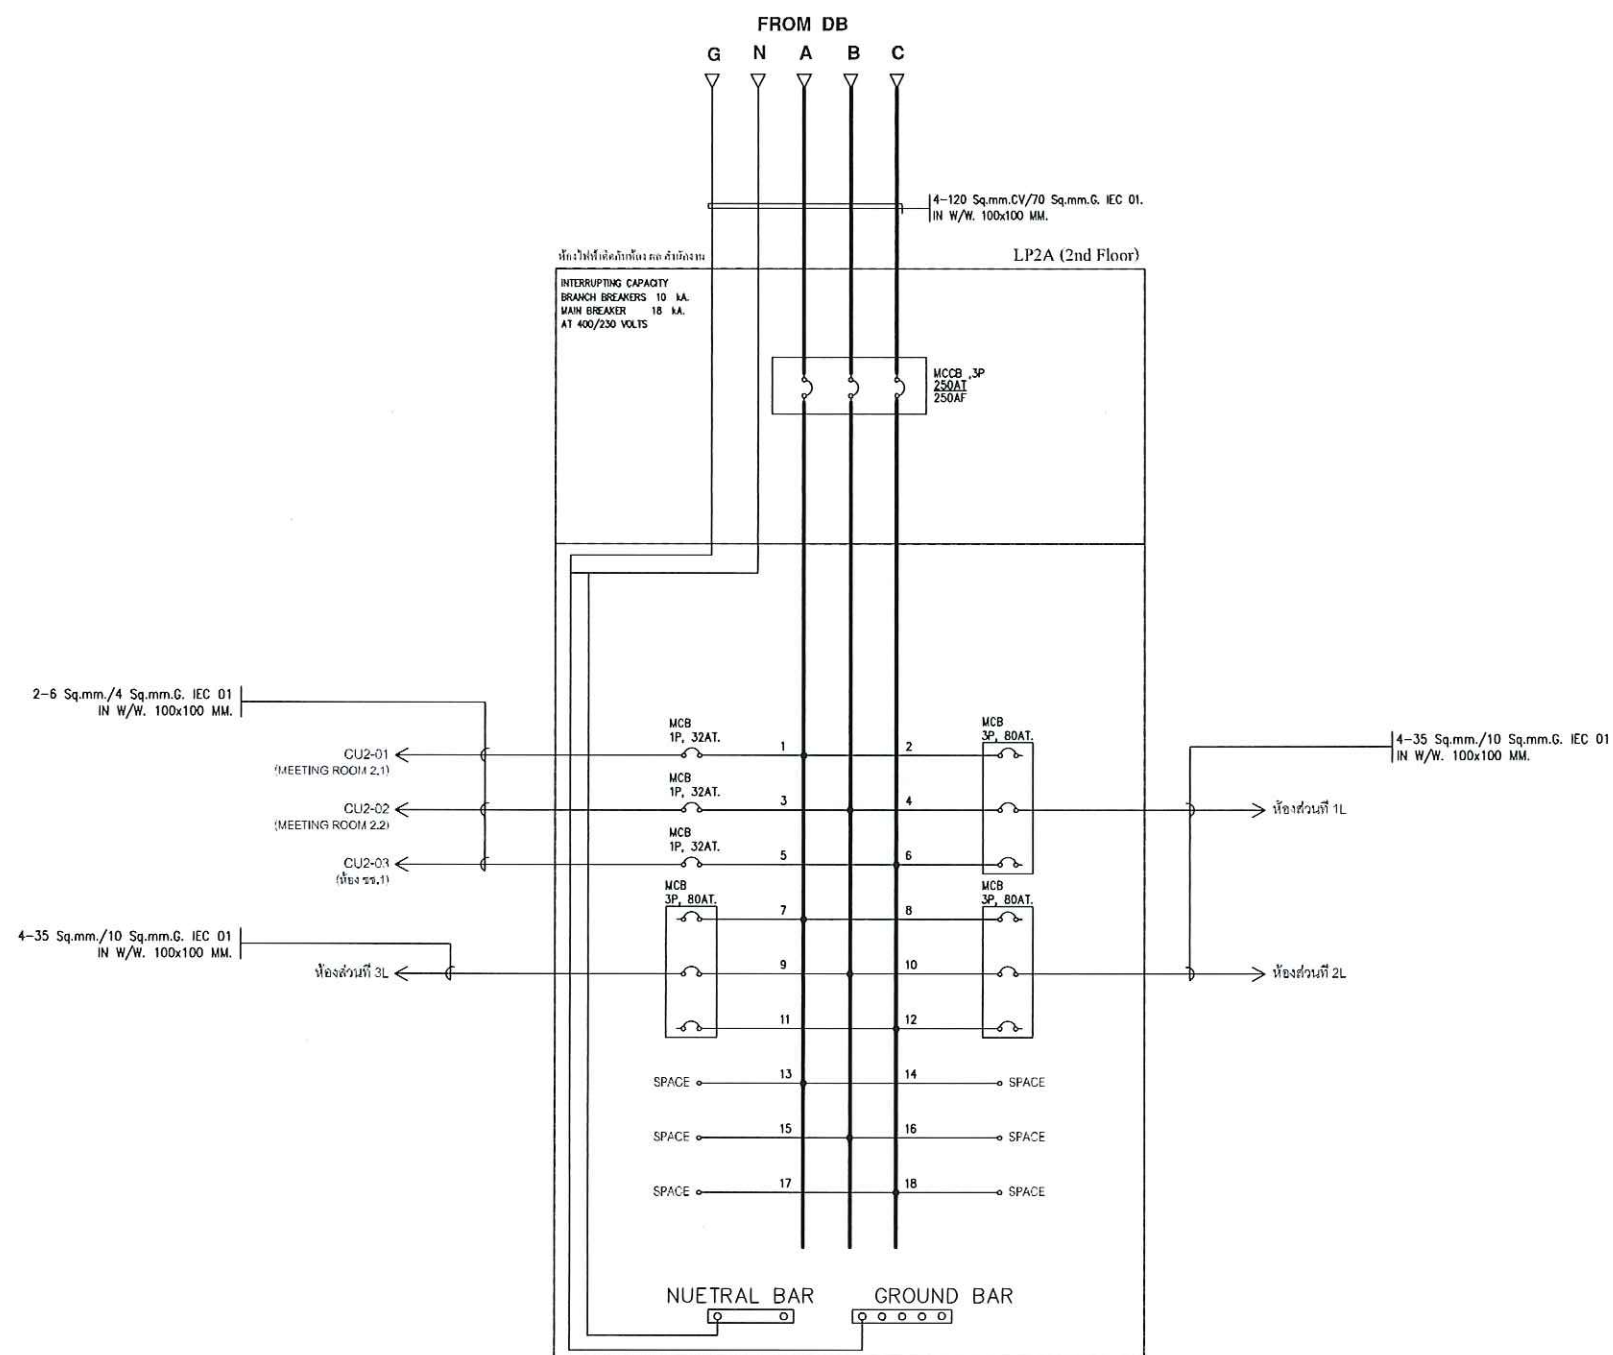

SINGLE LINE DIAGRAM PANEL LP2A

OWNER :

CONSULTANT :



King Mongkut's Institute
of Technology Ladkrabang
Chalongkrung Road, Ladkrabang, Bangkok 10520
TEL. (+66) 2-329-8000 , FAX. (+66) 2-329-8204

CONTRACTOR :

PRELIMINARY

KEY PLAN

ENGINEER CERTIFICATION

SIGNATURE

NAME SONGKRIT TRERATPICHAN

REGISTER No. วทก 957

REVISION			
No.	DATE	BY	DESCRIPTION
1	07/20/18	-	PRELIMINARY

REVISION OF DRAWING : 0

PROJECT NAME :

Excise Department

DRAWING TITLE :

LP 2_SINGLE LINE DIAGRAM

DRAWING No. :

EXD-20180720


SHEET : 1 OF : 4 SIZE : A3

DATE : SCALE : NTS

DRAW BY :

CHECKED BY :

APPROVED BY :

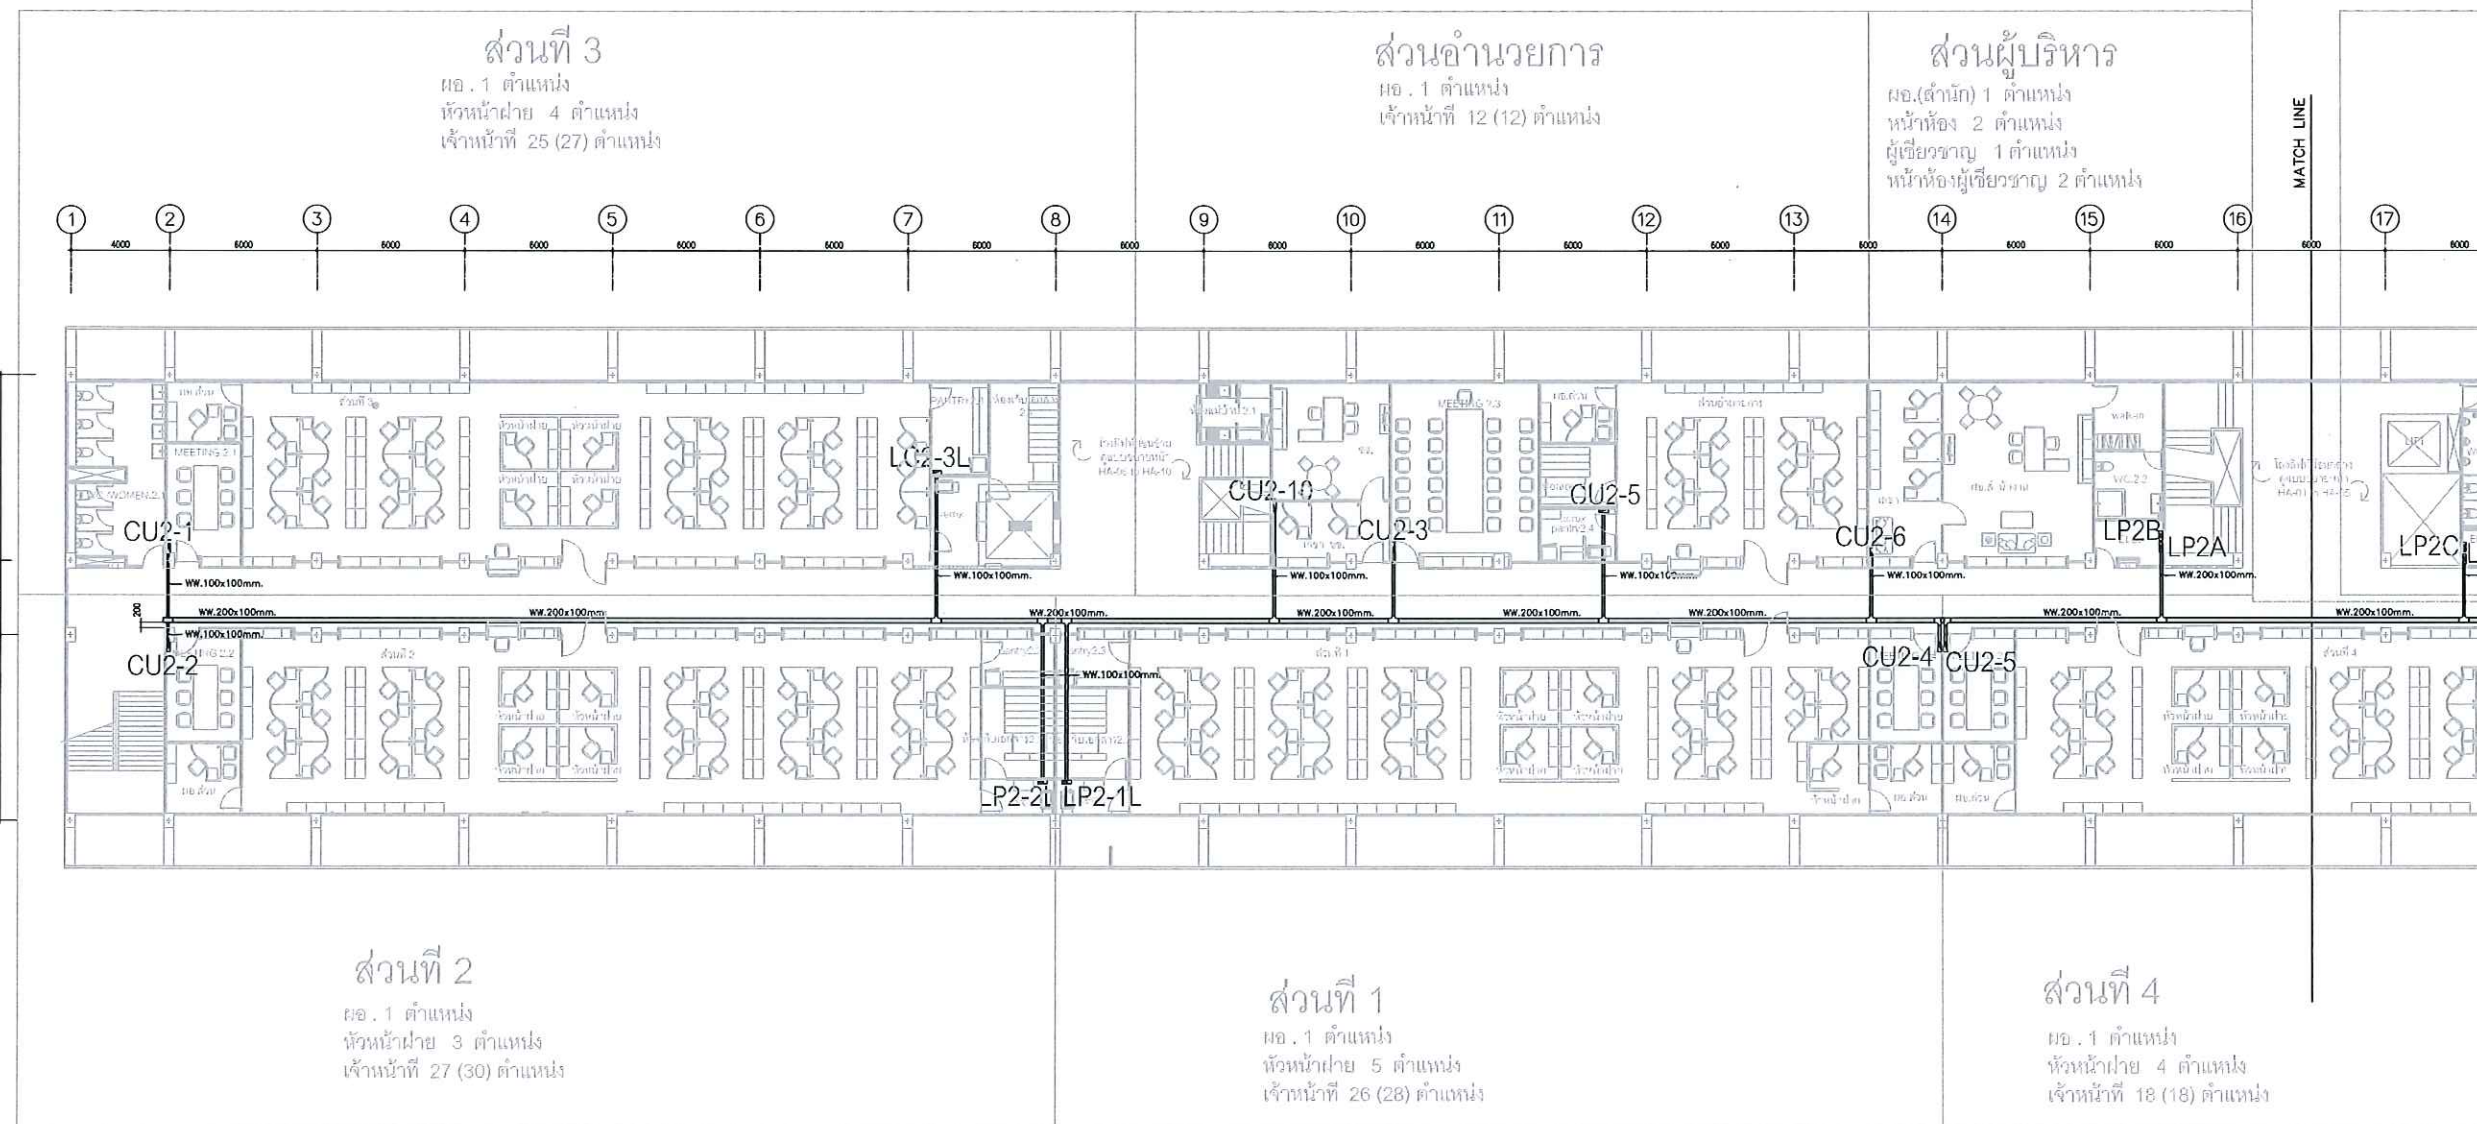

ผังรวมระบบไฟฟ้า ชั้น 2 ส่วนที่ 1

OWNER :

CONSULTANT :



 
King Mongkut's Institute
of Technology Ladkrabang
Chalongkrung Road, Ladkrabang, Bangkok 10520
TEL. (+66) 2-329-6000 , FAX. (+66) 2-329-8204

CONTRACTOR :

PRELIMINARY

KEY PLAN

ENGINEER CERTIFICATION

SIGNATURE 
NAME SONGKRIT TRERATPICHAN
REGISTER No. วฟก 957

REVISION			
No.	DATE	BY	DESCRIPTION
1	07/20/18	-	PRELIMINARY

REVISION OF DRAWING : 0

PROJECT NAME :

Excise Department

DRAWING TITLE :

2nd FLOOR PLAN

DRAWING No. :

EXD-20180720

SHEET : 1 OF : 2 SIZE : A3

DATE : SCALE : 1:300

DRAW BY :

CHECKED BY :

APPROVED BY :

